

SITE NOTES

- 1 COORDINATE EXACT STUB-UP OF ALL CONDUIT WITH OWNER.
- 2 ALL CONDUITS TO BE UNDERGROUND UNLESS NOTED OTHERWISE.
- 3 COORDINATE EXACT ELECTRICAL REQUIREMENTS WITH INSTALLED EQUIPMENT.

HFA
ARCHITECTS
ENGINEERS
INTERIORS
HARRISON FRENCH
& ASSOCIATES, PLLC
1705 S. Winston Blvd., Suite 3
Winston-Salem, NC 27157
Phone: 703.273.7700
Fax: 703.273.9685
www.hfa-ae.com

STIPULATION FOR REUSE
THIS DRAWING WAS PREPARED FOR USE ON A SPECIFIC SITE AT WINSTON-SALEM, NC. IT IS NOT BE REUSED FOR ANY OTHER PROJECT WITHOUT THE WRITTEN CONSENT OF HARRISON FRENCH & ASSOCIATES, PLLC. ANY REUSE OF THIS DRAWING FOR ANY OTHER PROJECT WITHOUT THE WRITTEN CONSENT OF HARRISON FRENCH & ASSOCIATES, PLLC IS UNAUTHORIZED AND MAY BE CONSIDERED A VIOLATION OF THE PROFESSIONAL ENGINEERING ACT.

SAM'S MART
4965 UNIVERSITY PARKWAY
WINSTON-SALEM, NC 27106
JOB NUMBER: 07-17-80003


ISSUE BLOCK

STORE NO.:
DOCUMENT DATE: 06-08-17
CHECKED BY: JAC
DRAWN BY: KRS
PROTO CYCLE MAY-2017

HARRISON FRENCH
AND ASSOCIATES, PLLC
P-0402
6.6.17

**ELECTRICAL
SITE PLAN**

SHEET: **FSE6**

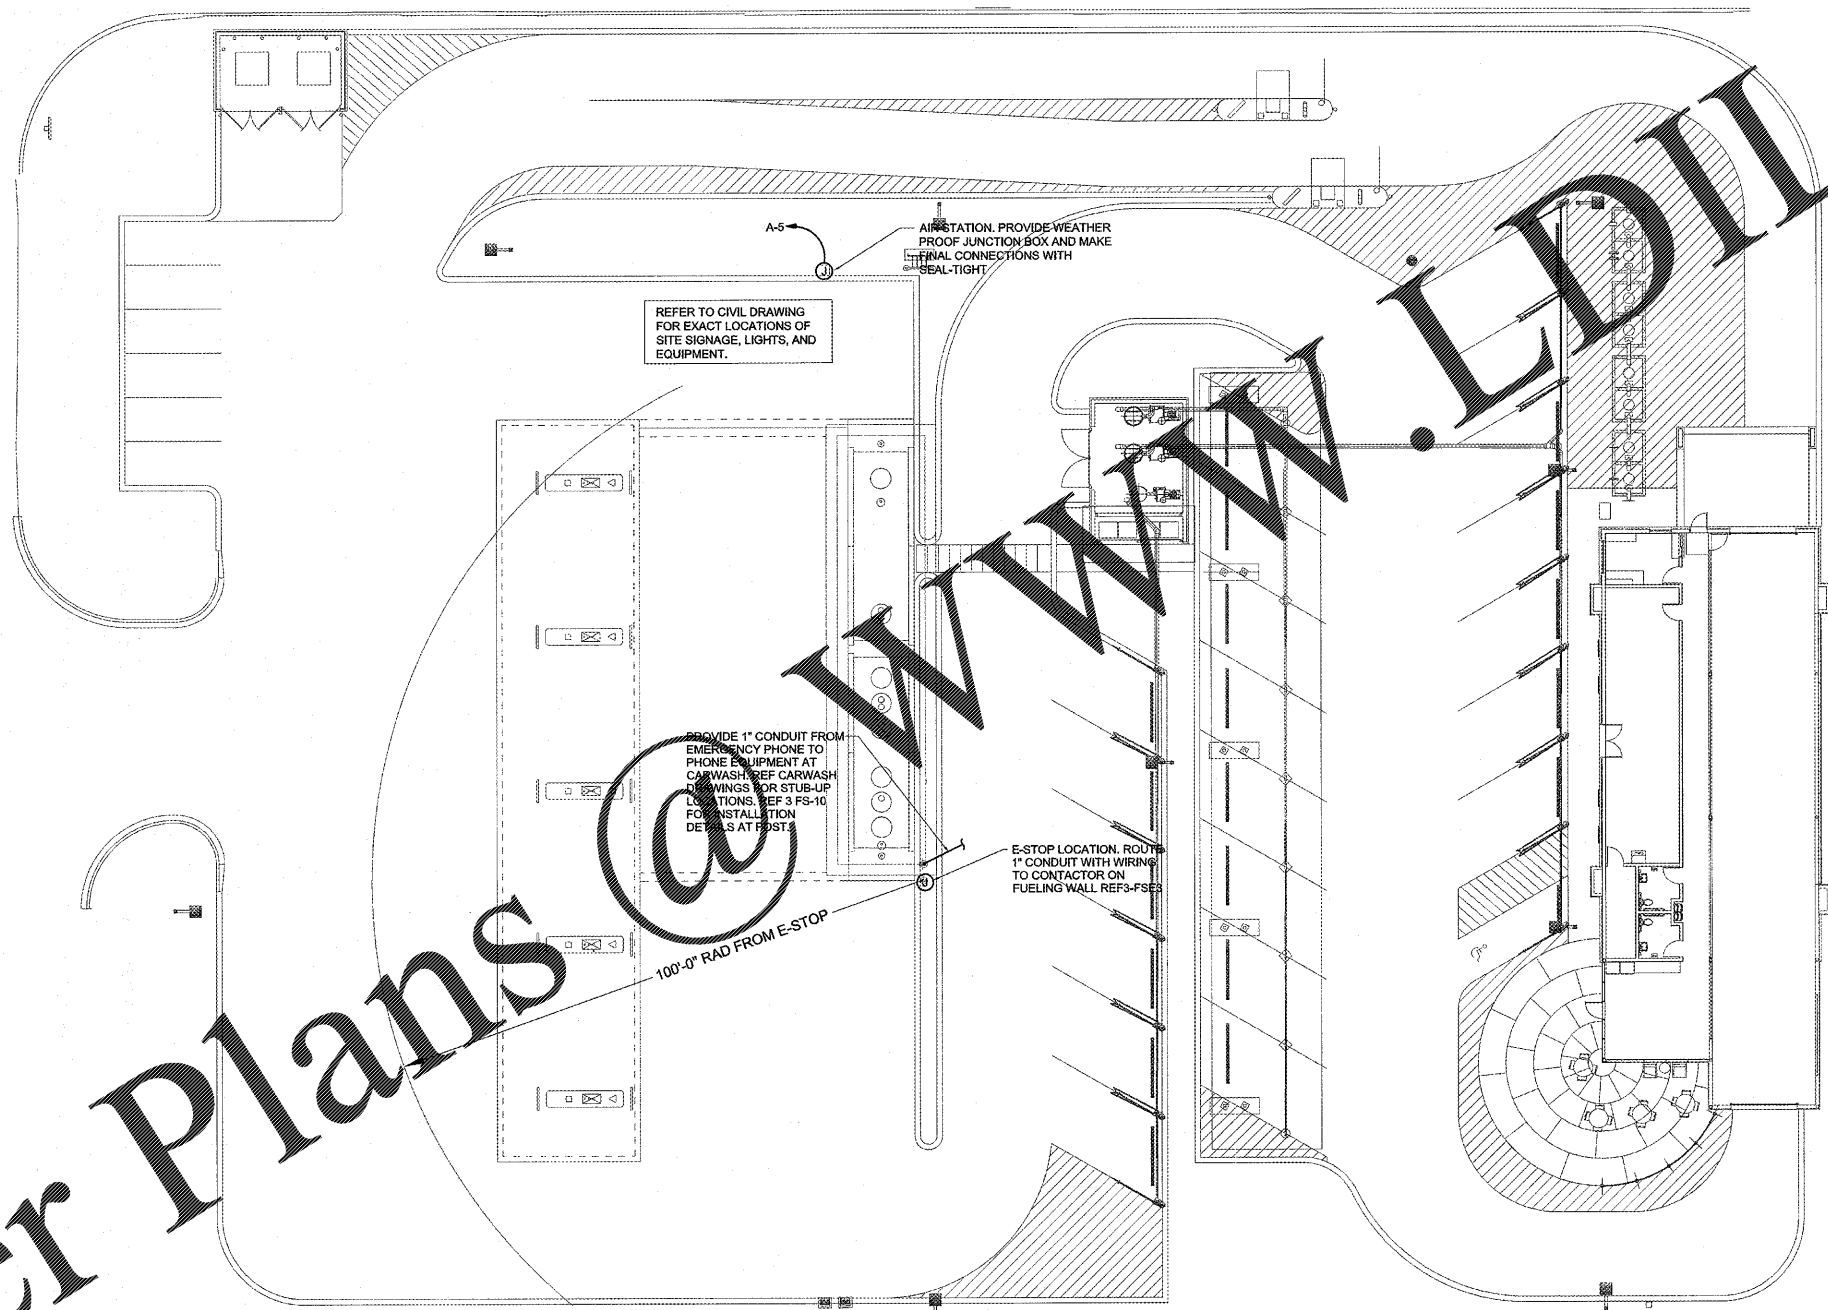

1 ELECTRICAL SITE PLAN
SC 1" = 20'-0"

Order Plans @ www.LDILine.com

Jun08.2017:5:03pm - User: krc, actual
K:\2017-17-80003_Sams_Mart - Winston-Salem, NC\HFA\SAM\Sheet\FSE6 - FSE6 ELECTRICAL SITE PLAN.dwg