


Order Plans @

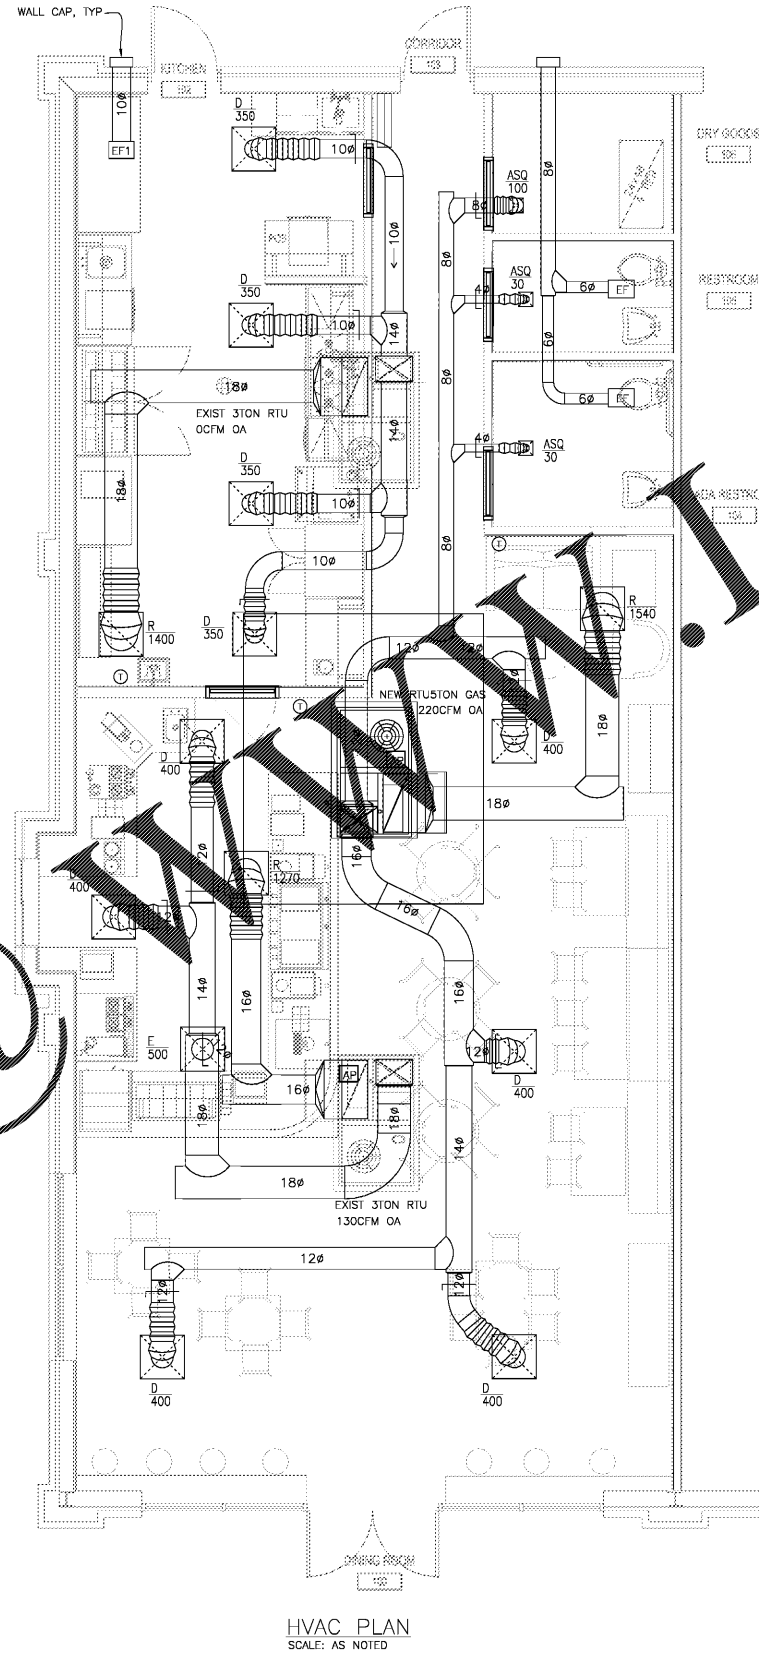

HVAC PLAN  
SCALE: AS NOTED



INTERIOR SPACE PLANNING  
111 S. AUGUSTINE ST. #20901  
4.4800 706.721.8000 (FAX)



|  |               |
|--|---------------|
| <b>ROOTED<br/>COFFEE HOUSE</b>                     |               |
| <b>3116 WILLIAM FEW PARKWAY<br/>EVANS, GEORGIA</b> |               |
| Approved by:                                       | Date: 7/19/16 |

Print Record  
7-21-16 REVIEW

Revisions

Sheet Title  
HVAC PLAN

Sheet No.

M-1

Scale:  
1/4"=1'-0"



9/22/17