



DEMO & NEW CONSTRUCTION NOTES:


- ◇ REMOVE EXISTING PANEL L, SUITE L METER AND DISCONNECT AND RETURN TO OWNER.
- ◇ REMOVE EXISTING HOUSE PANEL H FROM WIRING TROUGH AND RELOCATE TO RIGHT HAND SIDE OF TROUGH, SEE RISER DIAGRAM. INSTALL HOUSE PANEL CIRCUIT PER ORIGINAL SHELL PACKAGE DRAWINGS
- ◇ INSTALL NEW TELEPHONE DATA BACKBOARD ABOVE DOOR IN ROOM 106. VERIFY WITH AHJ AND OWNER THAT THIS IS AN ACCEPTABLE LOCATION. EXTEND EXISTING PVC CONDUIT LOCATED ON BACK WALL W/ PULL STRINGS TO NEW LOCATION OF COMMUNICATIONS BACK BOARD
- ◇ INSTALL NEW PANEL L BEHIND DOOR IN ROOM 106. VERIFY WITH AHJ THAT THIS LOCATION IS ACCEPTABLE PER NEC ART 110.26. ADD NEW 2" PVC CONDUIT FROM OLD PANEL LOCATION TO NEW PANEL LOCATION
- ◇ INSTALL NEW 400 AMP METER CENTER AND NEW 400 AMP NEMA 3R DISCONNECT AS SHOWN IN NEW RISER DIAGRAM. INSTALL NEW #4 250 KCMIL THWN-2 CU IN EXISTING 2" PVC CONDUIT TO NEW PANEL L LOCATION
- ◇ EC TO REFERENCE KITCHEN SUPPLIERS INSTALLATION DRAWINGS FOR EXACT MOUNTING HT OF RECEPTACLES FOR ALL KITCHEN EQUIPMENT

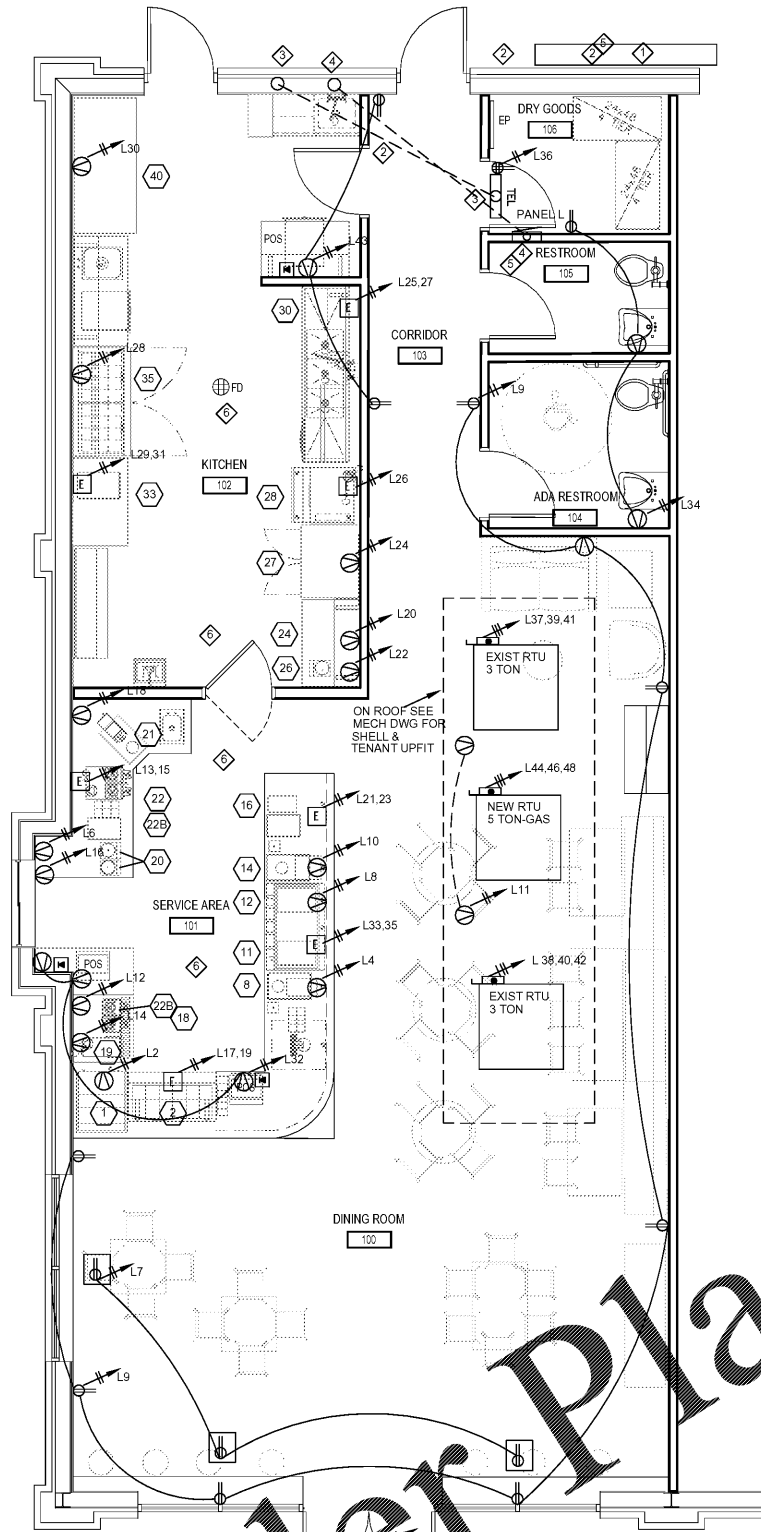

1 ELECTRICAL NEW WORK POWER PLAN
 E-2 SCALE: 1/4" = 1'-0"

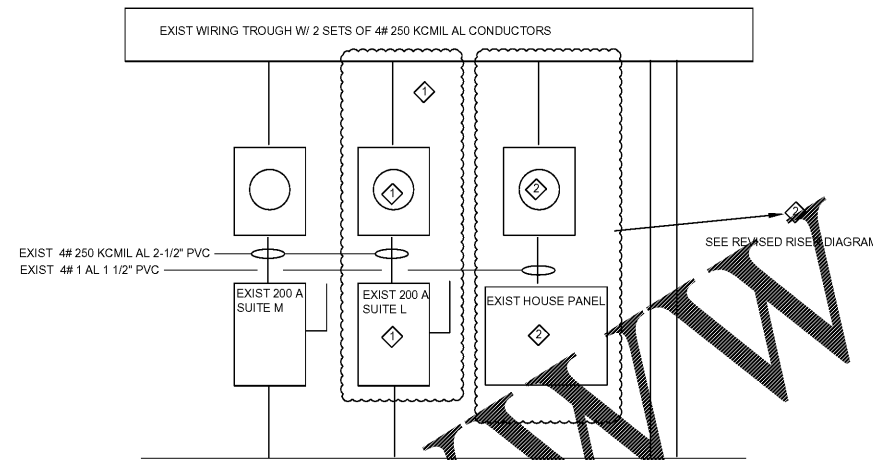

1 EXIST POWER RISER DIAGRAM
 E-2 SCALE: NONE

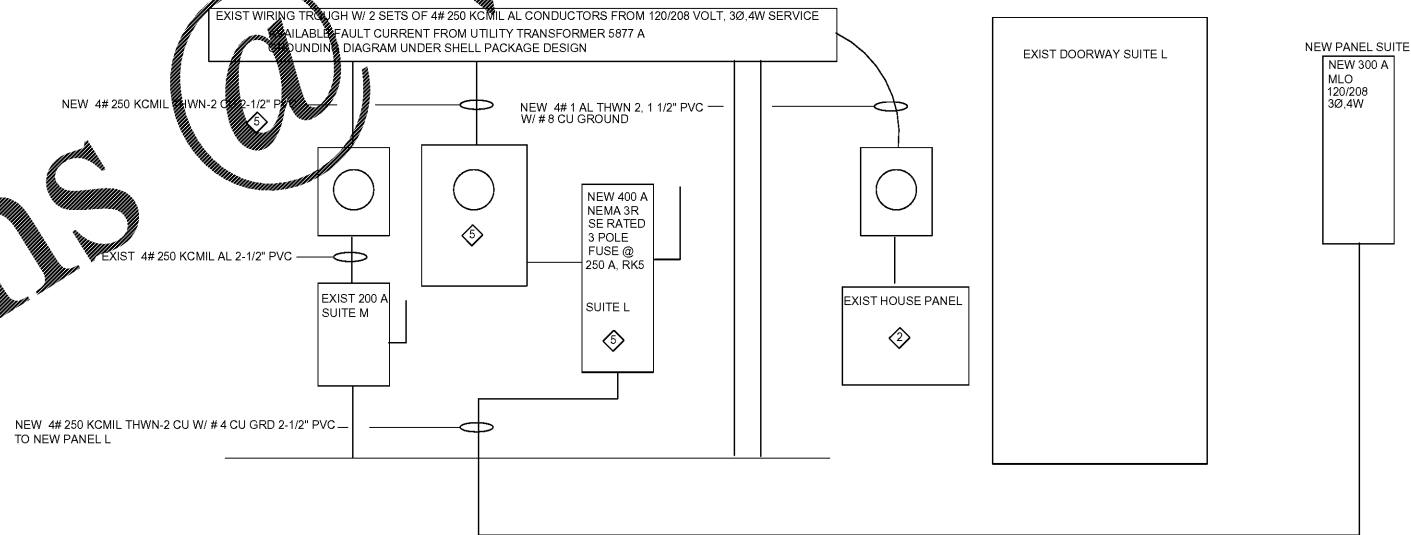

1 NEW POWER RISER DIAGRAM
 E-2 SCALE: NONE

ROOTED COFFEE HOUSE
 3116 WILLIAM FEW PARKWAY
 EVANS, GEORGIA
 Approved by: _____ Date: 7/19/16

Print Record
 7-21-16 REVIEW

Revisions

Sheet Title

POWER PLAN

Sheet No.

E-2

Scale:



Order Plans

WWW.LDILine.com