

1 ENLARGED RESTROOM PLAN  
3/4" = 1'-0"

### TOILET ACCESSORY SCHEDULE


MARK	DESCRIPTION	MANUFACTURER	OWNER	OWNER
TA1	36" GRAB BAR	BOBRICK 1-1/2" DIA. MODEL #B-6806, SERIES 36" LONG	OTHERS	OTHERS
TA2	42" GRAB BAR	BOBRICK 1-1/2" DIA. MODEL #B6806, SERIES 42" LONG	OTHERS	OTHERS
TA3	TOILET TISSUE DISPENSER	BOBRICK MODEL # B-288	OWNER	OWNER
TA4	TOWEL DISPENSER	BOBRICK MODEL # B-262	OWNER	OWNER
TA5	BABY CHANGING STATION	KOALA BEAR KARE	OWNER	OWNER
TA6	SOAP DISPENSER	SUPPLIED BY OWNER	OWNER	OWNER
TA7	MIRROR	(2) 1/4" CLEAR PLATE GLASS MIRROR, 3'-7"H x 1'6"-W	G.C.	G.C.
TA9	SANITARY NAPKIN DISPOSAL	BOBRICK MODEL # B-270	OWNER	OWNER
TA10	18" GRAB BAR	BOBRICK 1-1/2" DIA. MODEL # B-6806, SERIES 18" LONG	OWNER	OWNER
TA12	HAND DRYER	WORLD DRYER VERDRI MODEL # Q-162A BTM. OF AIR DISPENSER 43"	OWNER	OWNER

### FINISH SCHEDULE


MARK	DESCRIPTION
B1	2X8" WOOD (PINE) STAIN (V.I.F.-MATCH EXISTING)
B2	AMERICAN OLEAN - QUARRY TILE BASE TO MATCH F4; INSTALLED OVER BACKBOARD
C1	PAINT ALL EXPOSED STRUCTURE, CONDUIT, HVAC, DUCTS, ETC. "FLAT BLACK" OR ACOUSTICAL PAINT (V.I.F.-MATCH EXISTING)
C2B	WATER RESISTANT GYPSUM BOARD - PAINTED SW 7012, CREAMY
C4	ROUGH SAWN CEDAR RAFTERS 2X8" @ 24" O.C. (V.I.F.-MATCH EXISTING)
C5	CORRUGATED 2 1/2" GALVALUME (26 GAUGE)
F3	CONCRETE-BLACK INTEGRAL COLOR; 8084 GRAPHITE 150# PER 10 YARDS FOR A 5 SACK MIX (V.I.F.-MATCH EXISTING)
F4	QUARRY TILE IN 1" MUDSET, SLOPE TOWARDS DRAIN - 6"x6" AMERICAN OLEAN - FAWN GRAY, ABRASIVE QUARRY TILE FLOOR COLOR; "ABRASIVE GRAIN Q06" WITH TEC #925 SABLE GROUT (PROVIDE CONTROL JOINTS IN FLOOR AT ALL FLOOR SLAB JOINTS)
W3	BEVELED CEDAR SIDING-1X8 WESTERN RED CEDAR DENSITY, 12% MOISTURE SPREAD RATING 69 (CLASS 2), PROVIDE CORROSION RESISTANT NAILS (V.I.F.-MATCH EXISTING)
W4	GYPSUM BOARD-PAINTED (V.I.F.-MATCH EXISTING)
W5	PORCELAIN WALL TILE; AMERICAN OLEAN - KENDAL SLIP COLOR "CARBON BLACK", SIZE 12" X 12" WITH GROUT COLOR: TEC 925 SABLE. INSTALL CONCRETE BOARD 1/2" UP FROM FLOOR, THEN WATER RESISTANT GYPSUM BOARD TO 96" (OR APPLICABLE HEIGHT)

### ASSISTED RESTROOM PLUMBING FIXTURE SCHEDULE


TYPE MARK	DESCRIPTION	MANUFACTURER	MODEL	Count
P1	FLOOR MOUNT WC WITH WALL MOUNT FLUSH CONTROL	SEE P1.0	SEE P1.0	1
P3	WALL HUNG LAVATORY	SEE P1.0	SEE P1.0	1
P4	LAVATORY FAUCET	SEE P1.0	SEE P1.0	1

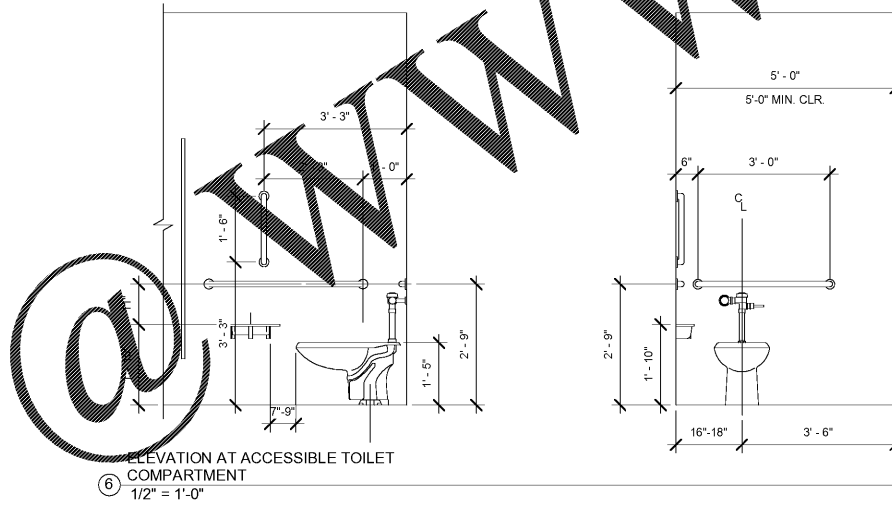


6 ELEVATION AT ACCESSIBLE TOILET COMPARTMENT  
1/2" = 1'-0"

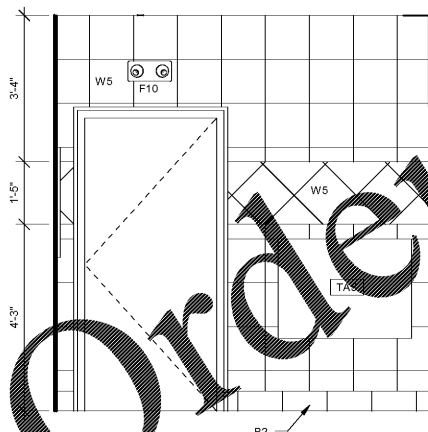


2 RESTROOM ELEVATION 1  
1/2" = 1'-0"

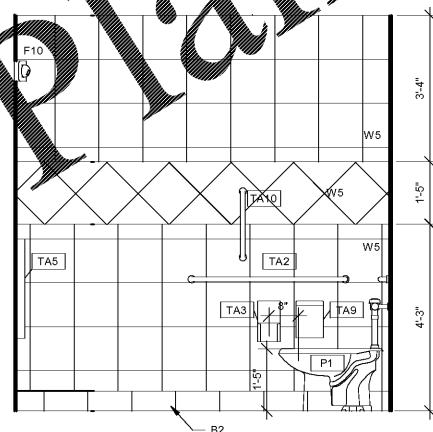

3 RESTROOM ELEVATION 2  
1/2" = 1'-0"

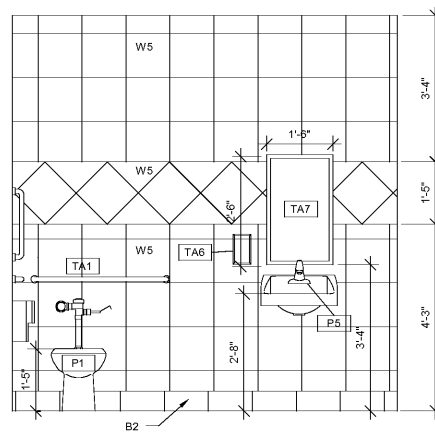

4 RESTROOM ELEVATION 3  
1/2" = 1'-0"

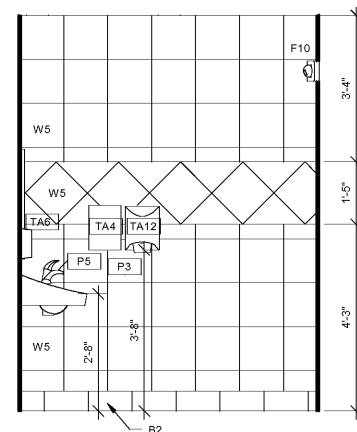

5 RESTROOM ELEVATION 4  
1/2" = 1'-0"

Design +  
INC.  
Bardonia Eastern Building  
1449 Bardonia Rd., Suite 200  
Louisville, KY 40204  
(502) 454-0011

TEXAS *wood house*  
1570 W. KOGER CENTER  
DRIVE RICHMOND, VA 23235

PERMIT SET

DRAWN BY	LAJ
CHECKED BY	KRB
DATE	6/22/2017
REV. DATE	DESCRIPTION

The Construction Documents shall consist of all drawings, specifications, surveys, soils reports, addenda and other information. Plans of this information or drawing sheets shall be taken separately or "stamped" from the remainder of the Construction Documents. The Architect shall be responsible to determine their particular scope of work. Any documents or information submitted to the Architect shall be interpreted at the sole discretion of the Architect.

SHEET TITLE  
ENLARGED  
RESTROOM  
PLAN  
**A6.0**

QUALITY CONTROL CHECK: ADA EGRESS BLDG CODES SNOW GUARDS SLAB THICKNESS

Order Plans

WWW.LDLINE.COM

snideman ARCHITECTS