

consultant

**West Marine**  
 500 Westridge Drive  
 Watsonville, California 95076  
 p: 831.728.2700 f: 831.761.4220

ISLAND WALK @  
 PALM COAST  
 250 PALM COAST PKWY NE  
 PALM COAST, FL 32137  
 STORE #TBD

commission number 44-1047


WM 75% 07/07/2017

LL Final  
 Permit  
 Bidding


ROBERT F. VANNEY ARCHITECT

drawing title  
**ACCENT LIGHTING & DIMENSION PLAN**

sheet number  
**A303**

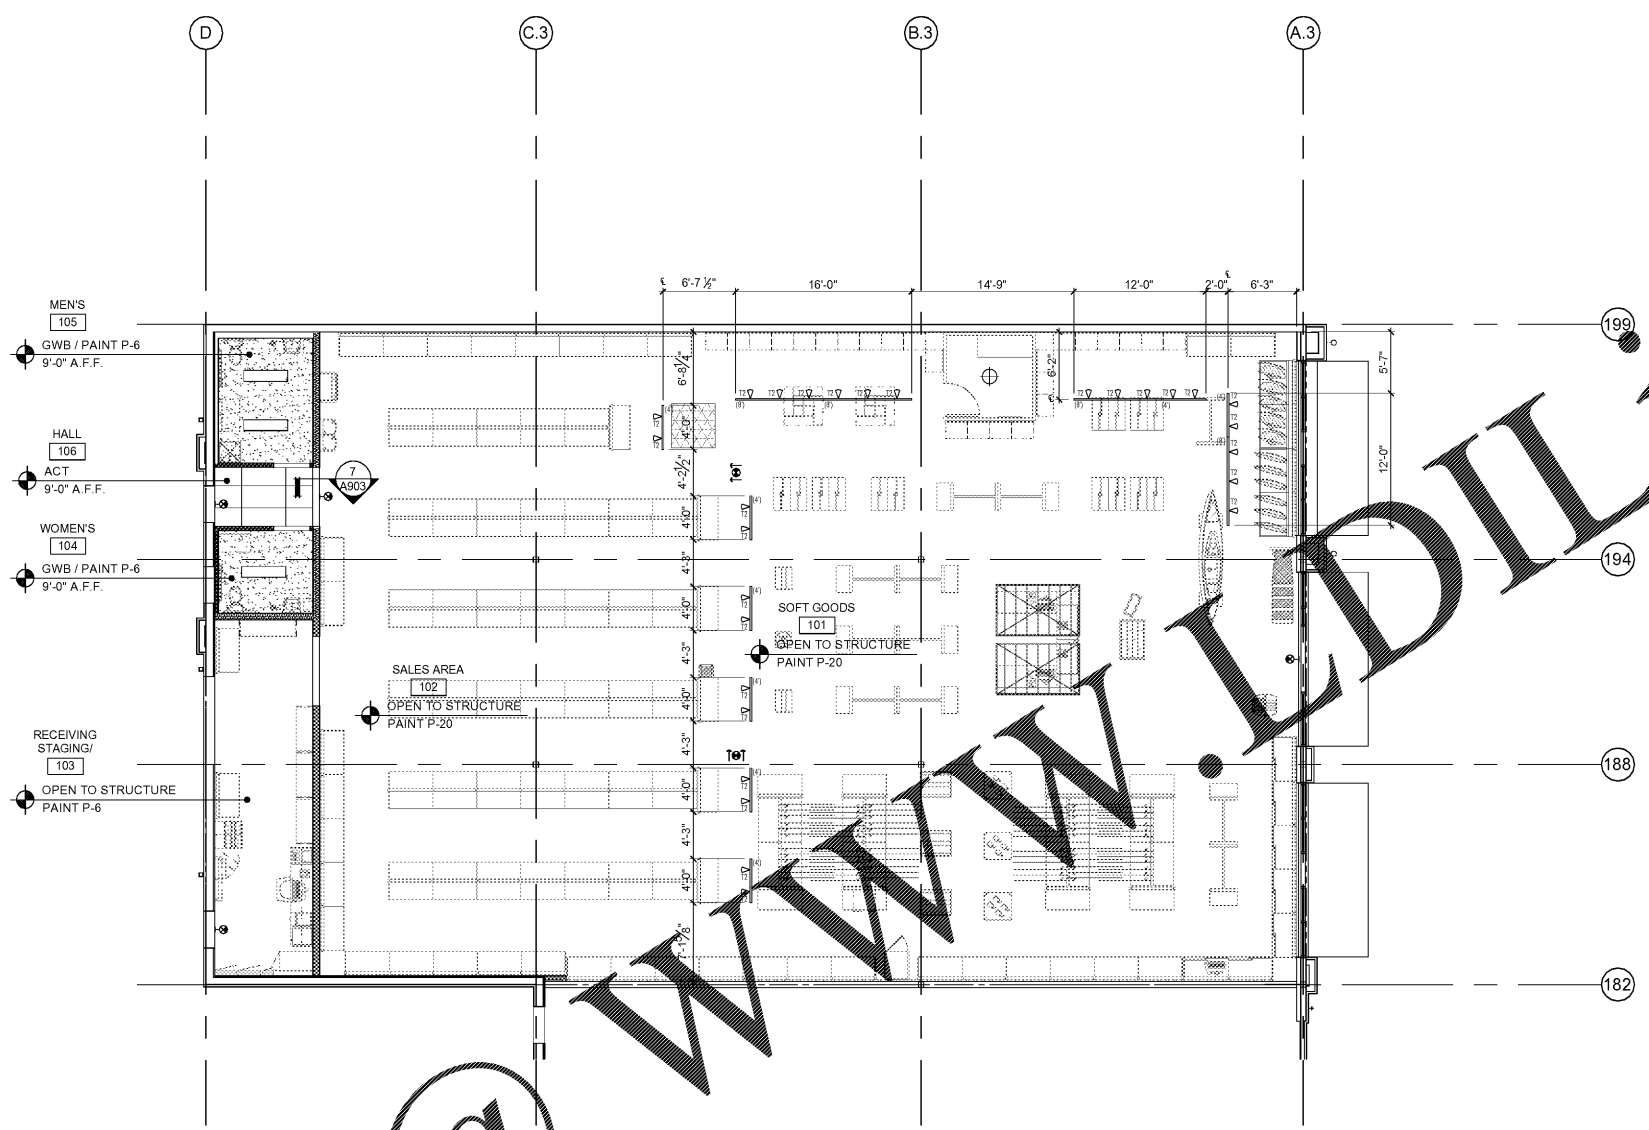

 1 REFLECTED CEILING PLAN - DIMENSIONED ACCENT LIGHTING  
 1/8" = 1'-0"



**LIGHTING LEGEND**

FIXTURE ID	DESCRIPTION	MANUFACTURER	MODEL NO.	MOUNTING	HEIGHT	LAMP
A4	4" WRAPAROUND LENS FLUORESCENT	PHILIPS (DAY-BRITE)	OWN232-UNV-1/2-EB	SUSPENDED	9'-0" A.F.F.	(2) 32W TB
T8	2' X 4' FLUORESCENT TROFFER PRISMATIC	LITHONIA	2GT8-2-32-A12-MVOLT GEB10IS-PWS1836-LP735	CEILING	9'-0" A.F.F.	(2) 32W TB
EL	EXIT LIGHT RED LETTERS ON WHITE BACKGROUND. COMBO EXIT LIGHT	PHILIPS (LIGHTOLIER)	LLC2URW SD	SURFACE	MOUNT PER REQUIREMENTS	(1) LED INCLUDED
EL	EXIT LIGHT RED LETTERS ON WHITE BACKGROUND. TWO SIDED	PHILIPS (LIGHTOLIER)	LNURW SD	PENDANT	MOUNT PER REQUIREMENTS	(1) LED INCLUDED
F1	4" FLUXSTREAM LED LINEAR WITH REFLECTOR	PHILIPS (DAY-BRITE)	LF4-4-FL-LWS-55-35-U-DZT	AIR CRAFT CABLE	13'-6" A.F.F.	(1) 53W LED
F1EM	4" FLUXSTREAM LED LINEAR WITH REFLECTOR	PHILIPS (DAY-BRITE)	LF4-4-FL-LWS-55-35-U-DZT-EMLED	AIR CRAFT CABLE	13'-6" A.F.F.	(1) 53W LED
F8	8" FLUORESCENT STRIP WITH SOLID TOP REFLECTOR	PHILIPS (DAY-BRITE)	TIS132-UNV-1/2-EBD	AIR CRAFT CABLE	13'-6" A.F.F.	(2) 32W T8
F8EM	8" FLUORESCENT STRIP WITH SOLID TOP REFLECTOR	PHILIPS (DAY-BRITE)	TIS132-UNV-1/2-EBD-E5	AIR CRAFT CABLE	13'-6" A.F.F.	(2) 32W T8
P2	DEEP BOWL LED PENDANT LIGHT	LSI INDUSTRIES	BD300-10-LED-CUSTOM COLOR	PENDANT	7'-6" A.F.F.	(1) 11W LED
P3	LED PENDANT LIGHT	BASELITE	W516(INC/49/GR16/BLC(15"	PENDANT	7'-6" A.F.F.	(1) 16W GE LED16A212/827
TV	25W LED TRACK LIGHT	PHILIPS(LIGHTOLIER)	LC20930ALTE-LLAV11RNS	TRACK-MOUNTED 15'-4" A.F.F. TO TOP OF TRACK	13'-6" A.F.F.	(1) LED INCLUDED
U1	UNDER SHELF LED LINEAR, HERA SLIM/LITE XL ES34 (F.O.I.O.) -CONCEAL CORD				B.O. SHELF	

**LIGHTING NOTES**

- THE WEST MARINE LIGHT PACKAGE WILL BE SUPPLIED ACCORDING TO THE RESPONSIBILITY SCHEDULE. MINIMUM LEAD TIME FOR ORDERING IS THREE (3) WEEKS. CONTRACTOR MUST INSPECT SHIPMENT UPON ARRIVAL FOR DAMAGE. IF THERE IS DAMAGE, A DAMAGE REPORT MUST BE FILLED OUT WITH THE TRUCKING COMPANY AT THE TIME OF DELIVERY.
- ALL LIGHTING CIRCUITS TO BE ON CONTRACTORS WITH THREE (3) SWITCHES AT THE FRONT DOOR. CONTRACTORS TO OVERRIDE ALL SWITCHES IN ROOMS.
- PROVIDE FOUR (4) CIRCUITS FOR 2-CHANNEL LETTER SETS TO BE CONTROLLED BY TIME CLOCK (VERIFY LOCATION WITH SIGN CONTRACTOR). CHANNEL LETTER SETS ARE TO BE ON THE SAME TIME CLOCK.
- LIGHTING FIXTURES SHALL BE INSTALLED COMPLETE WITH LAMPS, BALLASTS AND ALL NECESSARY MOUNTING ACCESSORIES INCLUDING STRAIGHTENING CLIPS. ALL AIRCRAFT CABLE AND UNISTRUT TO BE PROVIDED BY G.C.
- HVAC SUPPLY AND RETURN DUCTS AND REGISTERS SHALL NOT BE BELOW LIGHT LINE AT 13'-6" A.F.F.
- LIGHTING FIXTURE HEIGHTS (U.O.N.):
  - B.O. AMBIENT LIGHT FIXTURES @ 13'-6" A.F.F.
  - B.O. TRACK LIGHT FIXTURES @ 13'-6" A.F.F.
  - B.O. "P3" LIGHT FIXTURES @ 7'-6" A.F.F.
  - B.O. BACK OF HOUSE LIGHT FIXTURES @ 13'-6" A.F.F.
- REFERENCE ELECTRICAL DRAWINGS FOR LIGHT FIXTURES WITH EMERGENCY BATTERY FOR EGRESS PATH LIGHTING.
- TRACK LIGHTS AT HANGING TRELIS TO BE INSTALLED AFTER TRELIS INSTALLATION. INSTALL TRACK PER DETAIL 6/A902.
- COORDINATE LOCATION OF NEW AND EXISTING SPRINKLER HEADS WITH FIRE SPRINKLER CONTRACTOR. RELOCATE HEADS AROUND LIGHT FIXTURES AS NECESSARY.

Order Plans

@

WWW.LDLine.com