



**HOMWOOD PATRICK PARK POOL**



HOMWOOD PARKS AND RECREATION;  
HOMWOOD, AL



OWNER  
HOMWOOD PARKS AND RECREATION  
1632 OAKWOOD ROAD  
HOMWOOD, AL 35209  
205-322-6704  
ATTN: BERKLEY SQUIRES

ARCHITECT  
DAVIS ARCHITECTS, INC.  
126 23RD STREET SOUTH  
BRIMMINGHAM, AL 35233  
205-322-7482  
ATTN: JIM HARTSELL

LANDSCAPE ARCHITECT  
HNP  
1914 28TH AVE. S.  
BRIMMINGHAM, AL 35209  
205-324-4447

CONSTRUCTION MANAGER  
BL HARRERT  
820 SHADES CREEK PARKWAY, SUITE 3000  
BRIMMINGHAM, AL 35209  
205-892-2300  
ATTN: JOHN HANSON

STRUCTURAL ENGINEER  
LEYD INC.  
716 SOUTH 30TH STREET  
BRIMMINGHAM, AL 35233  
205-251-4500  
ATTN: WIM BISHOP / BRAD CHRISTOPHER

MECHANICAL ENGINEER  
WHITAKER & RAWSON  
3322 OLD MONTGOMERY HIGHWAY  
SUITE 101  
BRIMMINGHAM, AL 35209  
205-870-8801  
ATTN: DAN WHITAKER, ERIC HARTWIG, AND MARK D'ANDREA

CIVIL ENGINEER  
LEYD INC.  
716 SOUTH 30TH STREET  
BRIMMINGHAM, AL 35233  
205-251-4500  
ATTN: CURTIS EATMAN AND BRAIN HATCHER

ELECTRICAL ENGINEER  
FISHER ARNOLD  
1507 ALEX DR.  
SUITE 101  
BRIMMINGHAM, AL 35210  
205-833-7033  
ATTN: JOSEPH KUMU AND NICHOLAS BROWN

PLUMBING / FIRE PROTECTION ENGINEER  
EDMONDS ENGINEERING  
2 RIVERCHASE OFFICE PLAZA  
SUITE 206  
BRIMMINGHAM, AL 35244  
205-988-2069  
ATTN: CAROL JOHNSON

POOL CONSULTANT  
COUNSILMAN HUNSAKE  
10733 SUNSET OFFICE DRIVE  
SUITE 400  
ST. LOUIS, MO 63127  
314-894-1245  
ATTN: JEFF NODORFT

REV DATE DESCRIPTION

DATE: OCTOBER 6, 2017

PROJECT: 100% CONSTRUCTION DOCUMENTS


DESIGNED BY: DAVIS ARCHITECTS PROJECT NO: 3822

SHEET TITLE: PARTIAL FLOOR PLAN - LIGHTING

DRAWING NO: E2.01



- GENERAL NOTES**
- COORDINATE LOCATION OF LIGHT FIXTURES WITH CEILING SPEAKERS, MECHANICAL DUCTWORK, PLUMBING WITH ARCHITECTURAL ROPS BEFORE ROLL UP.
  - ALL LIGHTING CIRCUITS SHALL BE HOMERUN TO PANELBOARD RPL-P LOCATED IN ELEC. 015 UNLESS NOTED OTHERWISE.
  - ALL CONDUITS TO POOL DECK ARE ROUTED UNDER DECK UNLESS NOTED OTHERWISE.
- NOTES**
- HOMERUN TO 20A-1F PANEL CIRCUIT BREAKER (PANEL BOARD RPL-POOL THROUGH LIGHTING CONTACTOR C-P. SEE LIGHTING CONTACTOR PLAN SHEET ED-07)

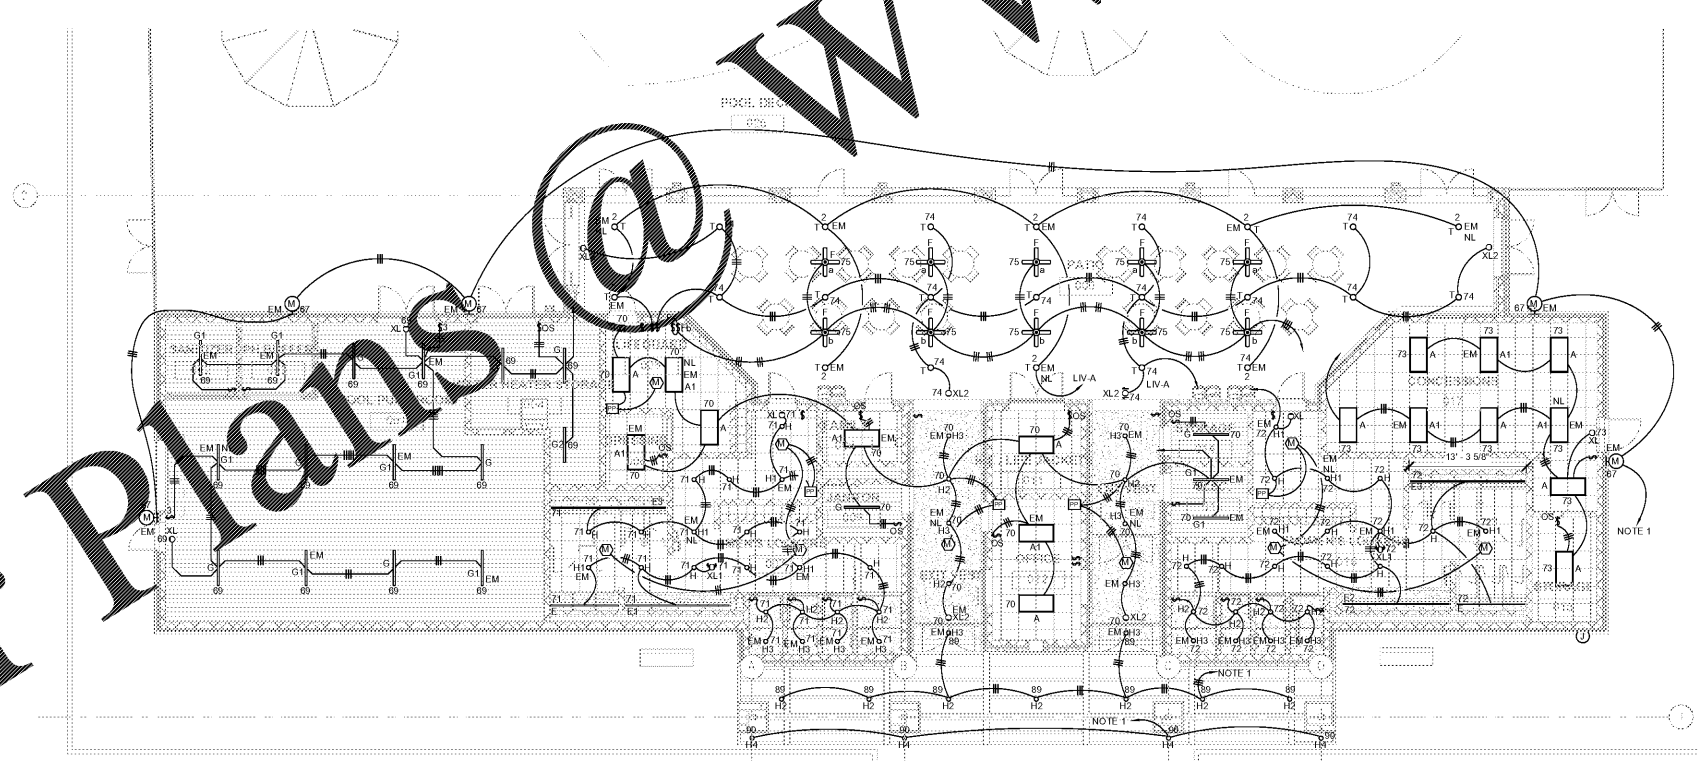

Order Plans @ [www.LDLine.com](http://www.LDLine.com)

1 PARTIAL FLOOR PLAN - LIGHTING  
SCALE: 1/8" = 1'-0"

E2.01