


FFPA AIR STUDIO
JEFF PAUL
1100 BELL AVE SUITE H1
BAYON ROUGE, LA 70009



Reflected Ceiling Plan Legend

-
-
- Note:
1. If dimension for light is not given center light in room.
 2. Recessed can lights in waiting area to be aligned with pendant lights if no dimension is given.
 3. Vertical dimensions for lights above finish floor are to the bottom of the light fixture.
 4. Exterior sconce lights to be centered on wall between windows and evenly spaced.

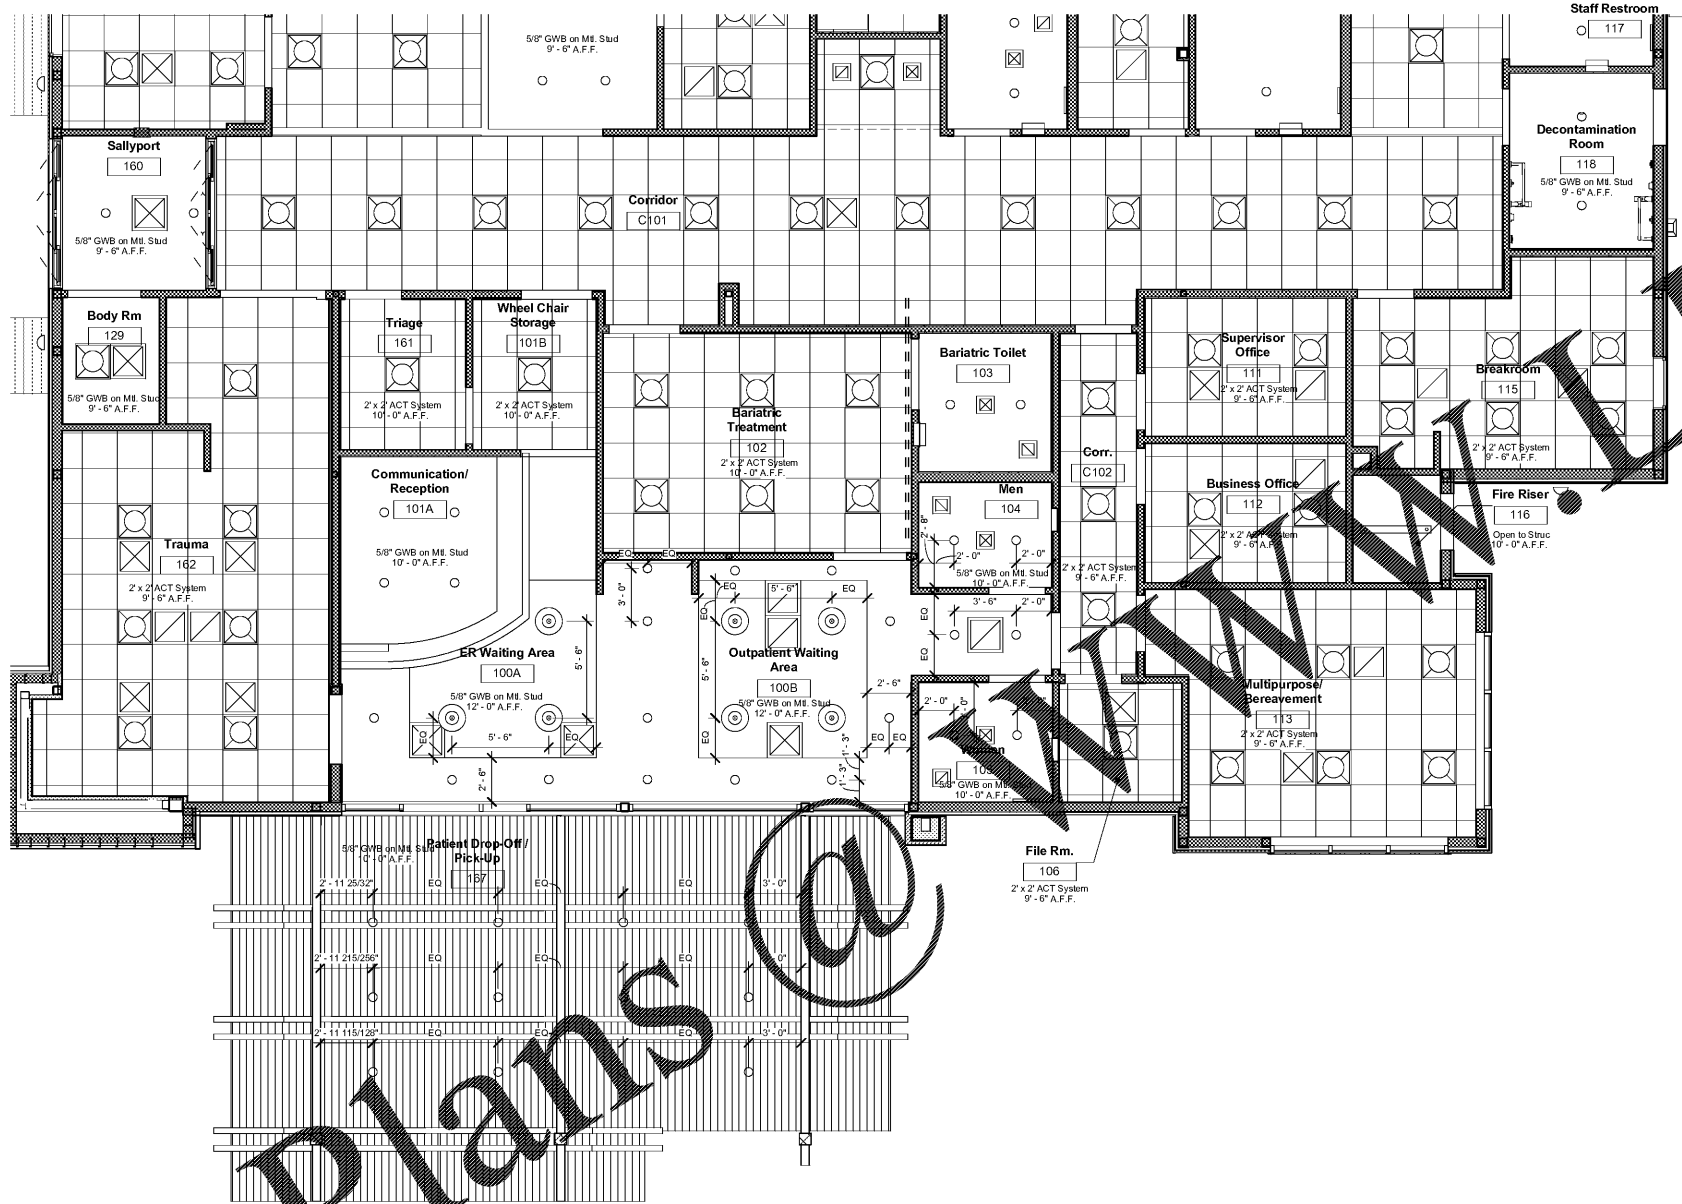

1. Enlarged Reflected Ceiling Plan - Area 'C'
SCALE: 1/8" = 1'-0"

Prairieville General Hospital
37358 Market Place Dr.
Prairieville, LA 70769

Shawn Kesteron and Associates
Robert C. Murray, AIA
Architecture & Construction Services
13430 Brandeis Rd., Suite 202
Metairie, LA 70001
Tel: 214.945.5116
Fax: 504.885.8888
Email: SCA@shawncor.com



Project No. 1607050
Drawn: KRF
Checked: AN
Date: 11.22.17

No.	Description	Date

A304
Enlarged RCP -
Area 'C'

Order Plans @