

STATE OF LOUISIANA
 OFFICE OF MECHANICAL CONTRACTORS
 LICENSE NO. 11/22/17

IMEG
 15716 RESEARCH BLVD
 SUITE 305
 WATSON, TX 75792
 TEL: 817-516-1545
 FAX: 817-516-1547
 WWW.IMEGPROJECTS.COM

Prairville General Hospital
 37358 Market Place Dr.
 Prairieville, LA 70769


Shawn Keaton and Associates
 Robert C. Murray, AIA
 Architectural & Construction Services
 13438 Souders Ln., Ste. 202
 Baton Rouge, LA 70813
 Ph: 225-985-5716
 Fax: 225-985-5714
 Email: shawn@shawnkeaton.com

CONSTRUCTION REISSUE SET

Skaf
 Inc.

Project No.	1607050	
Drawn:	TB	
Checked:	-	
Date:	November 22, 2017	
No.	Description	Date

EP103
 ELECTRICAL
 HVAC PLAN

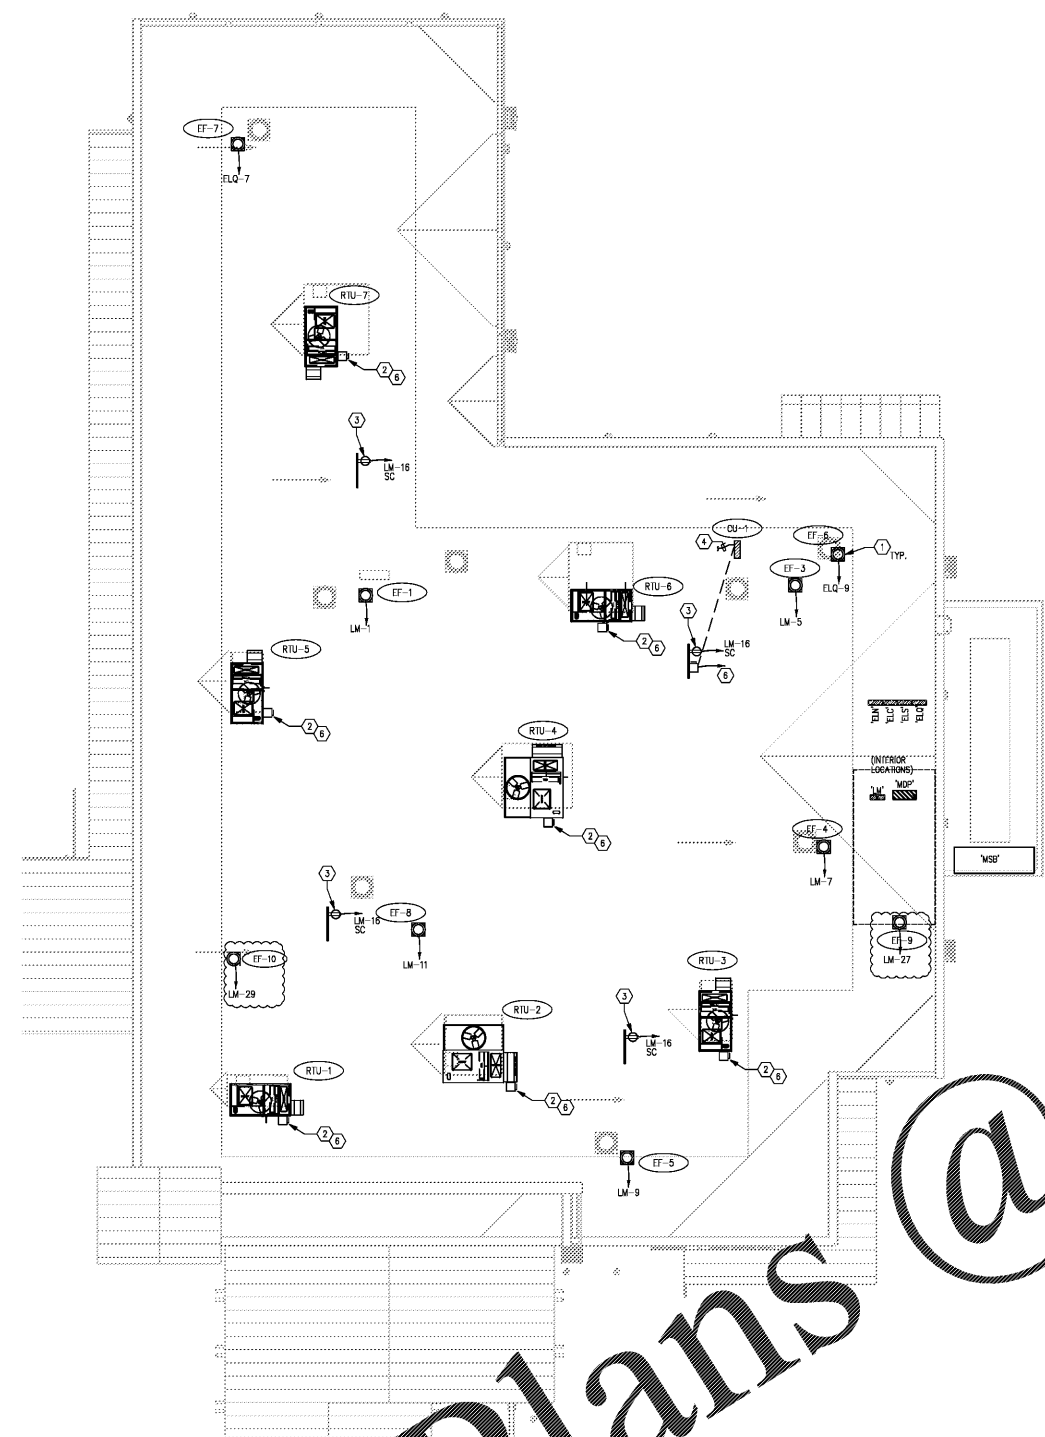

2 ELECTRICAL ROOF PLAN
 SCALE: 1/8" = 1'-0"

- KEYED NOTES:**
- EXHAUST FAN IS EQUIPPED WITH AN INTEGRAL DISCONNECT SWITCH.
 - MOUNT DISCONNECT SWITCH ON HVAC UNIT. REFER TO ELECTRICAL RISER PLAN, SHEET E31, FOR DISCONNECT AND WIRE SIZES.
 - CONVENIENCE RECEPTACLE IN RACK, GFCI WITH WEATHERPROOF WIRE AND GROUND COVER.
 - ROUTE WIRING FROM CONDENSING UNIT TO 1/2" DIA. RIGID BLDG. SERVICE 3/4" COND. RUNWAY FOR WIRING. COORDINATE WITH MECHANICAL.
 - INSTALL POINT SMOKE DETECTOR IN SUPPLY AND RETURN AIRWAYS. DETECTOR SHALL CAUSE SHUTDOWN OF HVAC. ALSO CAUSE FIRE ALARM SYSTEM TO GO INTO ALARM. COORDINATE WITH MEDICAL SCHEDULE. INSURE CONTRACTOR IN THE INTERESTS OF THE HOSPITAL.
 - MECHANICAL EQUIPMENT CONNECTION TO ELECTRICAL CIRCUIT #.
 - PROVIDE UPS/20M/7P/N1 250V RATED DISCONNECT SWITCH.
 - PROVIDE JODGE SWITCH DISCONNECT ON CONTROL VALVE. COORDINATE WITH MEDICAL.
 - PROVIDE SWITCHED J-BOX FOR EACH FIRE SMOKE DAMPER. COORDINATE WITH MEDICAL.



1 ELECTRICAL HVAC PLAN - INTERIOR
 SCALE: 1/8" = 1'-0"

Order Plans @

WWW.ONLINE.COM