

FFPAIR STUDIO
 OFFICE: 1600 BOBBELL AVENUE, SUITE H1
 BAYON ROUGE, LA 70009
 PHONE: 504.835.7400
 FAX: 504.835.7400
 WWW.FFPASTUDIO.COM

IMEG
 15715 RESEARCH BLVD
 SUITE 305
 AUSTIN, TX 78759
 PHONE: 512.416.1847
 FAX: 512.416.1847
 WWW.IMEG.COM

Prairville General Hospital
 37358 Market Place Dr.
 Prairieville, LA 70769

Shawn Kesteven and Associates
 Robert C. Murray, AIA
 Architects & Construction Services
 13408 Inwood Rd., Ste. 202
 Houston, TX 77040
 PH: 281.965.5716
 FX: 281.965.5714
 Email: shawn@shawnkesteven.com

CONSTRUCTION REISSUE SET

Project No. 1607050


Drawn: AG

Checked: -

Date: November 22, 2017

No.	Description	Date

P102
 PLUMBING UNDERFLOOR

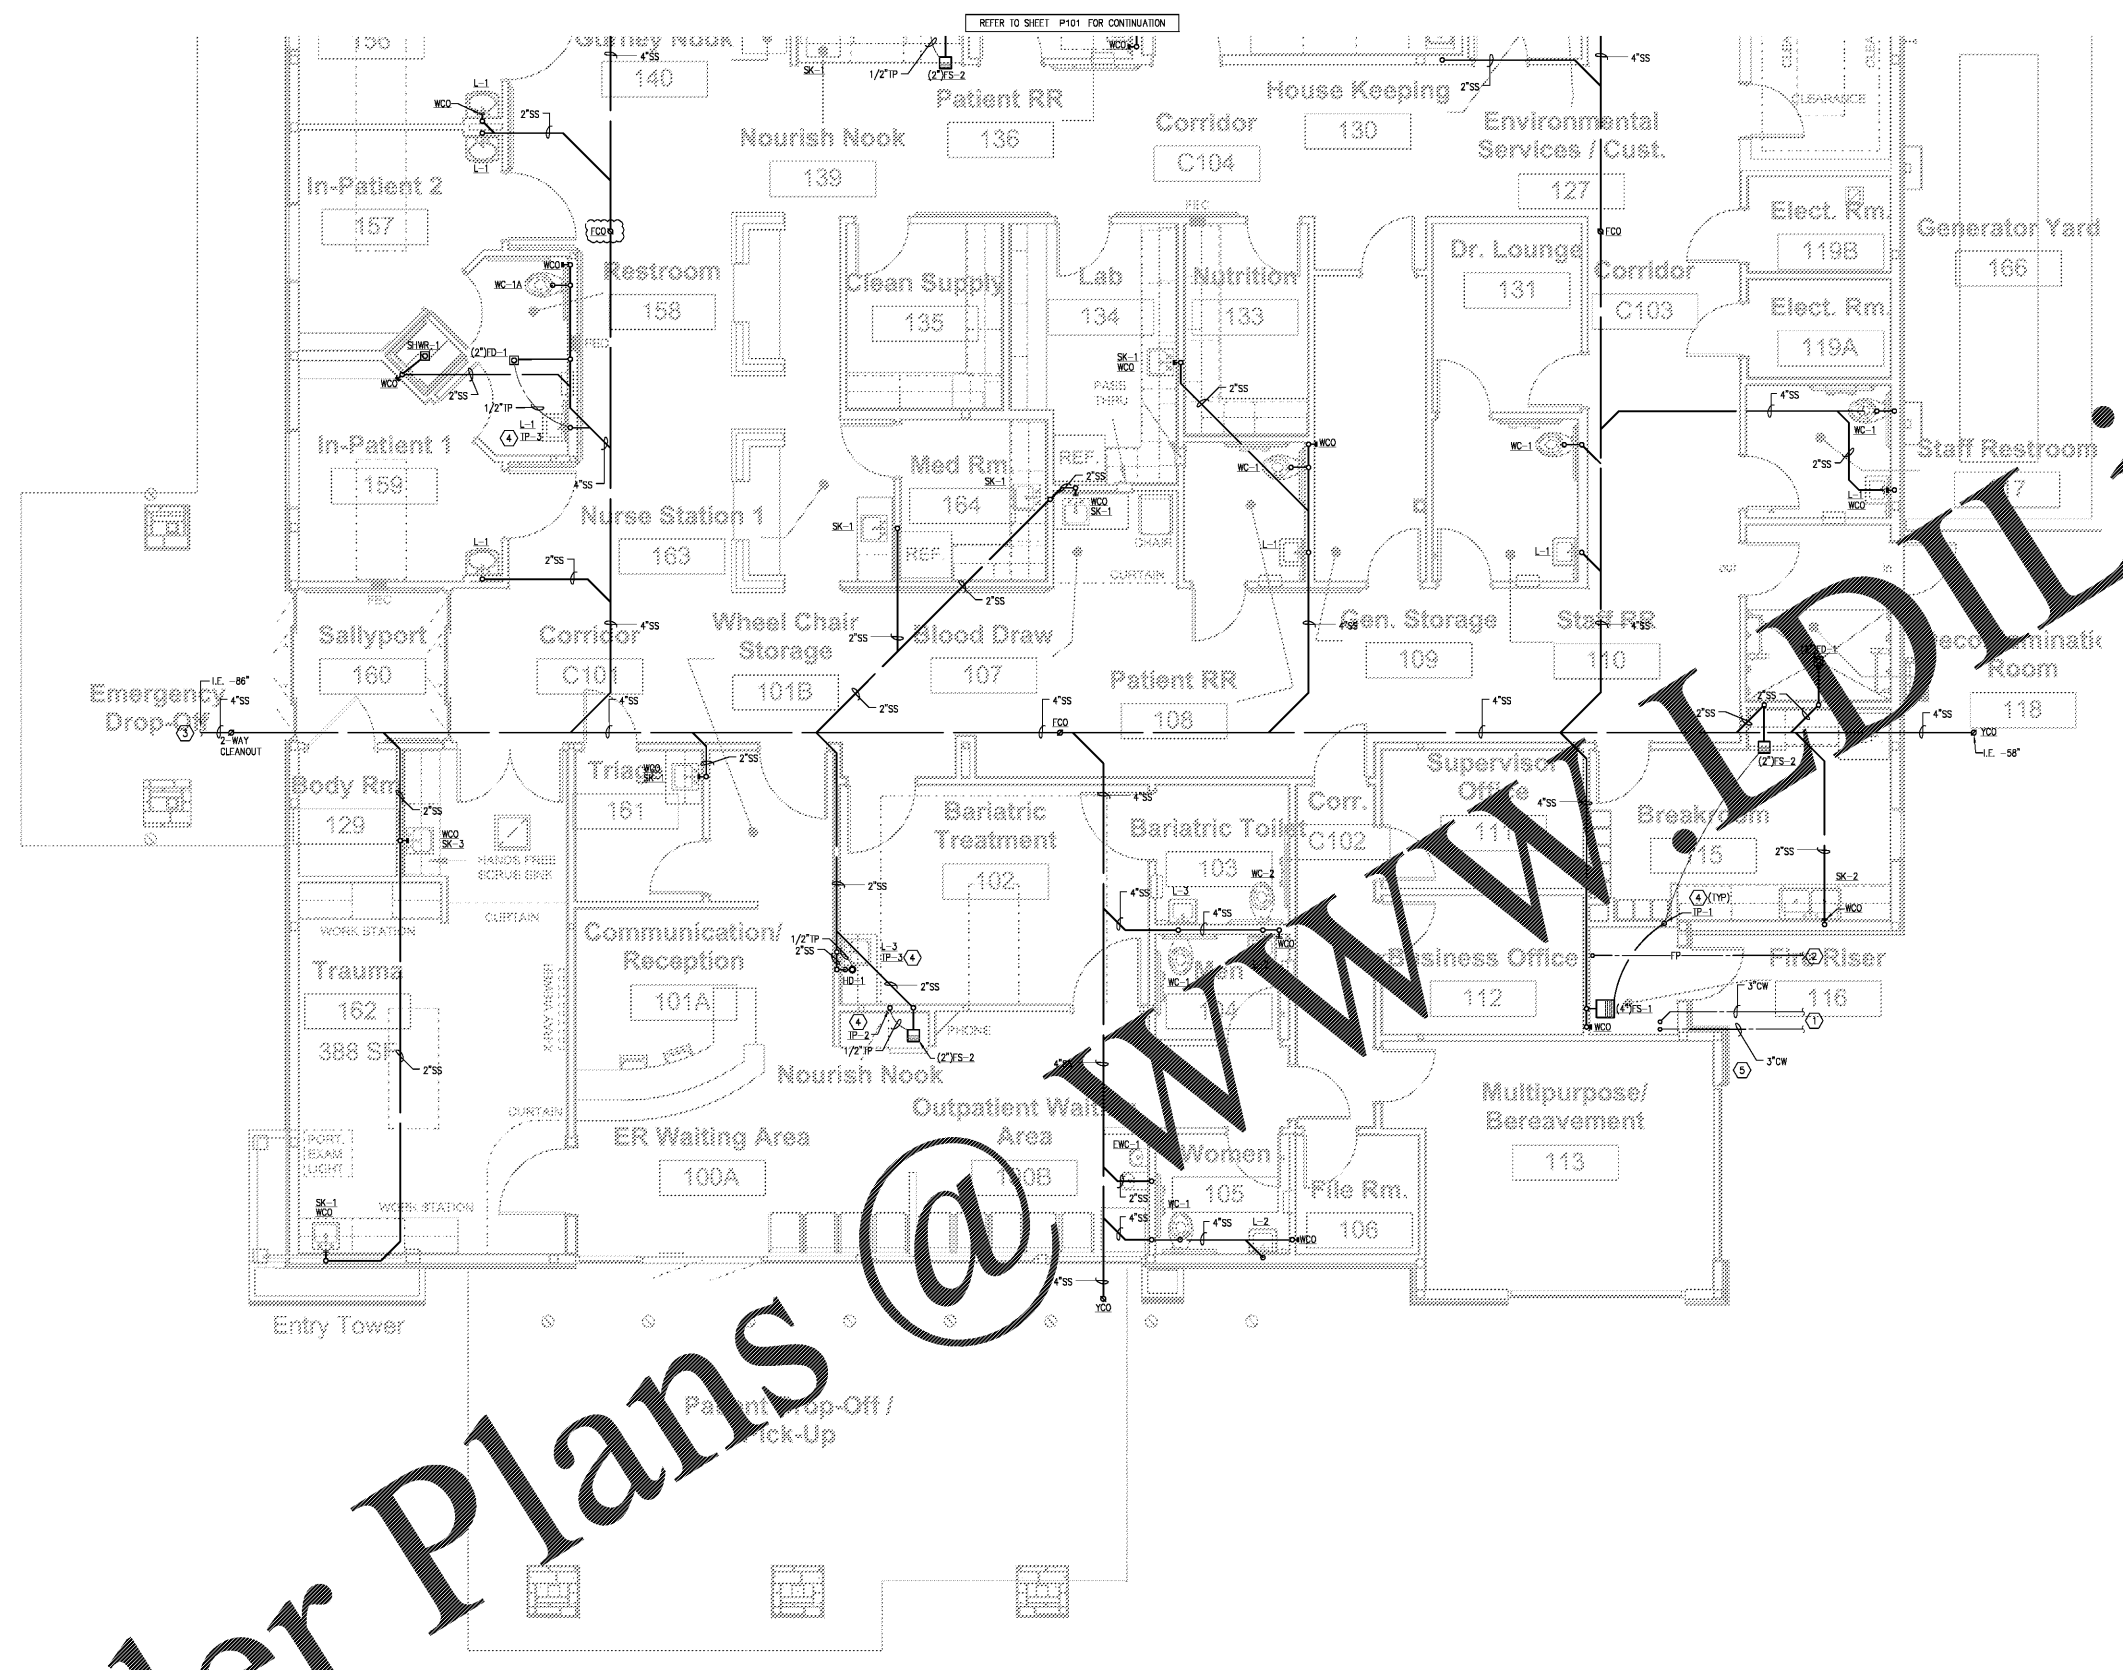

1 PLUMBING - UNDERFLOOR PLAN
 SCALE: 1/4" = 1'-0"

Order Plans @

WWW.DLINE.COM