




FFPA ARCHITECTURE STUDIO
JEFF PAUR ARCHITECTURE STUDIO
1630 BOBBEL AVENUE, SUITE H1
BATON ROUGE, LOUISIANA 70809
504.740.7406

GENERAL NOTES - PLUMBING:

1. MAINTAIN A MINIMUM DISTANCE OF 10' FROM VENT THROUGH ROOF OPENINGS TO INTAKE OPENINGS AND BUILDING OPENINGS. MAINTAIN A MINIMUM DISTANCE OF 25' FROM VENT THROUGH ROOF OPENINGS TO AIR INTAKE OPENINGS FOR MECHANICAL EQUIPMENT SERVING CRITICAL CARE AREAS.

 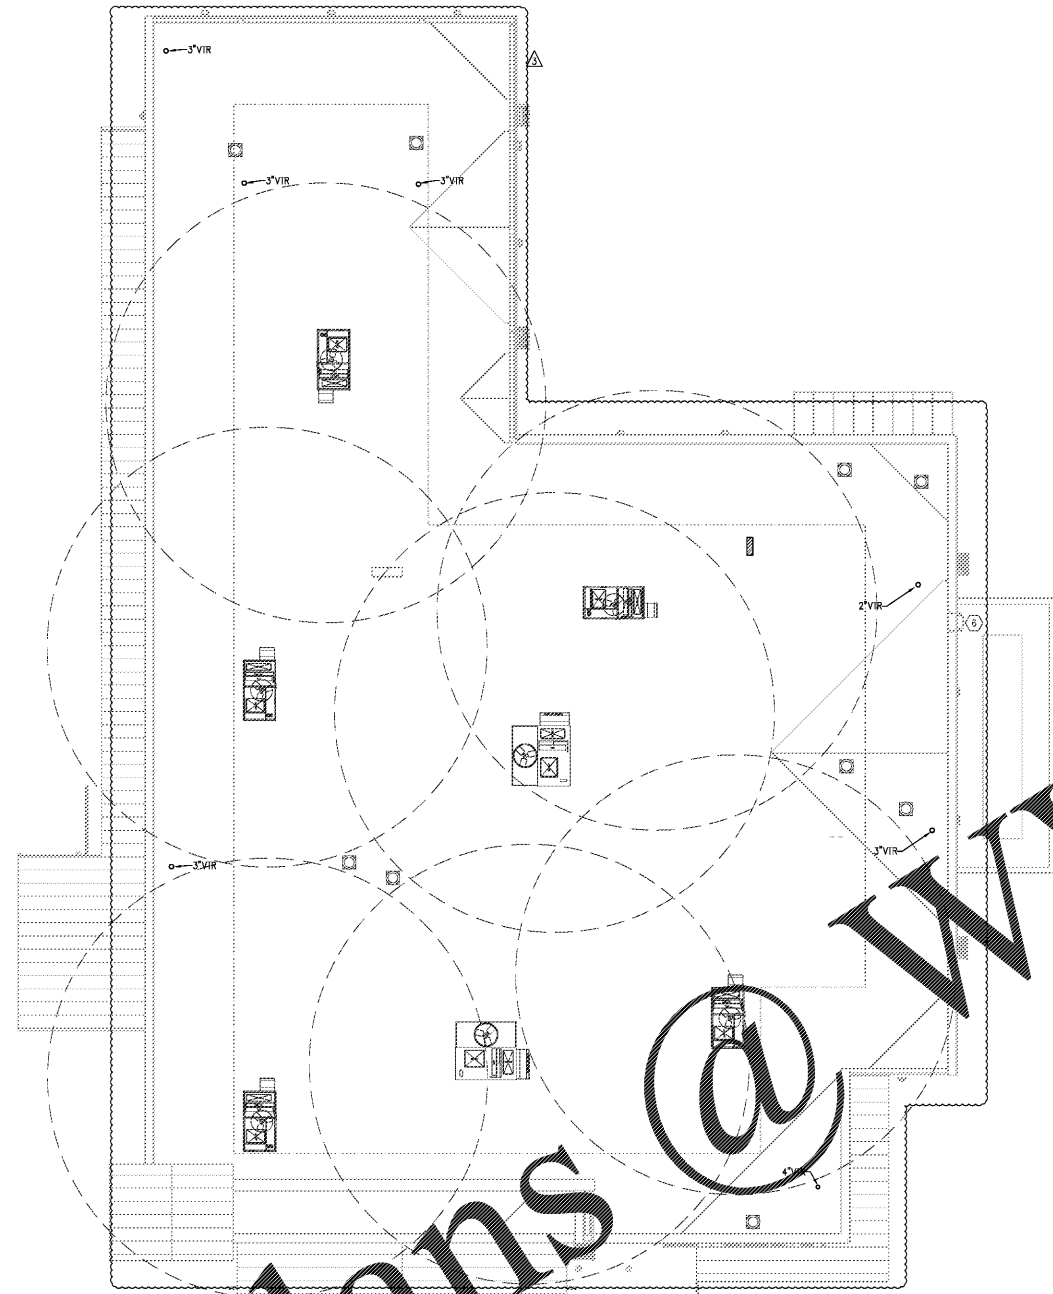


1 PLUMBING - ROOF PLAN
SCALE: 1/8" = 1'-0"

IMEG
12101 RESEARCH BLVD
SUITE 200
AUSTIN, TX 78758
PH: 512.416.1862
FAX: 512.416.1847
www.imeg.com
IMEG PROJECT # 02161306

Prairville General Hospital
37358 Market Place Dr.
Prairieville, LA 70769

Shawn Kesteven and Associates
Robert C. Murray, AIA
Architecture & Construction Services
13438 Bandiera Rd., Ste. 202
Houston, TX 77040
PH: 281.696.5716
FAX: 281.696.5714
Email: shawn@shawnke.com



Project No. 1607050

Drawn: AG

Checked: -

Date: November 22, 2017

No.	Description	Date

CONSTRUCTION REISSUE SET

P107
PLUMBING
ROOF PLAN

Order Plans @

WWW.LDILine.COM