



02 SOFFIT DETAIL @ SERVING COUNTER
A3.1 SCALE: 1-1/2" = 1'-0"

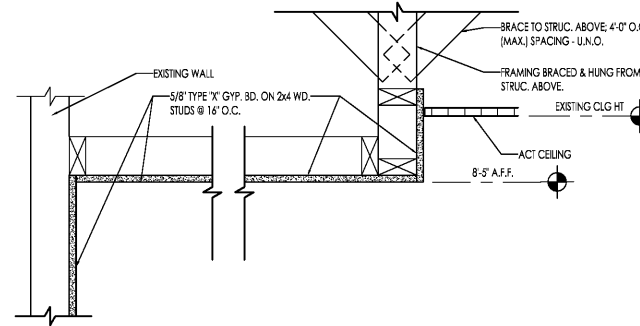

01 SOFFIT DETAIL
A3.1 SCALE: 1-1/2" = 1'-0"

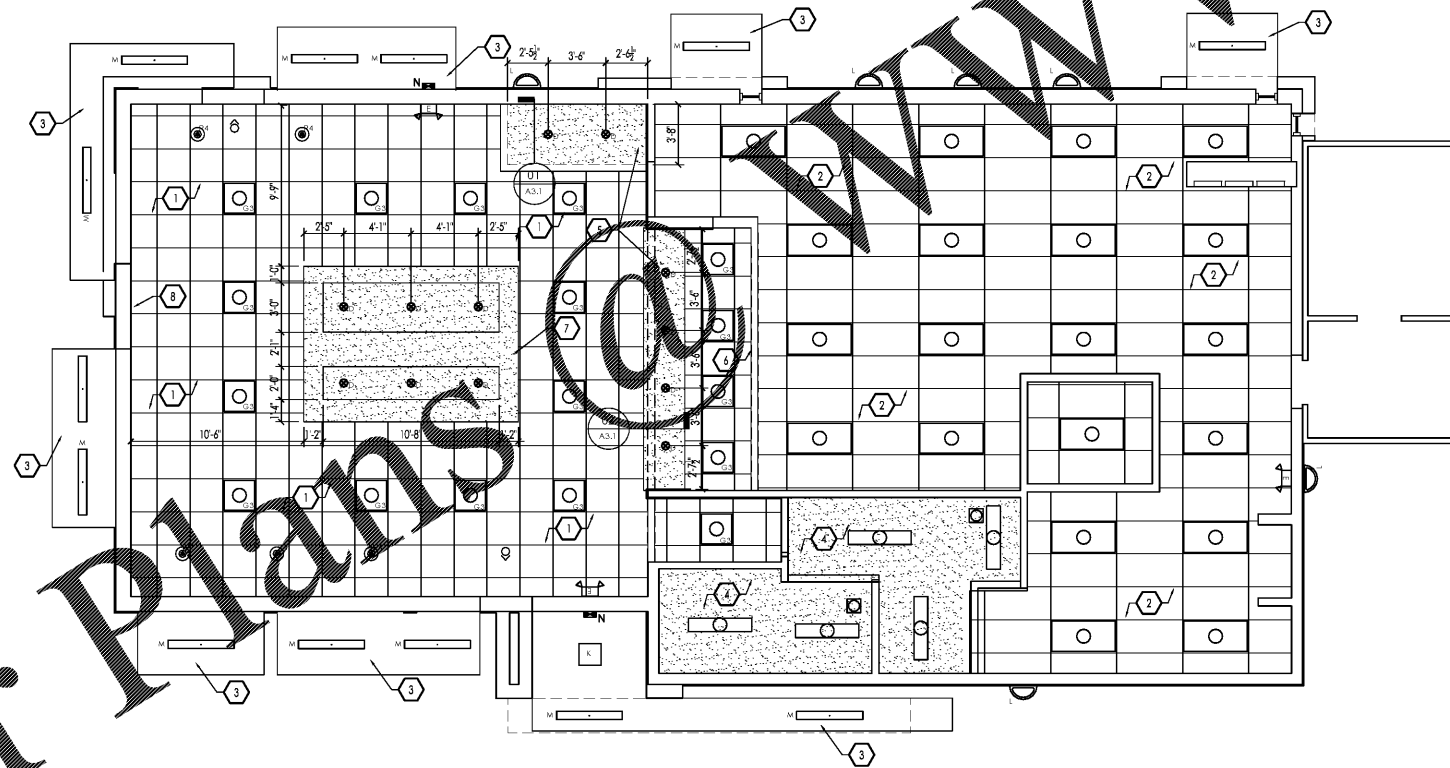

REFLECTED CEILING PLAN
SCALE: 3/16" = 1'-0"

RCP GENERAL NOTES:

- ALL DIMENSIONS SHOWN ON REFLECTED CEILING PLAN ARE FROM FACE OF WALL FINISH UNLESS NOTED OTHERWISE.
- INDICATED HEIGHTS ON PLAN ARE FROM ABOVE FINISH FLOOR (A.F.F.).
- G.C. TO COORD. LIGHTING W/ INTERIOR DECOR (ID) DRAWINGS.
- CONTRACTOR SHALL VERIFY FIXTURE QUANTITIES AND MAKE PROPER ADJUSTMENTS FOR ANY CHANGES IN PLAN DUE TO ADDITIONAL REQUIREMENTS, LOCAL CODES, ETC.
- G.C. TO REPLACE ALL EXISTING LIGHTING AS NOTED WITH FIXTURES FROM ENERGYWISE. CONTACT: JENNIFER WADDICK - 225-276-0021 - JENNIFER@ENERGYWISEMAIL.COM. COORDINATE FINAL FIXTURE LOCATION AND TYPE WITH OWNER AND LIGHTING VENDOR PRIOR TO INSTALL.
- ALL FIXTURES SHALL BE LOCATED IN CENTER OF CEILING TILES UNLESS OTHERWISE NOTED. FIXTURES SHALL BE RE-PLACED APPROX. @ LOCATIONS OF EXIST. LIGHTS.
- FOR FINISH SPECIFICATIONS SEE FINISH SCHEDULE ON ID SHEETS.
- CONTRACTOR TO RE-INSTALL ALL EXISTING CEILING-MOUNTED ITEMS (I.E. EXIT SIGN, SPEAKER, ETC.) AS REQ'D.
- REPAIR & REPLACE EXIST. EXIT SIGNAGE & LIGHTING AS REQUIRED. VERIFY CONDITIONS.
- REPAIR & REPLACE EXIST. SPEAKER GRILLS AS REQ'D FOR "LIKE NEW" FINISH.
- G.C. TO PROVIDE ALL ELECTRICAL ENGINEERING AS DESIGN-BUILD AND TO VERIFY LOADS AND CIRCUITS. COORD. ADDED OUTLETS WITH THESE PLANS AND DECOR VENDOR.
- G.C. TO PROVIDE ELECTRICAL OUTLETS AS SHOWN (SCID) @ 18" FROM FLOOR UNLESS OTHERWISE NOTED.

RCP KEY NOTES:

- EXISTING ACT CEILING SHALL BE REMOVED & REPELACED; GRID TO REMAIN. REPAIR DAMAGED GRID AND REPAIR MATCH. CEILING NEW TILES TO BE: ARMSTRONG FINE FISSURED; COLOR: ADOBE/REIN. ALL DIFFUSERS, LIGHT FIXTURE, ETC...
- REMOVE & REPLACE EXISTING GYP. BD. TILES & GRID @ KITCHEN / BACK OF HOUSE W/ NEW VINYL-COR. ACOUSTICAL CEILING TILES & GRID. REMOVE & REPLACE HVAC SUPPLY & RETURN GRILLS. REMOVE AND REPAIR ALL LIGHT-FIXTURES AS REQ'D.
- PROVIDE NEW COPY ART WALL SCONCE LIGHTS; USE REMOVED MANSARD SOFFIT CIRCUIT FOR NEW LIGHTING; G.C. TO PROVIDE ALL ELECTRICAL DESIGN-BUILD AND TO VERIFY ALL LOADS AND CIRCUITS.
- REMOVE & REPLACE GYP. CEILING AT RESTROOMS AND PAINT CEILING WHITE. GYP. ON 2X FRAMING @ 16" O.C. - PROVIDE NEW MECHANICAL SUPPLY/RETURN GRILLS. PROVIDE NEW SPRINKLER ESCAPE CHRON COVER PLATES, ACCESS PANELS, ETC. AS REQ'D.
- NEW BULKHEAD. SEE DETAIL 1/A3.1.
- MENU BULKHEAD - PAINT AS SPECIFIED AT ID DRAWINGS. PROVIDE STAINLESS STEEL (SS) END-CAP AT BASE OF BULKHEAD, AND AT WALL-ENDS INTERSECTING BULKHEAD. COORDINATE W/ DETAIL 2/A1.1.
- NEW INTERIOR DECOR CEILING TRAY - SEE ID SHEETS.
- PROVIDE POWER AND CABLE CONNECTION FOR NEW TV LOCATION.

RCP LEGEND:

	TYPE M - ENERGYWISE - WET LISTED 4' LED CANOPY FIXTURE
	TYPE L - ENERGYWISE - SURFACE MOUNT EXT. WALL SCONCE - COLOR TO MATCH ALUM. STOREFRONT FRAMES
	TYPE N - ENERGYWISE - LED WALL PAK
	TYPE SC-1L - WALL SCONCE - COORD. W/ DECOR VENDOR
	TYPE D - ENERGYWISE LED RECESSED DOWNLIGHT FIXTURE - COORD. W/ DECOR AND OWNER
	TYPE P4 - ENERGYWISE LED A19 BULB (IN PENDANT FIXTURE AS SPECIFIED BY DECOR VENDOR) - COORD. W/ DECOR VENDOR.
	TYPE B - SCONCE LIGHTS - BESA LIGHT "TAMBURO" GARNET 704241-SN-LMP/L W/ GU-24 LAMP(S) NOTE: COORDINATE LOCATION AND QUANTITY WITH DECOR SUPPLIER. 6'-4" A.F.F. TO BOTTOM OF LIGHT.
	TYPE B-2L - CEILING MOUNTED PENDANT LIGHT - BESA LIGHTING - 1JT-169741-GU24-SN-BK-6-LL
	TYPE K - ENERGYWISE RECESSED MOUNT EXT. SOFFIT LIGHT - USE EXIST. SOFFIT CIRCUIT; VERIFY LOAD AND ELEC.
	WALL WASHER TO ILLUMINATE ART BY G.C.
	TYPE J - GOOSE NECK EXT. FIXTURE - STONCO - X1AF8132K1YFBQ1E - EXPRESSIVE SERIES 4' LINEAR FLOOR. MARKED FOR WET LOCATION; ARM STYLE SL4 W/ ACS3XX CABLE SUPPORT - USE EXIST. SOFFIT CIRCUIT; VERIFY LOAD AND ELEC.
	TYPE G - ENERGYWISE 2' X 4' LED LIGHT FIXTURE
	TYPE E - ENERGYWISE - 1' X 4' LED LIGHT FIXTURE
	TYPE G3 - ENERGYWISE 2' X 2' LED LIGHT FIXTURE
	TYPE G4 - ENERGYWISE 2' X 4' LED LIGHT FIXTURE (4000K)
	LOCATION OF EXISTING AND NEW TV'S - G.C. PROVIDE CABLE AND POWER AS REQUIRED. COORD. W/ DECOR AND OWNER
	2X2' SUSPENDED ACOUSTICAL CEILING TILE AND GRID
	GYPSUM SOFFIT BOARD CEILING
	EMERGENCY LIGHTING
	EXTERIOR EMERGENCY LIGHT - DAMP RATED LED LIGHT WIRED TO SAME-CIRCUIT AS INTERIOR & PROVIDED W/ INTERNAL BATTERY BACKUP.
	NEW ELECTRICAL OUTLET PROVIDE PER INTERIORS PLAN.
	RECESSED LIGHT FIXTURE
	HVAC RETURN
	HVAC DIFFUSER

NO.	DATE	BY	CHECKED BY	REVISION
01	11/20/17	BO/PERMIE	BO/PERMIE	
02				
03				
04				
05				
06				
07				



PREMIER HOLDINGS OF GEORGIA, LLC
3838 Stewart Road, Unit A
Doraville, GA 30040

2126 Morris Avenue
Atlanta, GA 30303
Phone: (404) 322-1251
Fax: (404) 322-1778
email: info@hplaha.com
www.hplaha.com

James M. Huxkestein
architect AIA
architecture • planning • interior design



PROJECT #17024.11
IMAGE 20/20 - JULY 2012 STANDARDS

BURGER KING
5141 JONESBORO RD
LAKE CITY, GA 30260

REFLECTED CEILING PLAN