



11/28/2017 1:19:34 PM

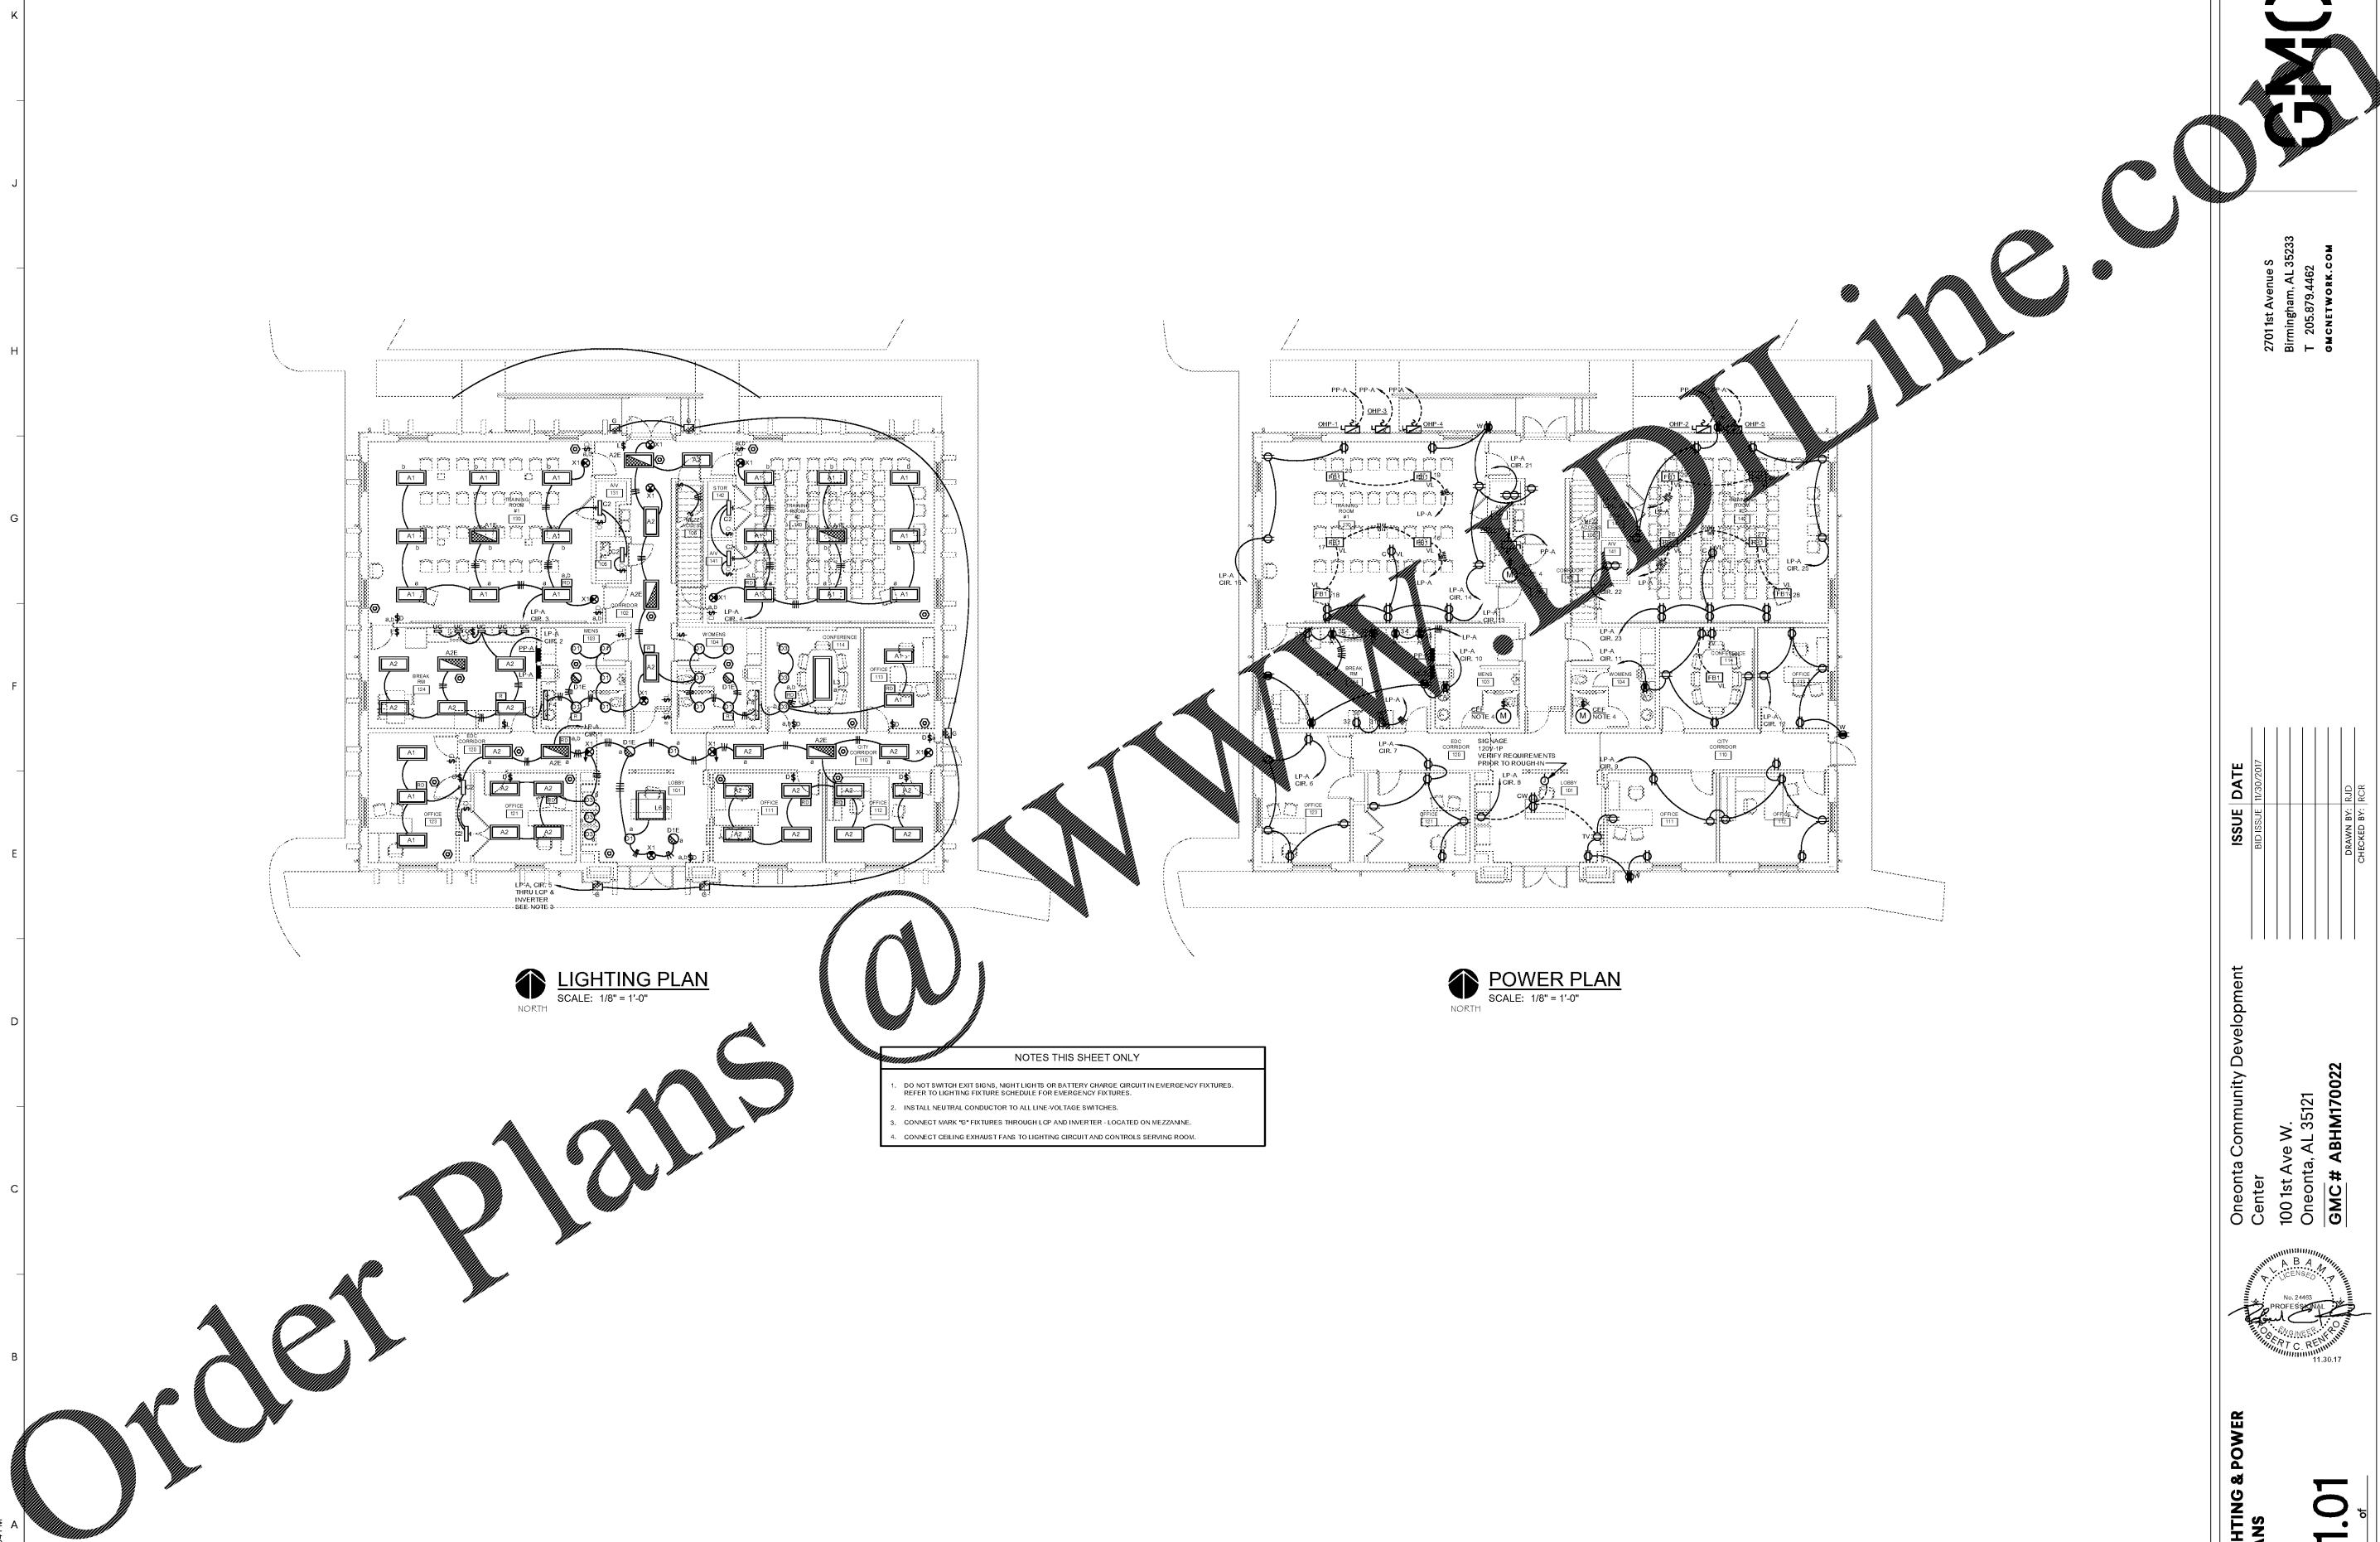


**LIGHTING PLAN**  
 SCALE: 1/8" = 1'-0"  
 NORTH


**POWER PLAN**  
 SCALE: 1/8" = 1'-0"  
 NORTH

NOTES THIS SHEET ONLY

1. DO NOT SWITCH EXIT SIGNS, NIGHT LIGHTS OR BATTERY CHARGE CIRCUIT IN EMERGENCY FIXTURES. REFER TO LIGHTING FIXTURE SCHEDULE FOR EMERGENCY FIXTURES.
2. INSTALL NEUTRAL CONDUCTOR TO ALL LINE-VOLTAGE SWITCHES.
3. CONNECT MARK "X" FIXTURES THROUGH LCP AND INVERTER - LOCATED ON MEZZANINE.
4. CONNECT CEILING EXHAUST FANS TO LIGHTING CIRCUIT AND CONTROLS SERVING ROOM.

Order Plans @

ISSUE	DATE
BID ISSUE	11/30/2017

DRAWN BY: EJD  
CHECKED BY: RCR

Oneonta Community Development  
 Center  
 100 1st Ave W.  
 Oneonta, AL 35121  
**GMC # ABHM170022**



**LIGHTING & POWER PLANS**

**E1.01**  
Sheet of



2701 1st Avenue S  
 Birmingham, AL 35233  
 T 205.879.4482  
**GMCNETWORK.COM**

