



LIGHTING FIXTURE SCHEDULE		
	SYMBOL	DESCRIPTION
NEW		NEW 2x4 RECESSED PARABOLIC LITHONIA/ZESBPHE 232 05105X1 SB41HT8
NEW		NEW 2x4 RECESSED EMERGENCY PARABOLIC LITHONIA/ZESBP 232 1/3 05105X SB41HT8-NACV-EL14
EX		EXISTING 2x4 RECESSED PARABOLIC
EX		EXISTING 4' OR 2' RECESSED WALL WASHER
EX		EXISTING RECESSED 1x4 WITH CLEAR ACRYLIC PRISMATIC LENS
EX		RETURN AIR GRILLE
EX		SUPPLY AIR DIFFUSER
EX		2x4 LAY-IN GRID CEILING

CEILING LEGEND

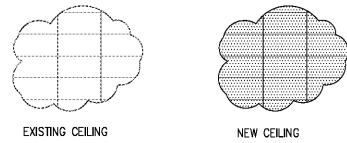

LIGHT FIXTURE LABEL

N - NEW LIGHT FIXTURE
 RE - EXISTING LIGHT FIXTURE TO BE RELOCATED
 NOT LABELED - EXISTING LIGHT FIXTURE TO REMAIN

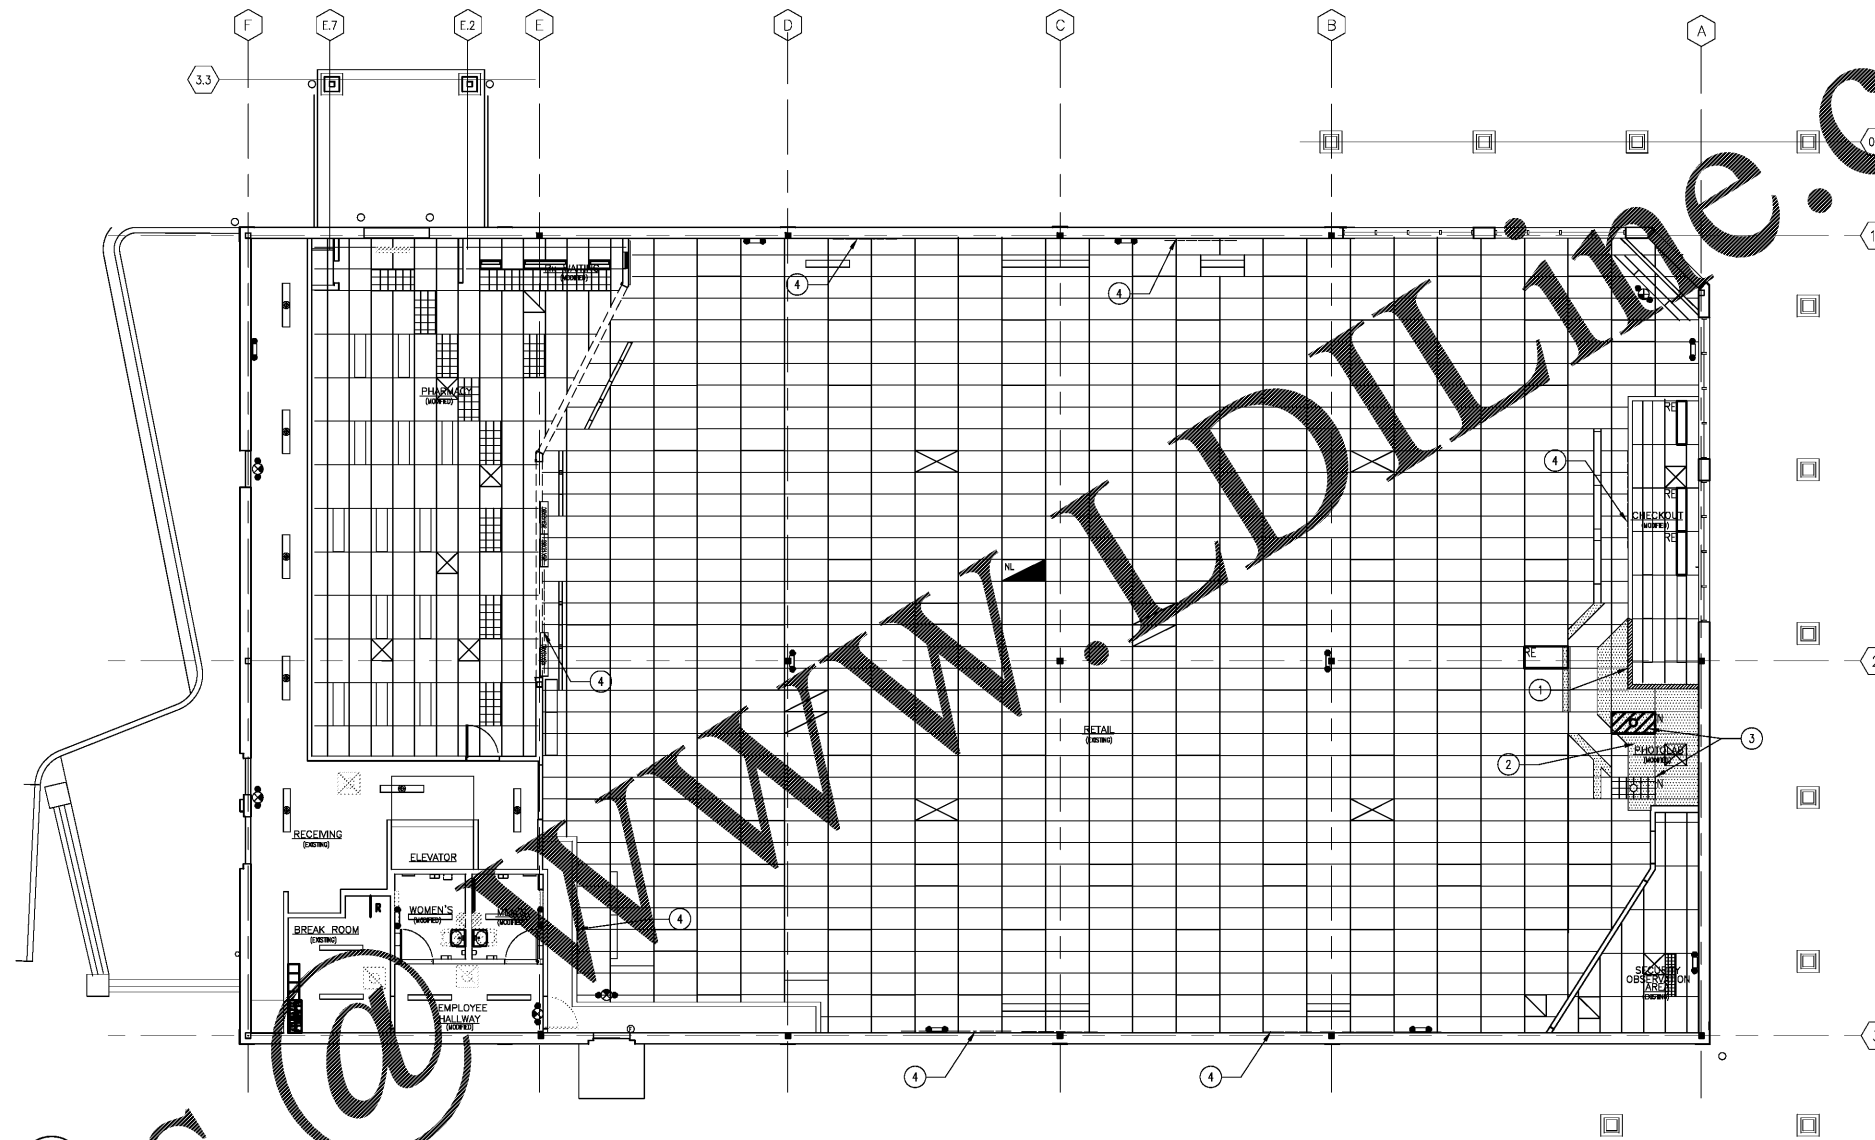

1 REFLECTED CEILING PLAN
 A2 SCALE: 1/8"=1'-0"


NOTES BY SYMBOL

- ① NEW VALANCE SHOWN HATCHED.
- ② NEW ACT CEILING SHOWN HATCHED IN RETAIL AREA.
- ③ NEW LIGHTS SHOWN IN RETAIL AREA
- ④ NEW PIN LETTERS, TYPICAL.



STORE NUMBER: 5553
 1801 BEN SAWYER BOULEVARD
 MT. PLEASANT, SC 29464
 PROJECT TYPE: ADA and THH
 DEAL TYPE:
 CS PROJECT NUMBER: 106857

ARCHITECT OF RECORD

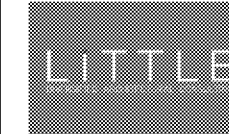

www.littleonline.com
 This drawing and the design shown are the property of Little Online Architectural Consulting. The reproduction, copying or other use of this drawing without their written consent is prohibited and any infringement will be subject to legal action.
 © Little 2017

CONSULTANT:



DEVELOPER:



SEA'



REVISIONS:

NO.	DESCRIPTION

CVS PROJECT MANAGER: TS
 DRAWING BY: JAC
 DATE: 10-23-2017
 JOB NUMBER: 121-7815-08
 TITLE:

REFLECTED CEILING PLAN
 SHEET NUMBER:

A2

COMMENTS:

Order Plans