

**EQUIPMENT LEGEND**

- EMERGENCY LIGHTING
- EXIT SIGN
- SKYLIGHT
- SUPPLY DROP BOX

**FINISH LEGEND**

- WALK-PANE
- GYP BOARD
- ACT REF ATT TYPE
- GLASS CLOTH
- OPEN TO STRUCTURE

**SHEET NOTES**

- FIRE, MECHANICAL AND ELECTRICAL ITEMS SHOWN ON THE REFLECTED CEILING PLAN ARE FOR COORDINATION PURPOSES ONLY
- REF FIRE, MECHANICAL, AND ELECTRICAL FOR SYMBOL LEGENDS

**RET DES**  
**DES**  
**DES**  
 RETAIL DESIGN COLLABORATIVE  
 Form Date: 11/30/17  
 713.308.9200  
 rdcollab@retdes.com

STIPULATION FOR THE USER: THIS DRAWING AND ANY INFORMATION CONTAINED HEREIN IS THE PROPERTY OF RETAIL DESIGN COLLABORATIVE. IT IS TO BE USED FOR THE PROJECT AND SITE SPECIFICALLY IDENTIFIED HEREIN ONLY. IT IS NOT TO BE REPRODUCED, COPIED, EITHER WHOLLY OR IN PART, FOR ANY OTHER PROJECT WITHOUT THE WRITTEN PERMISSION OF RETAIL DESIGN COLLABORATIVE. ANY REPRODUCTION OR USE OF THIS DRAWING FOR ANY OTHER PROJECT WITHOUT THE WRITTEN PERMISSION OF RETAIL DESIGN COLLABORATIVE IS STRICTLY PROHIBITED AND WILL BE CONSIDERED A VIOLATION OF THE PROFESSIONAL ETHICS OF THE ARCHITECTURAL PROFESSION.

CONSULTANTS

**Walmart**  
**LEESBURG, VIRGINIA**  
 STORE NO: 1904-05  
 JOB NUMBER: 190628 | PHOTO: C-HIGGS/LO

**ISSUE BLOCK**


OTB	11/30/17

CHECKED BY: RW  
 DRAWN BY: EH  
 PHOTO CYCLE: 04/28/17  
 DOCUMENT DATE: 09/13/17

**BID SET  
 NOT FOR  
 CONSTRUCTION**

**REFLECTED  
 CEILING  
 PLAN**

SHEET  
**A1.2**

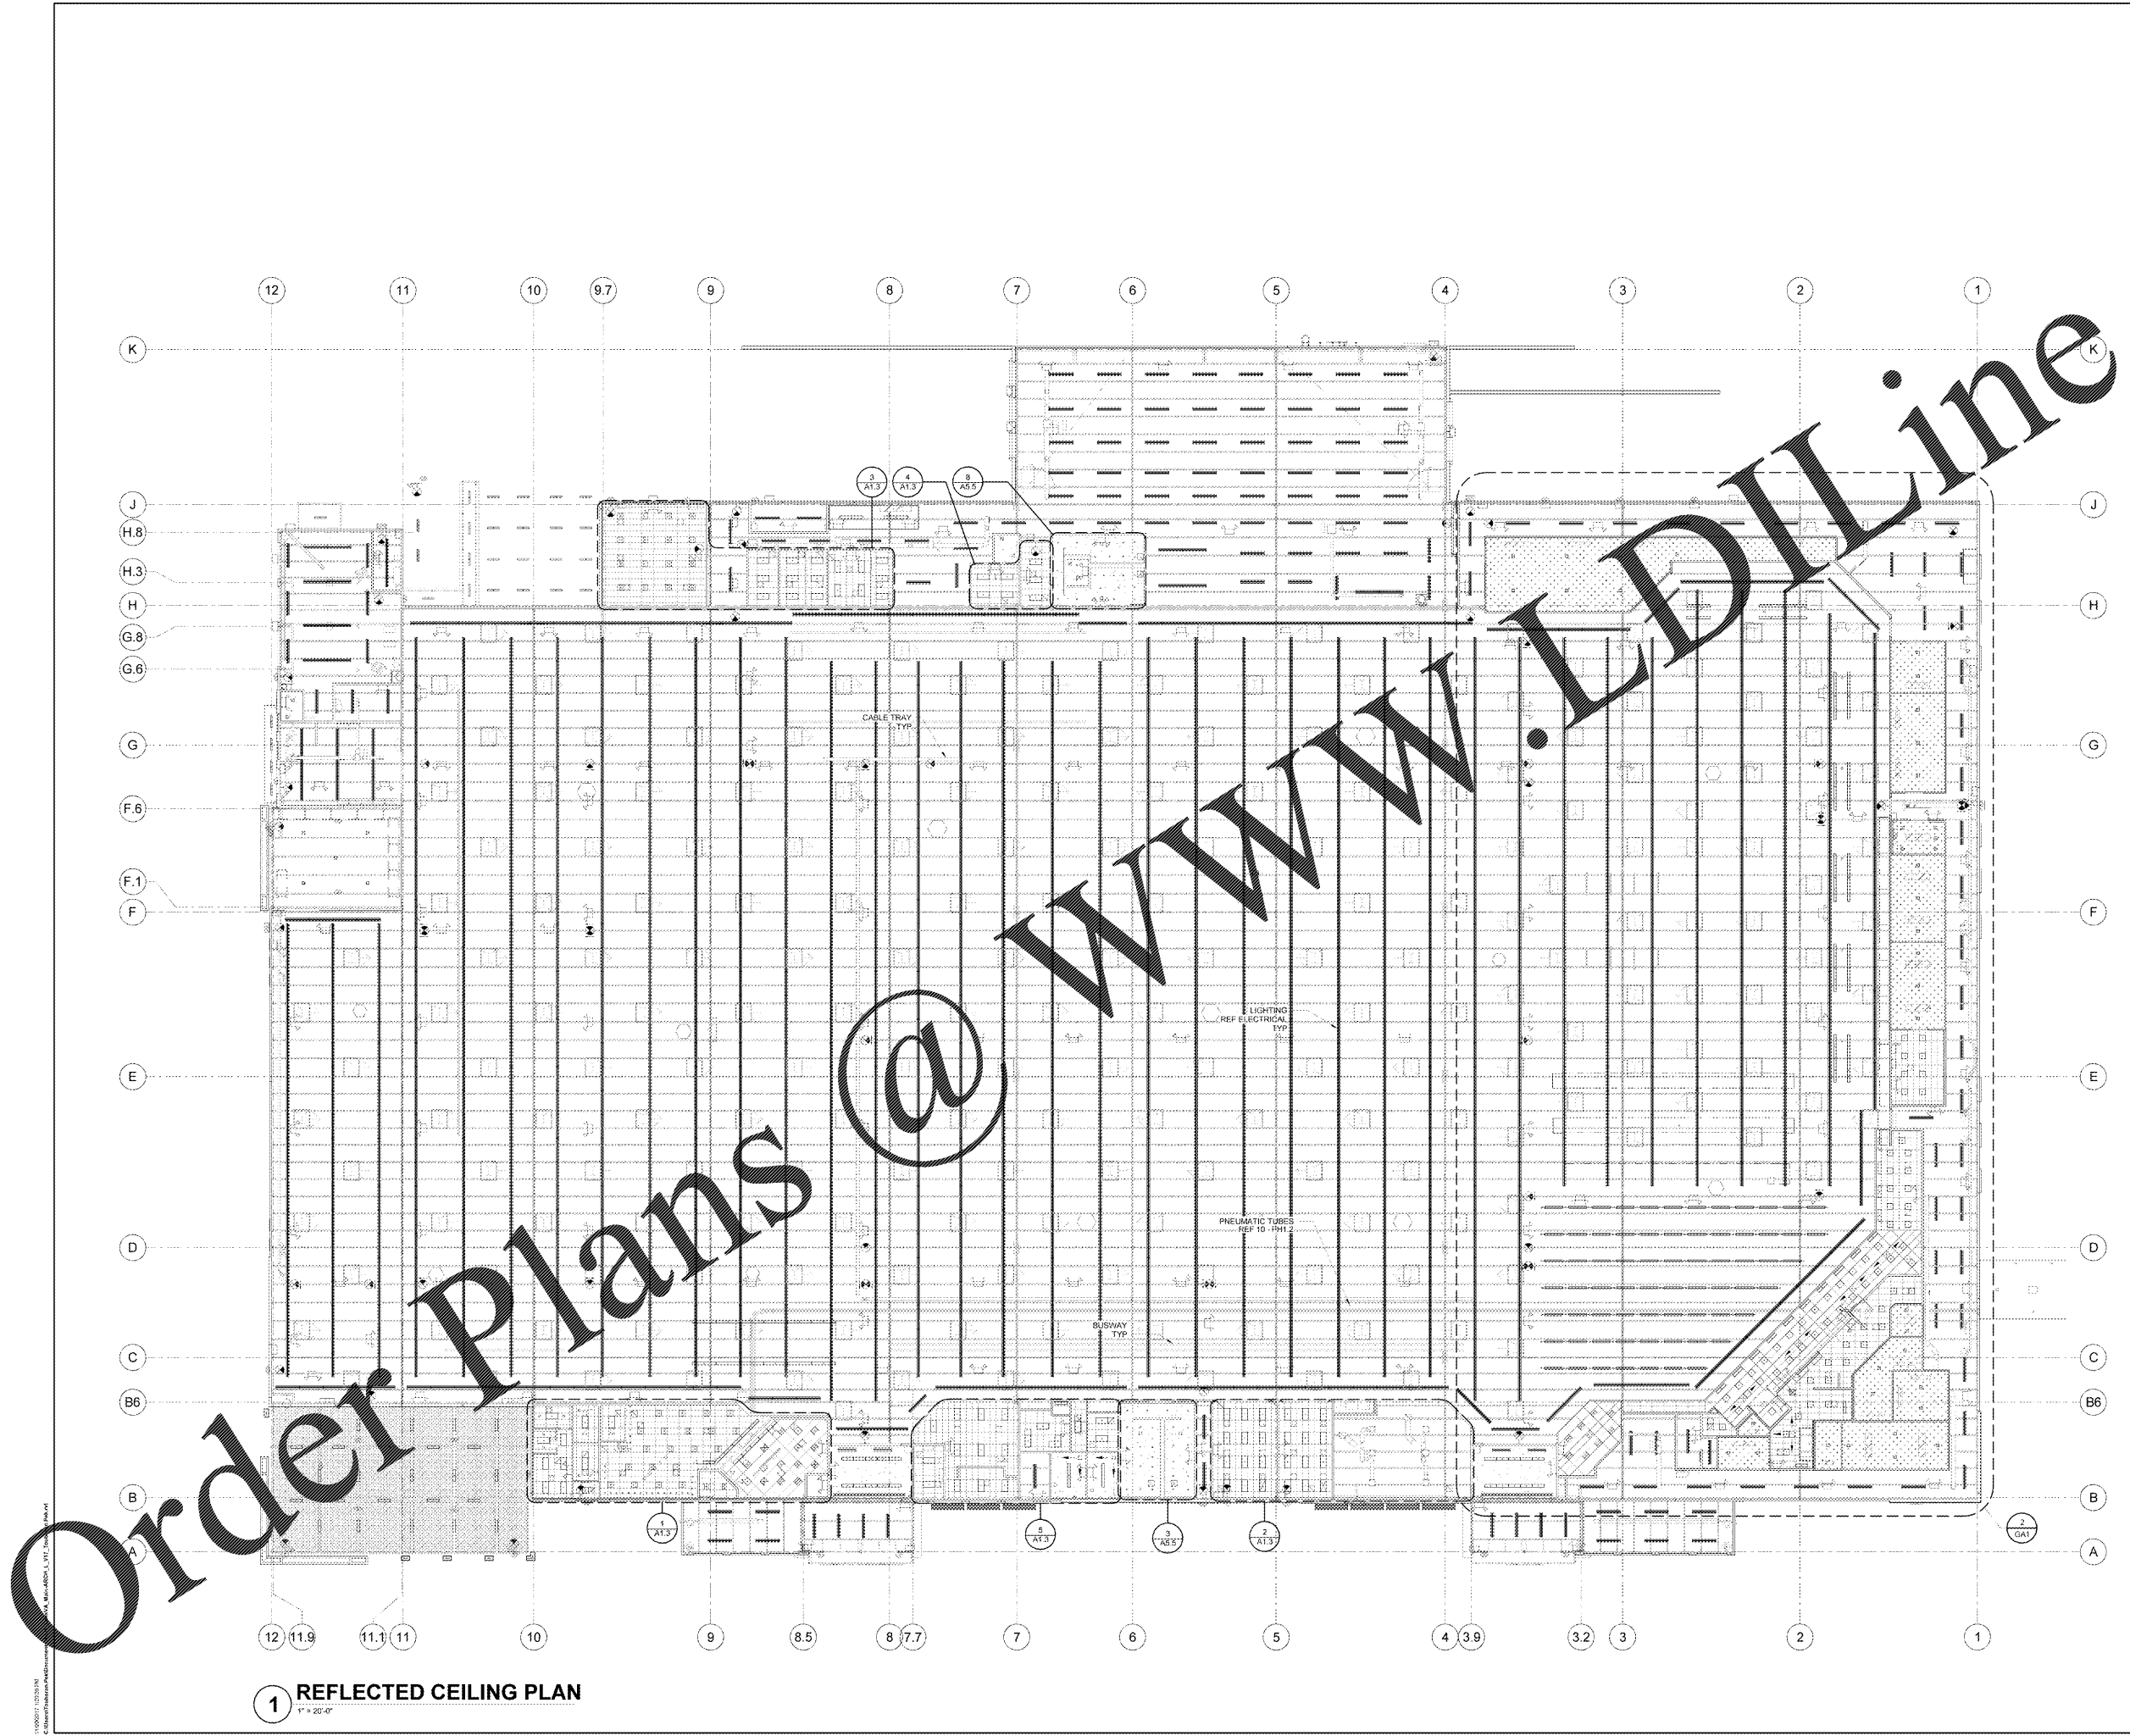

**1 REFLECTED CEILING PLAN**  
 1" = 20'-0"

Order Plans @ WWW.LDLine.com

© 2017 LDLine, LLC. All Rights Reserved. LDLine.com