



Order Plans

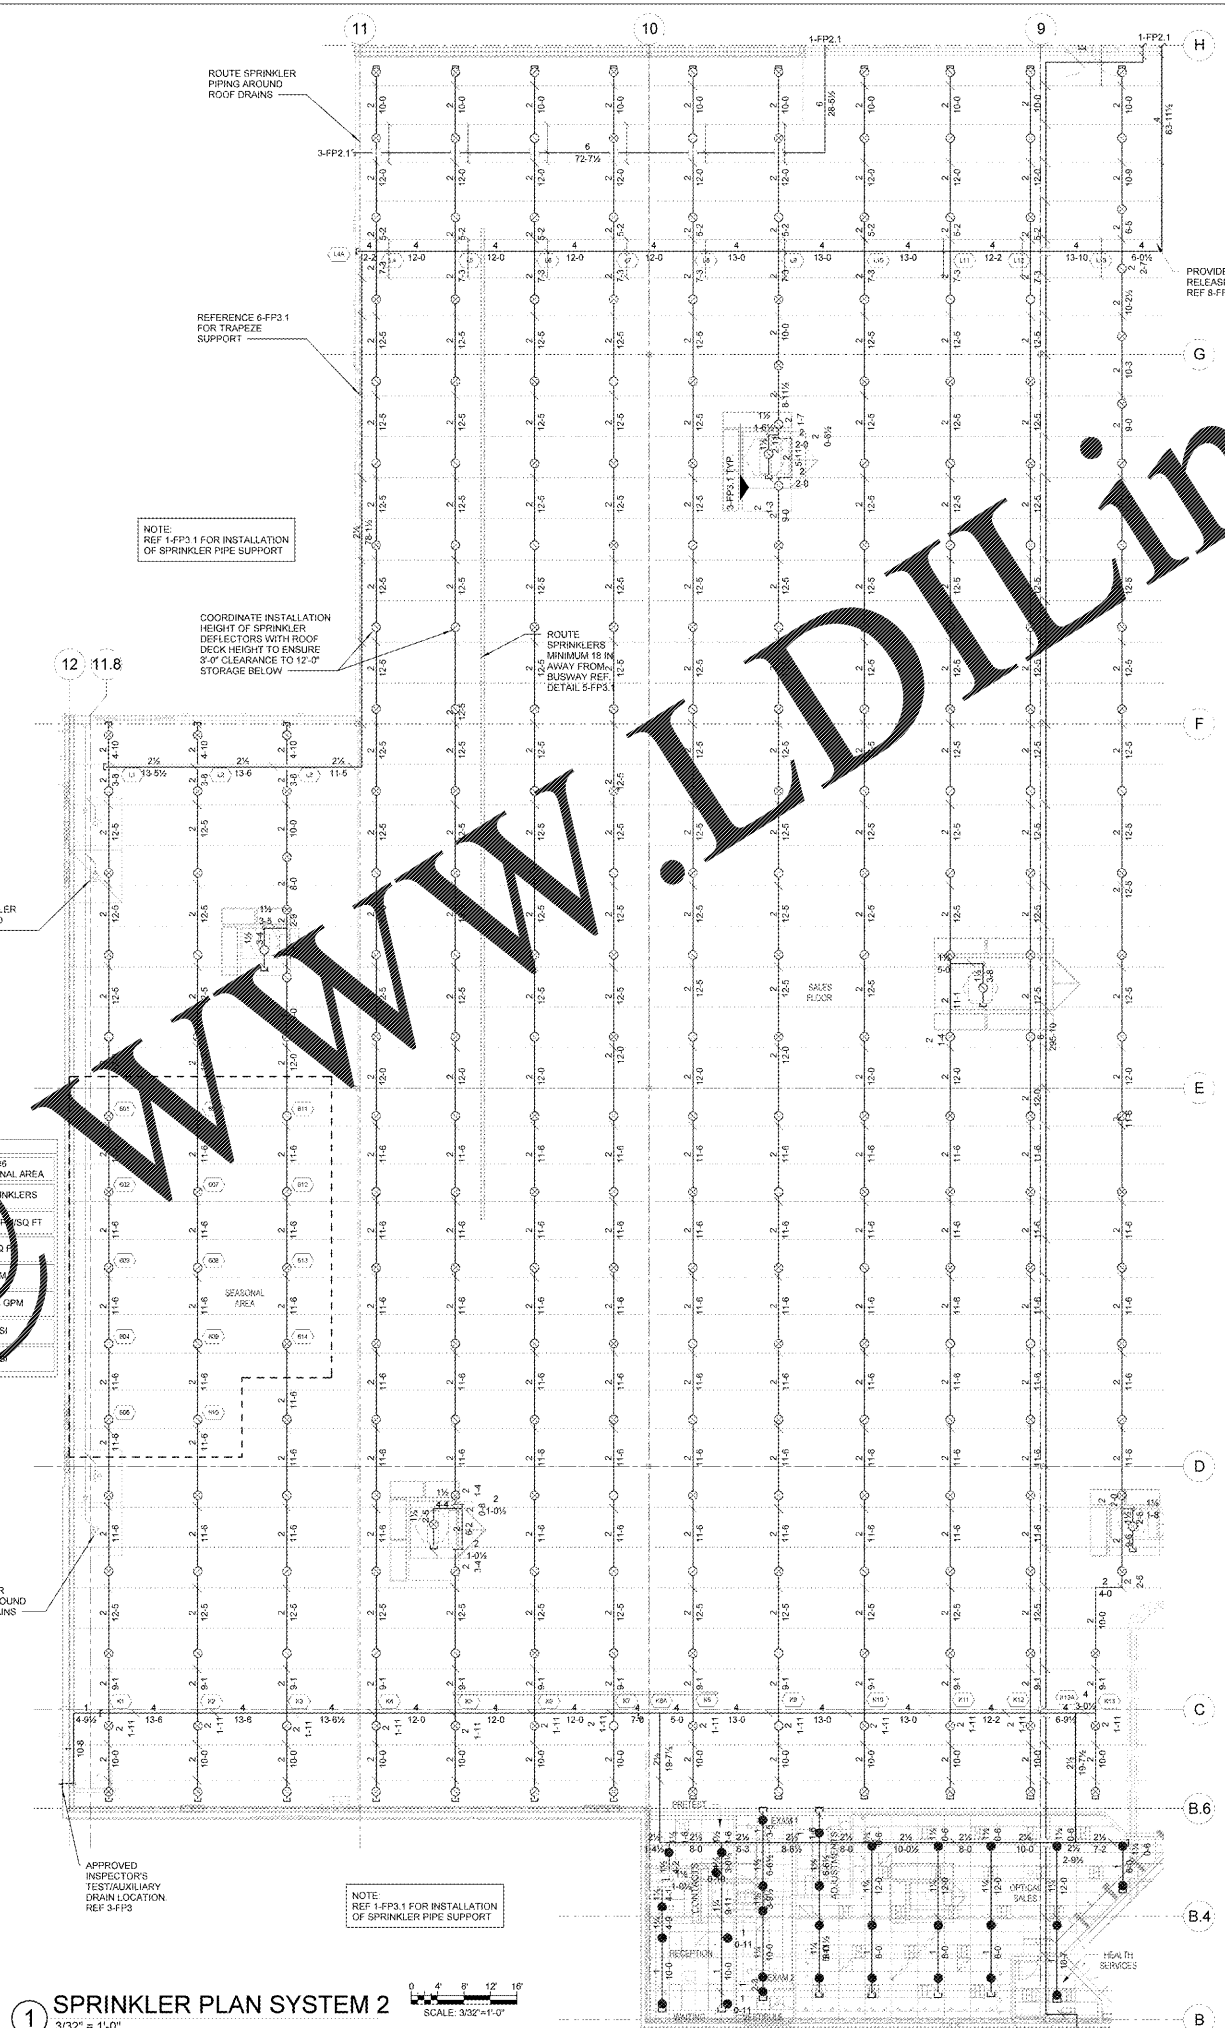

HYDRAULIC DESIGN

SYSTEM #2	AREA #8
SPRINKLERS CALCULATED	14 SPRINKLERS
SPRINKLER DENSITY REQ.	0.425 GPM/SQ FT
AREA OF DISCHARGE	3300 SQ FT
HOSE ALLOWANCE	5 GPM
SYSTEM FLOW DEMAND @ 150 PSI	135 GPM
SYSTEM DEMAND @ 150 PSI	85.22 PSI
SYSTEM SAFETY FACTOR	48.3%

1 SPRINKLER PLAN SYSTEM 2
3/32" = 1'-0"
SCALE: 3/32"=1'-0"

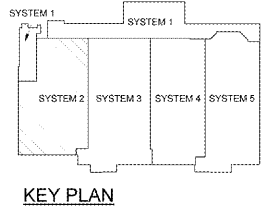

FIRE SPRINKLER PLAN SYSTEM 2
SHEET: FP2.2

RET DESIGN COLLABORATIVE
RETAIL DESIGN COLLABORATIVE

CONSULTANTS
Ricky V. Terrell
ARCHITECT

Walmart
LEESBURG, VIRGINIA
STORE NO. 1904
JOB NUMBER: 11000261
PROTO: 0428017

ISSUE BLOCK
11/30/17 : OTB

CHECKED BY: ERP
DRAWN BY: REI
FILE NAME: FP2.2
PROTO CYCLE: 19585
DOCUMENT DATE: 09/13/17

BID SET NOT FOR CONSTRUCTION

WWW.LDOnline.com