




3 GM VESTIBULE SECTION
NTS

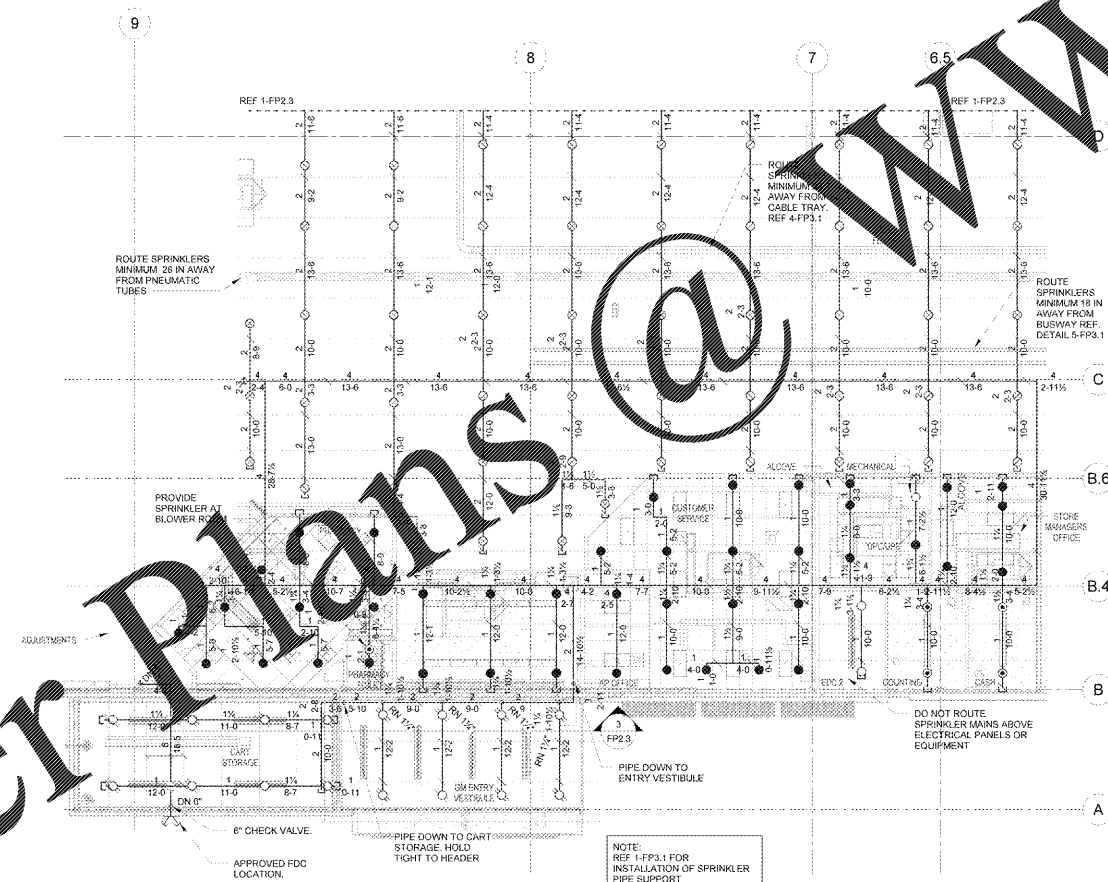

2 SPRINKLER PLAN SYSTEM 3
3/32" = 1'-0"

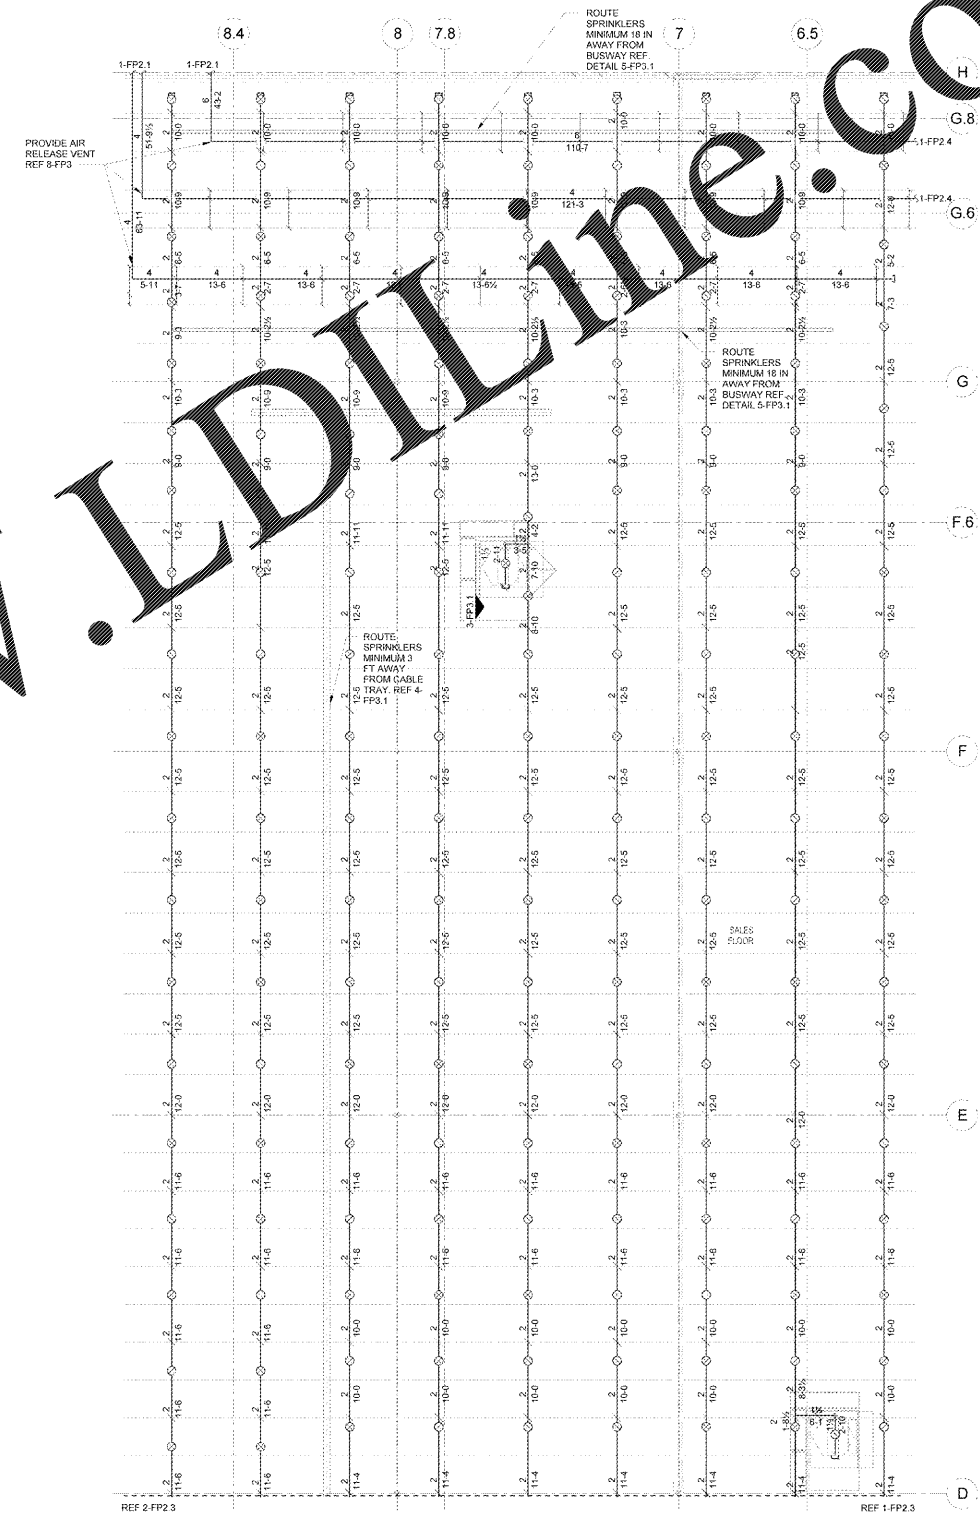

1 SPRINKLER PLAN SYSTEM 3
3/32" = 1'-0"

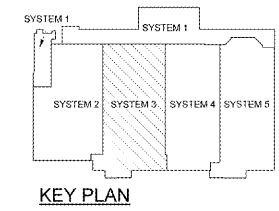

FIRE SPRINKLER PLAN SYSTEM 3

SHEET: FP2.3

CHECKED BY:	ERP
DRAWN BY:	REI
FILE NAME:	FP2.3
PROTO CYCLE:	19585
DOCUMENT DATE:	09/13/17

BID SET NOT FOR CONSTRUCTION

ISSUE BLOCK
11/30/17 OTB

Walmart
LEESBURG, VIRGINIA
STORE NO.: 1904
JOB NUMBER: 1109236 | PHOTO: 042847

CONSULTANTS
RICKY A. LITTLE
ARCHITECTS
1000 W. MARKET ST. SUITE 200
LEESBURG, VA 22076
PHONE: 703.444.8800
WWW.RICKYLITTLE.COM

RET DES
COLLABORATIVE
STIPULATION FOR USE:
THIS DRAWING IS THE PROPERTY OF RETAIL DESIGN COLLABORATIVE AND IS TO BE USED ONLY FOR THE PROJECT AND SITE SPECIFICALLY IDENTIFIED HEREIN. IT IS NOT TO BE REPRODUCED, COPIED, OR TRANSMITTED IN ANY FORM OR BY ANY MEANS, ELECTRONIC OR MECHANICAL, INCLUDING PHOTOCOPYING, RECORDING, OR BY ANY INFORMATION STORAGE AND RETRIEVAL SYSTEM, WITHOUT THE WRITTEN PERMISSION OF RETAIL DESIGN COLLABORATIVE. ANY UNAUTHORIZED USE OF THIS DRAWING IS PROHIBITED AND WILL BE SUBJECT TO LEGAL ACTION.

Order Plans @ www.ldonline.com