

 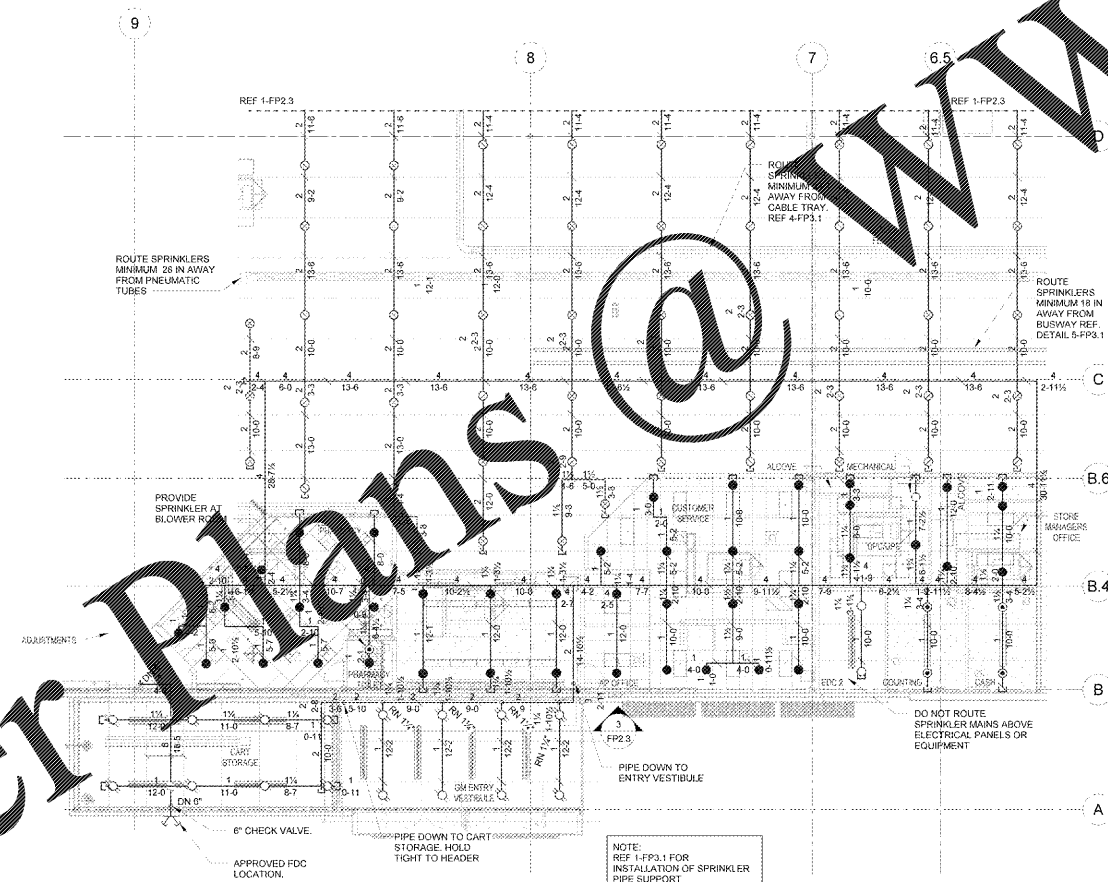




3 GM VESTIBULE SECTION  
NTS

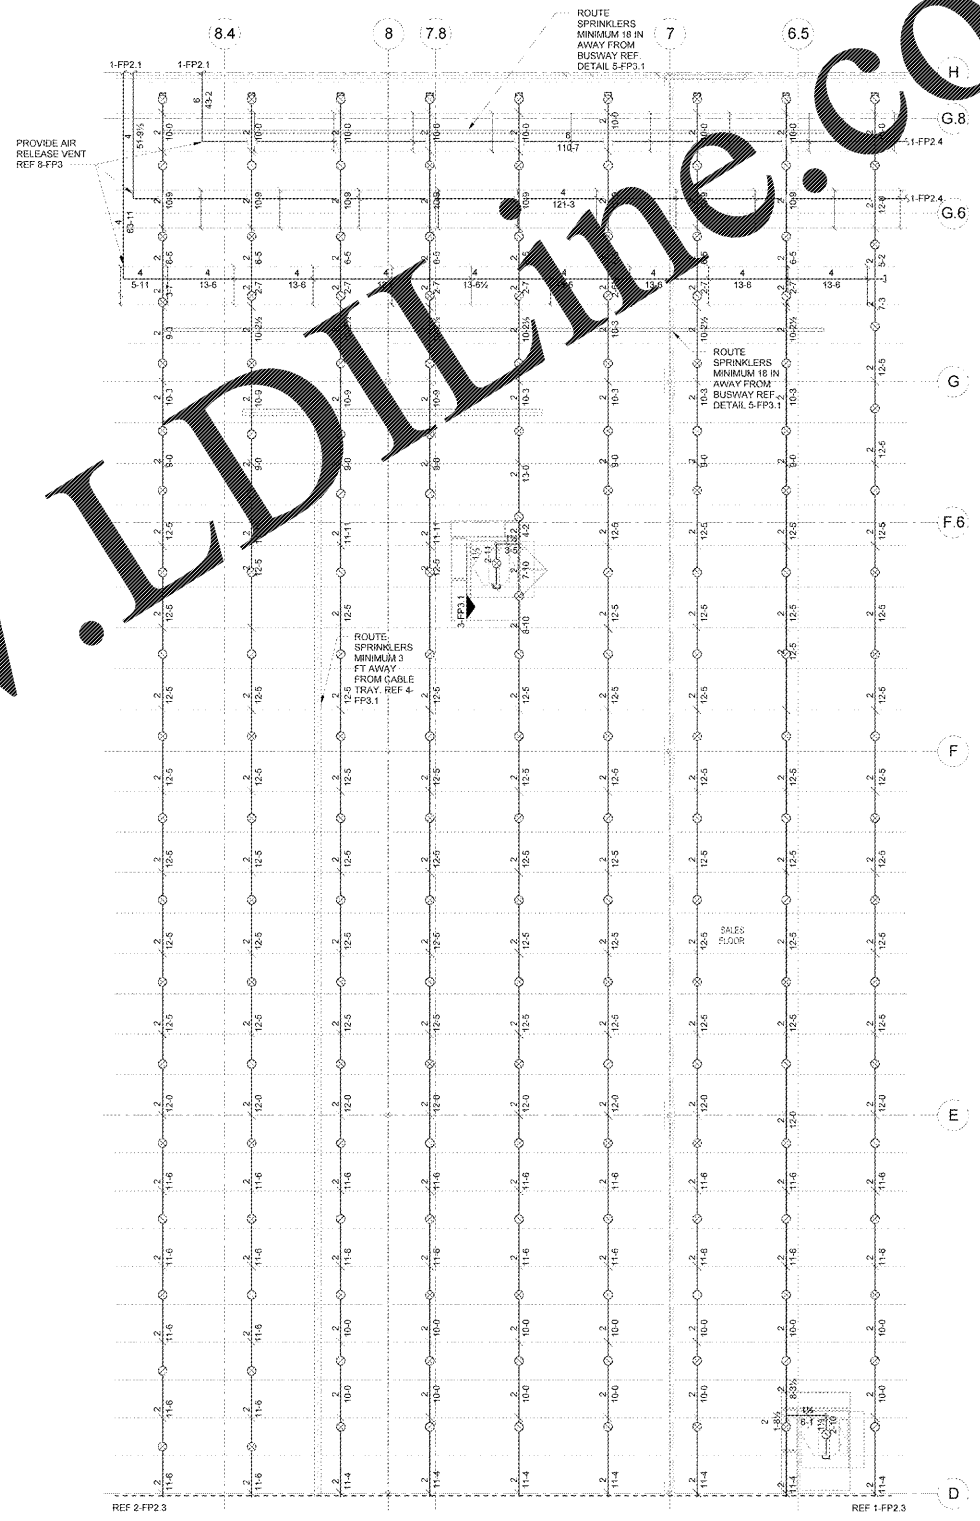

2 SPRINKLER PLAN SYSTEM 3  
3/32" = 1'-0"



 1 SPRINKLER PLAN SYSTEM 3  
3/32" = 1'-0"

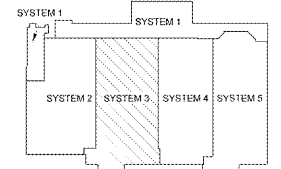

KEY PLAN

FIRE  
SPRINKLER  
PLAN  
SYSTEM 3

SHEET:  
FP2.3

CHECKED BY:	ERP
DRAWN BY:	REI
FILE NAME:	FP2.3
PROTO CYCLE:	19585
DOCUMENT DATE:	09/13/17

BID SET NOT FOR  
CONSTRUCTION

ISSUE BLOCK  
11/30/17 OTB

Walmart  
LEESBURG, VIRGINIA  
STORE NO.: 1904  
1109236 : PHOTO  
JOB NUMBER

CONSULTANTS  
RICKY A. LITTLE  
ARCHITECTS  
10000 WOODBURN DRIVE  
ROSELAND, NC 27068  
PH: 703.444.8800  
WWW.RICKYLITTLE.COM

RETAIL DESIGN COLLABORATIVE

Order Plans @ [www.ldinline.com](mailto:www.ldinline.com)