

GENERAL NOTES

- REFER TO ARCHITECTURAL DRAWINGS FOR PIPING INSTALLATION AND SEALING REQUIREMENTS FOR DEVICES SHOWN ON COOLER/FREEZER PANELS. DO NOT INSTALL PIPING WITHIN COOLER/FREEZER PANELS.
- PROVIDE BACKFLOW PREVENTION ON THREADED EQUIPMENT, HOSE BIBBS, AND ALL FAUCETS WITH THREADED SPOUTS. REFER TO PLUMBING FIXTURE SCHEDULE.
- PROVIDE ESCUTCHEON PLATES FOR PLUMBING PENETRATIONS THROUGH GROCERY CEILING AND WALLS.
- PROVIDE AIR-TIGHT SEAL AROUND PIPE PENETRATIONS THROUGH COOLER, FREEZER, WALLS AND CEILING. FINISH WITH ESCUTCHEON PLATE.
- SET TOP OF FLOOR DRAIN, FLOOR SINKS, TRENCY DRAINS, AND FLOOR SPOUTS WITH FINISH FLOOR UNLESS NOTED OTHERWISE.
- INSTALL CENTERLINE OF GROCERY WALL PENETRATIONS AND WALL LEANOUTS AT 12" AFF MINIMUM ABOVE TOP OF ARCHITECTURAL SANITARY COVER UNLESS NOTED OTHERWISE.

KEYNOTES

- 15.112 SET TOP OF DRAIN ELEVATION AT 99.97' SLOPE FLOOR TO DRAIN PER OPEN FLOOR AREA DRAIN DETAIL.
- 15.114 SET TOP OF DRAIN ELEVATION AT 96.88' COORDINATE LOCATION WITH FLOOR SLOPE. REFER TO ARCHITECTURAL DRAWINGS.
- 15.119 PROVIDE CAST IRON PIPE AND FITTINGS DOWNSTREAM OF HUB DRAIN TO POINT INDICATED BY KEYNOTE. BRANCH PIPING AND PIPING MATERIAL DOWNSTREAM OF POINT INDICATED BY KEYNOTE SHALL BE PER SPECIFICATIONS.





ISSUE BLOCK	11/30/17 OTB
CHECKED BY:	DPK
DRAWN BY:	JOS
FILE NAME:	GP1
PROTO CYCLE:	04/28/17
DOCUMENT DATE:	09/13/17


BID SET NOT FOR CONSTRUCTION

FRONT GROCERY DWV PLAN


GP1

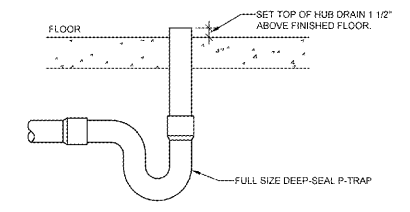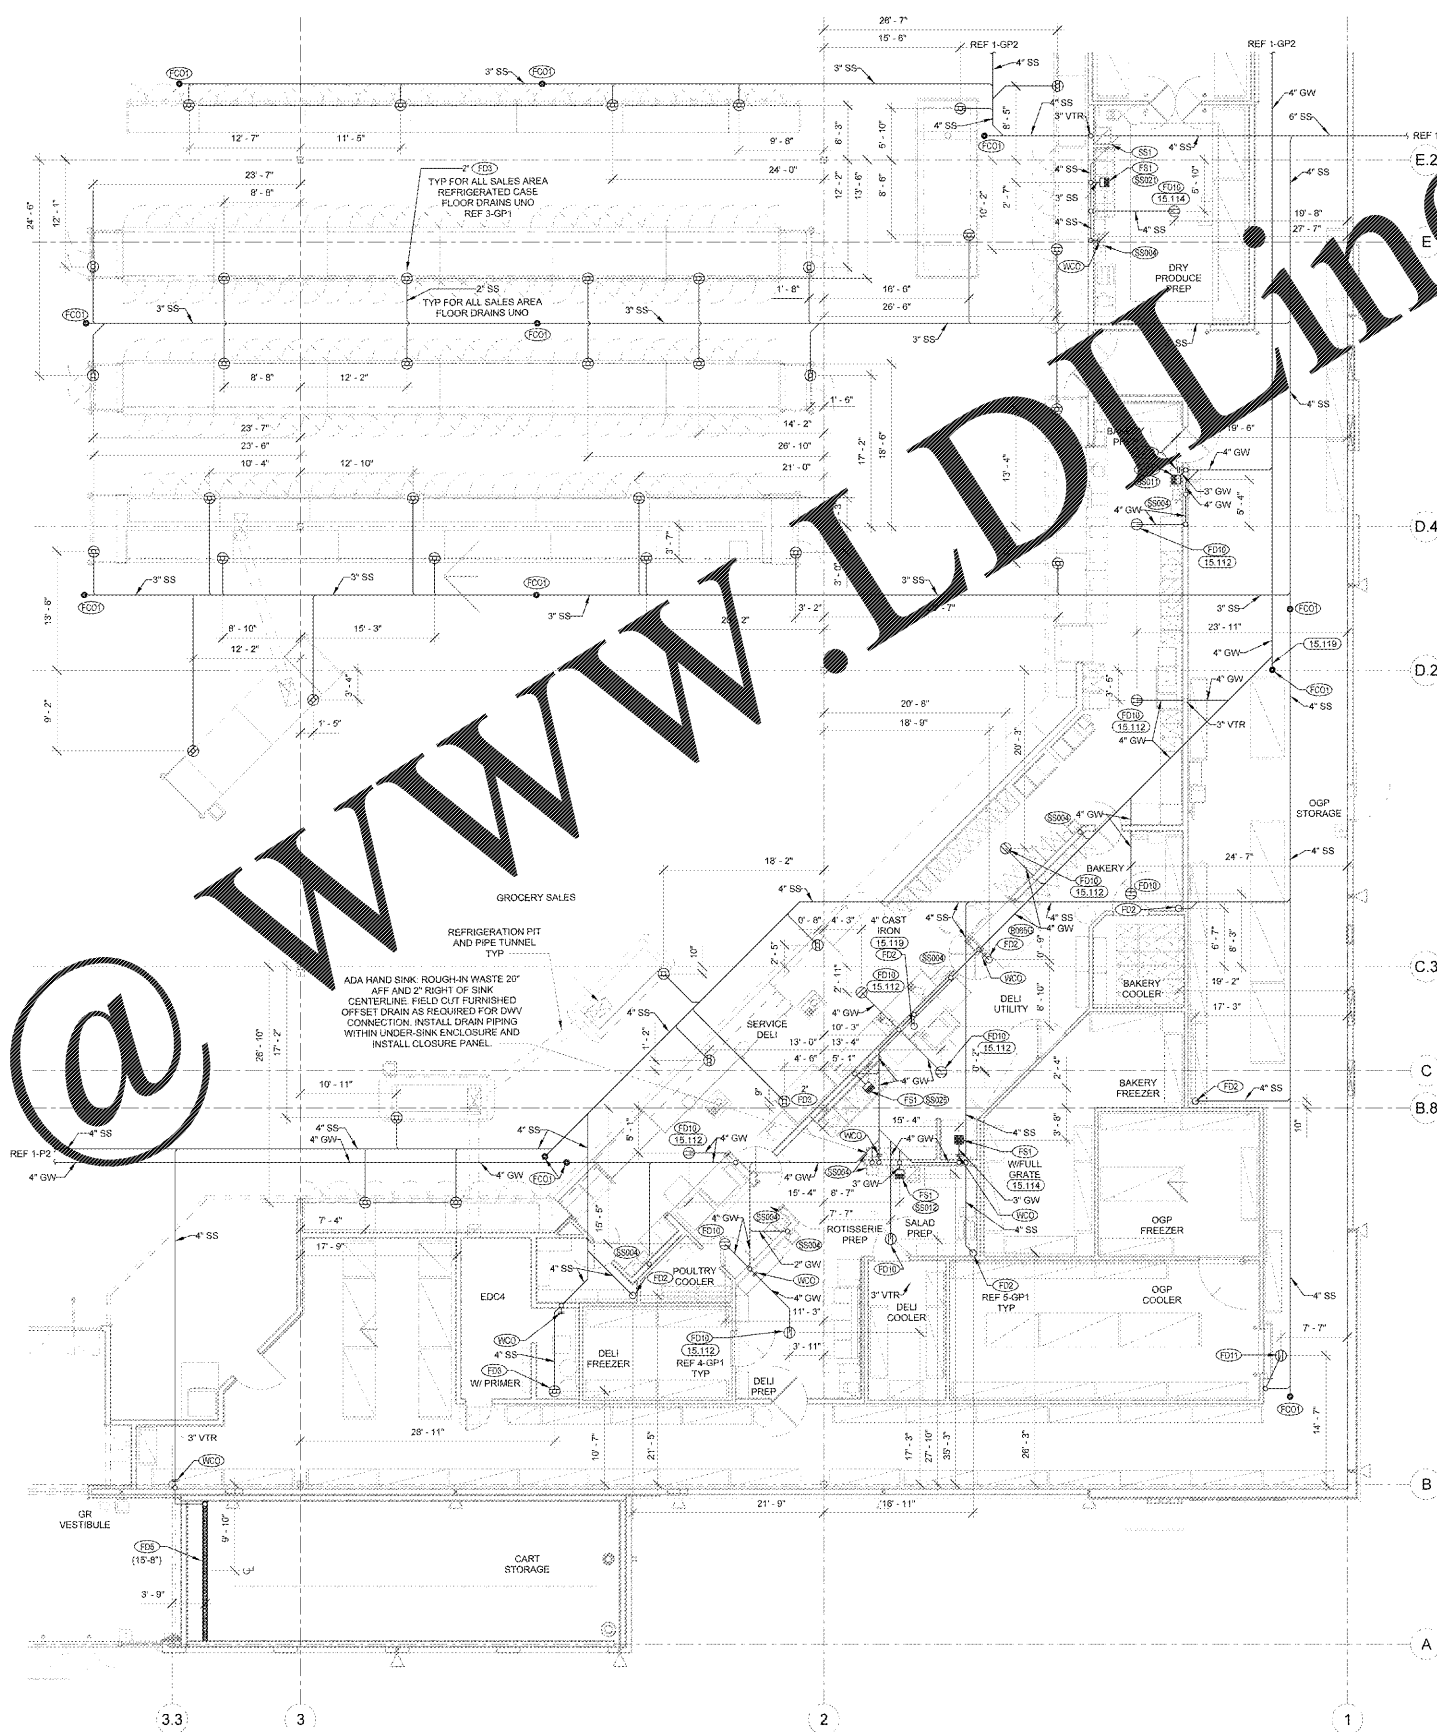


5 HUB DRAIN
NTS

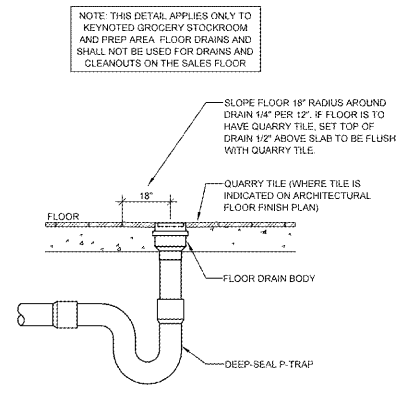

4 OPEN FLOOR AREA DRAIN
NTS

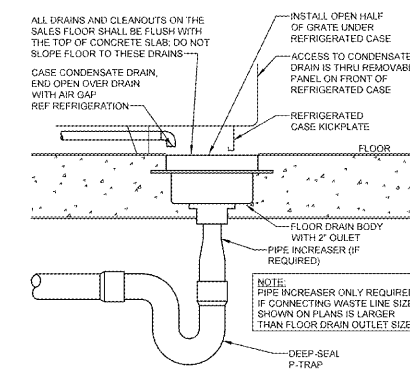

3 REFRIGERATED CASE DRAIN
NTS

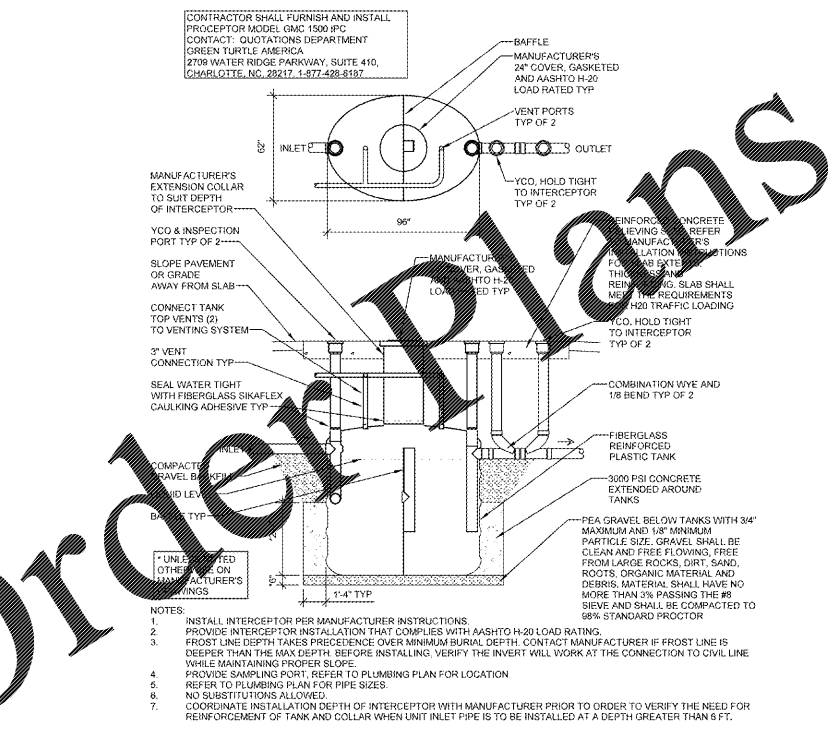

2 GREASE INTERCEPTOR - IPC
NTS

1 FRONT GROCERY DWV PLAN
1/8" = 1'-0"

Order Plans

- CONTRACTOR SHALL FURNISH AND INSTALL PROCEPTOR MODEL GMC 1500 IPC CONTACT: QUOTATIONS DEPARTMENT GREEN TURTLE AMERICA 2709 WATER RIDGE PARKWAY, SUITE 410, CHARLOTTE, NC 28217 1-877-498-6197
- INSTALL INTERCEPTOR PER MANUFACTURER INSTRUCTIONS.
 - PROVIDE INTERCEPTOR INSTALLATION THAT COMPLIES WITH AASHTO H-20 LOAD RATING.
 - FROST LINE DEPTH TAKES PRECEDENCE OVER MINIMUM BURIAL DEPTH. CONTACT MANUFACTURER IF FROST LINE IS DEEPER THAN THE MAX DEPTH BEFORE INSTALLING. VERIFY THE INVERT WILL WORK AT THE CONNECTION TO CIVIL LINE WHILE MAINTAINING PROPER SLOPE.
 - PROVIDE SAMPLING POINT. REFER TO PLUMBING PLAN FOR LOCATION.
 - REFER TO PLUMBING PLAN FOR PIPE SIZES.
 - NO SUBSTITUTIONS ALLOWED.
 - COORDINATE INSTALLATION DEPTH OF INTERCEPTOR WITH MANUFACTURER PRIOR TO ORDER TO VERIFY THE NEED FOR REINFORCEMENT OF TANK AND COLLAR WHEN UNIT INLET PIPE IS TO BE INSTALLED AT A DEPTH GREATER THAN 6 FT.