

GROCERY LIGHTING NOTES

- KEEP PENETRATIONS THROUGH COOLER AND FREEZER BOXES TO A MINIMUM. ROUTE ALL CONDUITS SERVING LIGHT FIXTURES IN FREEZERS AND COOLERS ON INSIDE OF BOX.
- ALL CONDUITS INSTALLED ON TOP OF WALK-IN COOLERS AND FREEZERS SHALL BE A MINIMUM OF 6" FROM ANY EDGE TO ALLOW SPACE FOR EDGE PROTECTION NETTING. DO NOT ROUTE CONDUITS ABOVE THE CEILING GRID ACCESS UNLESS CONDUITS ARE INSTALLED IN JOIST SPACE, REF ARCHITECTURAL DRAWINGS.

KEYNOTES

- 16.024 CONNECT CIRCUIT TO DUAL TAP CIRCUIT BREAKER INDICATED. CONNECT CIRCUIT OF FANNS NIGHT-EMERGENCY LIGHTING TO SWITCHED TERMINATION OF LINE TO CIRCUIT BREAKER.
- 18.219 OWNER FURNISHES 2" RIGID TUBING TO UTILIZE UNISTRUT TO MOUNT TRACK EVEN TO THE BOTTOM CHASSIS OF BAR JOIST. OWNER TO UTILIZE LEEDS CURRENT & WHITE FIXTURES SHALL BE ATTACHED DIRECTLY TO TRACK UTILIZING PROVIDED CONNECTOR. PROVIDE POWER TO EACH TRACK FROM A 1/2" FLEXIBLE METAL CONDUIT. SEE MANUFACTURER'S INSTALLATION INFORMATION ON TRACK MOUNTING AND ATTACHING FIXTURES TO TRACK.



ISSUE BLOCK


| | |
|----------|-----|
| 11/30/17 | OTB |
|----------|-----|

CHECKED BY: SAG
 DRAWN BY: GAR
 FILE NAME: GE1
 PHOTO CYCLE: 0428/17
 DOCUMENT DATE: 09/13/17

BID SET NOT FOR CONSTRUCTION

ENLARGED GROCERY LIGHTING PLANS

SHEET: **GE1**

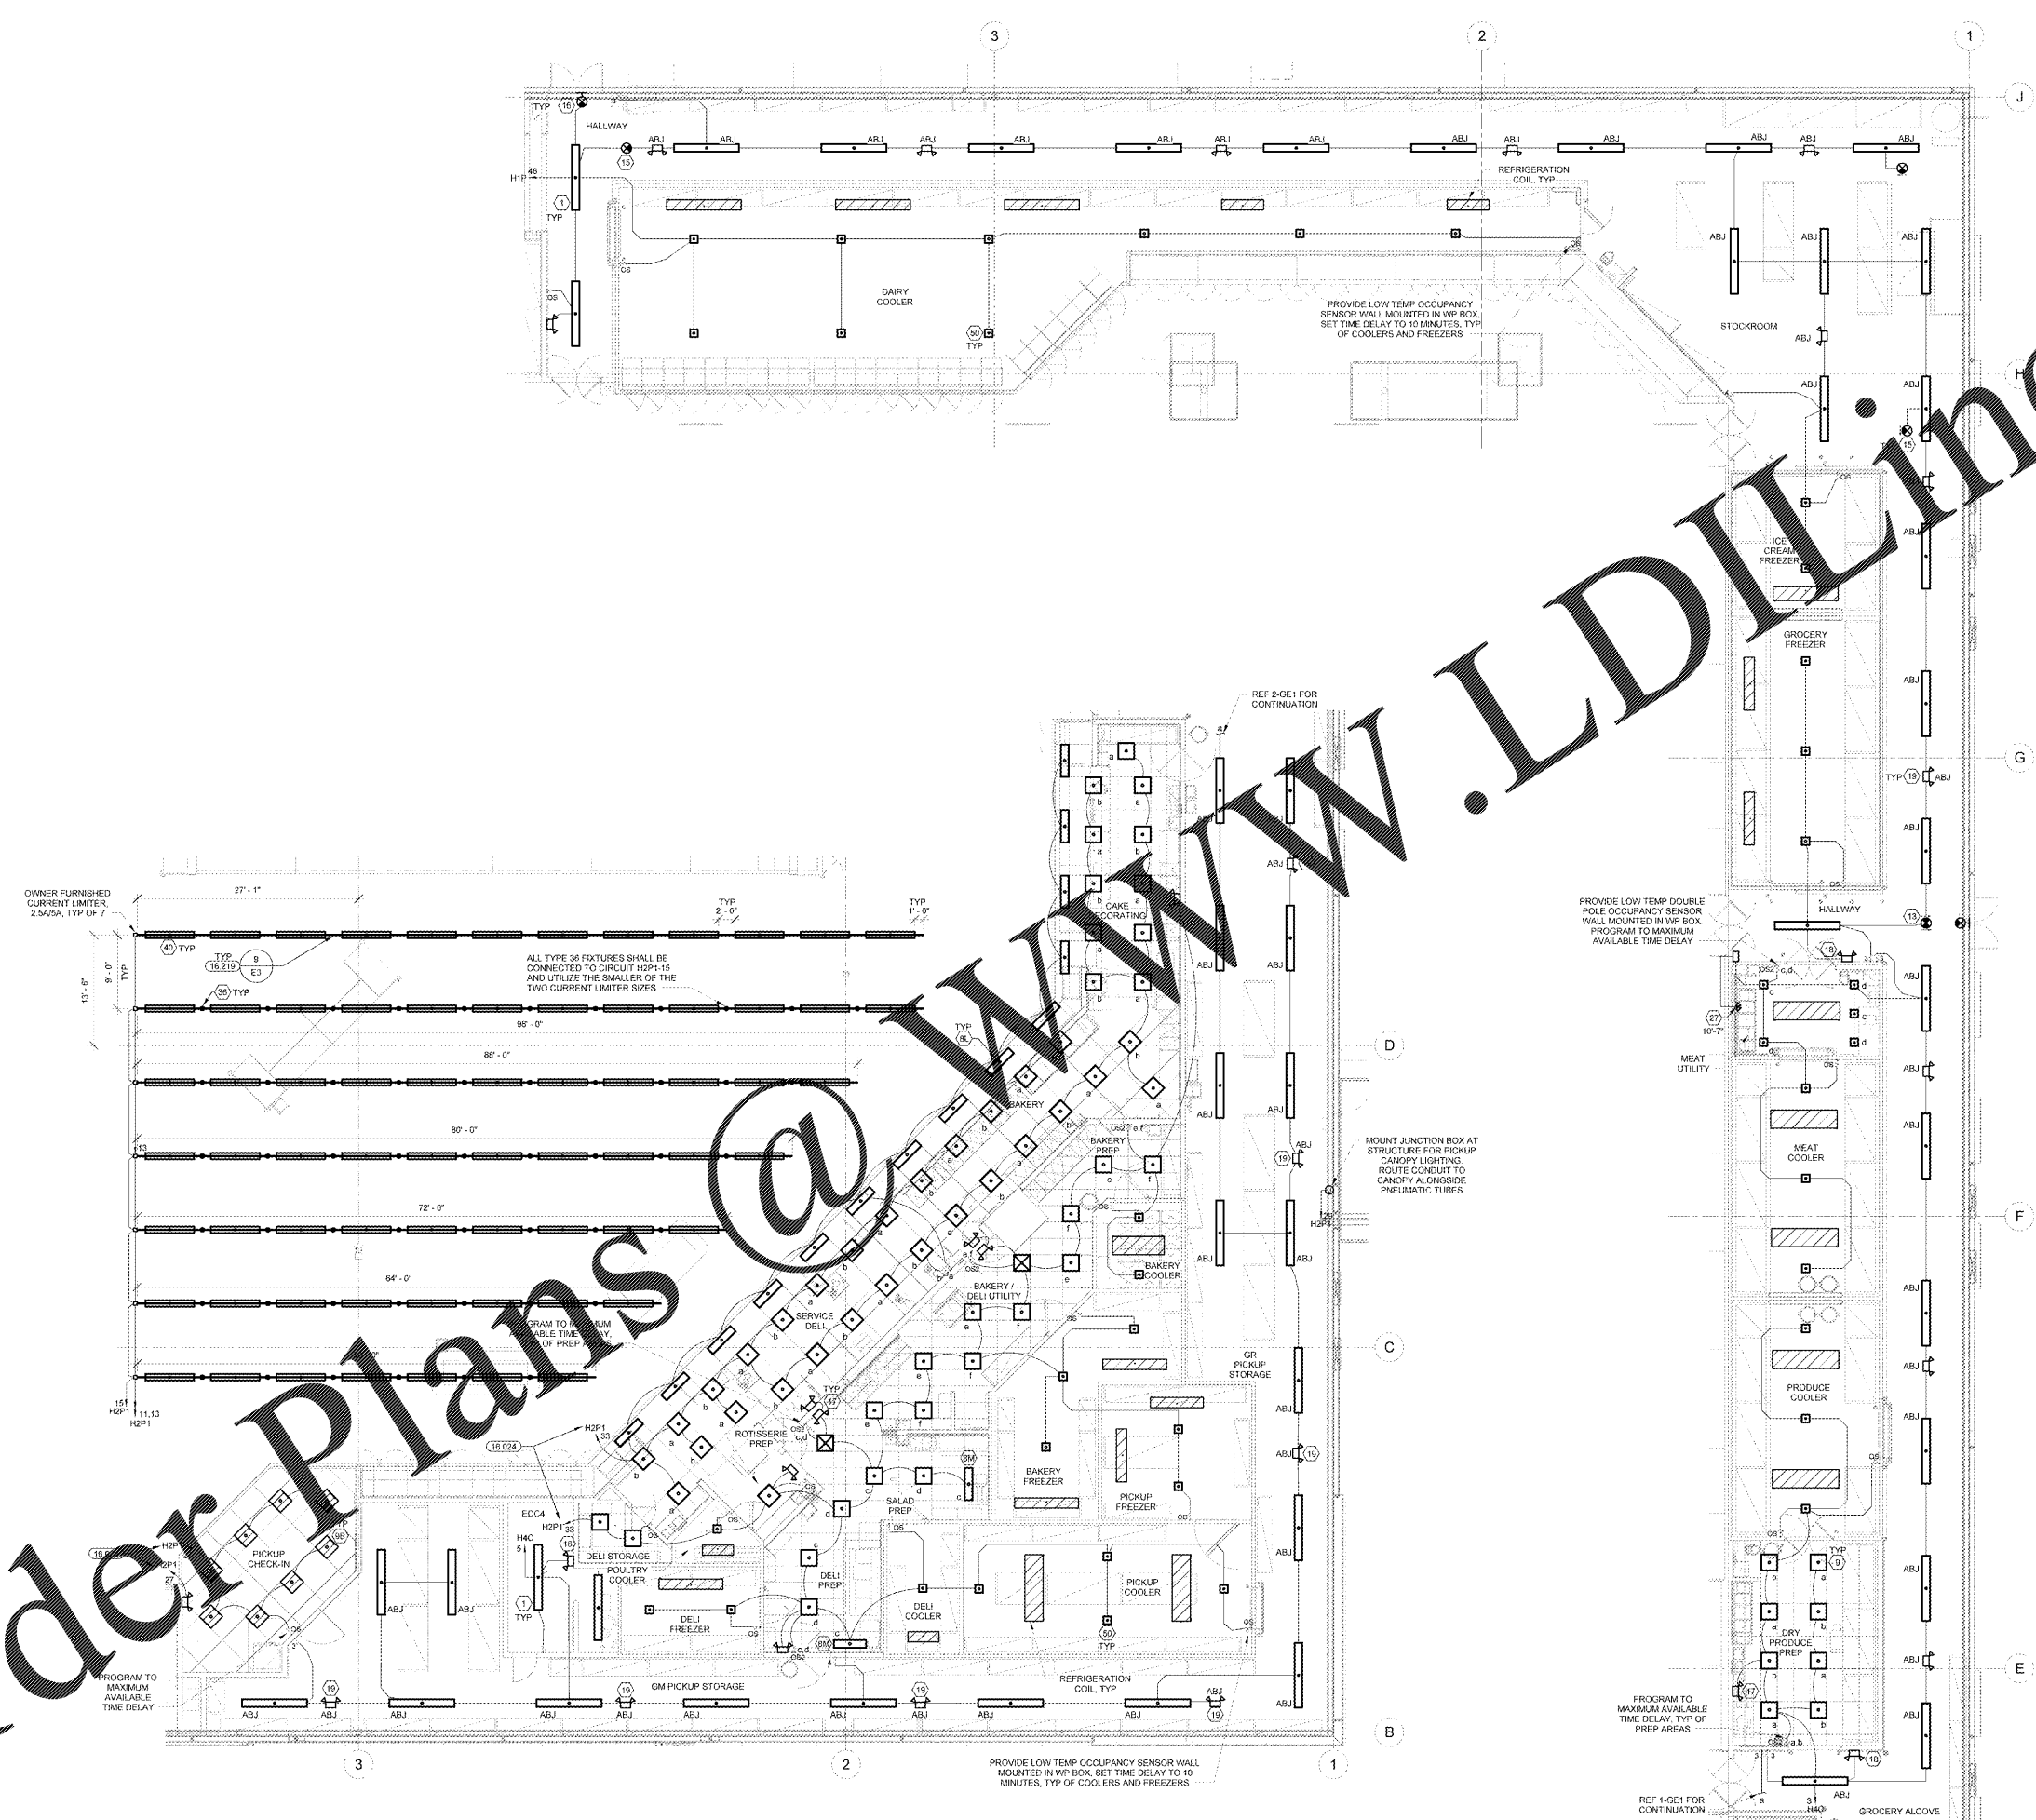

1 FRONT GROCERY LIGHTING PLAN
 1/8" = 1'-0"

2 REAR GROCERY LIGHTING PLAN
 1/8" = 1'-0"

Order Plans @ www.ldonline.com