


RECYCLING PROCESS NOTES:
 - GC TO CONTACT WEST ROCK. THE REQUIRED WASTE AND RECYCLE VENDOR FOR COORDINATION OF ALL NECESSARY CONSTRUCTION ROLL OFF DUMP/RETURNS.
 - WEST ROCK WILL PROVIDE STORE SPECIFIC RECYCLING REQUIREMENTS FOR EACH REGIONAL AREA.
 - GC IS RESPONSIBLE FOR NECESSARY SEPARATION AND SORTING OF RECYCLABLES AS REQUIRED AND INSTRUCTED BY WEST ROCK.

NOTE:
 GC TO PARTNER WITH CPM FOR CONSTRUCTION RECYCLING REQUIREMENTS.

NOTE:
 GC TO FINALIZE & COORDINATE FINAL SPEAKER LOCATIONS WITH VENDOR

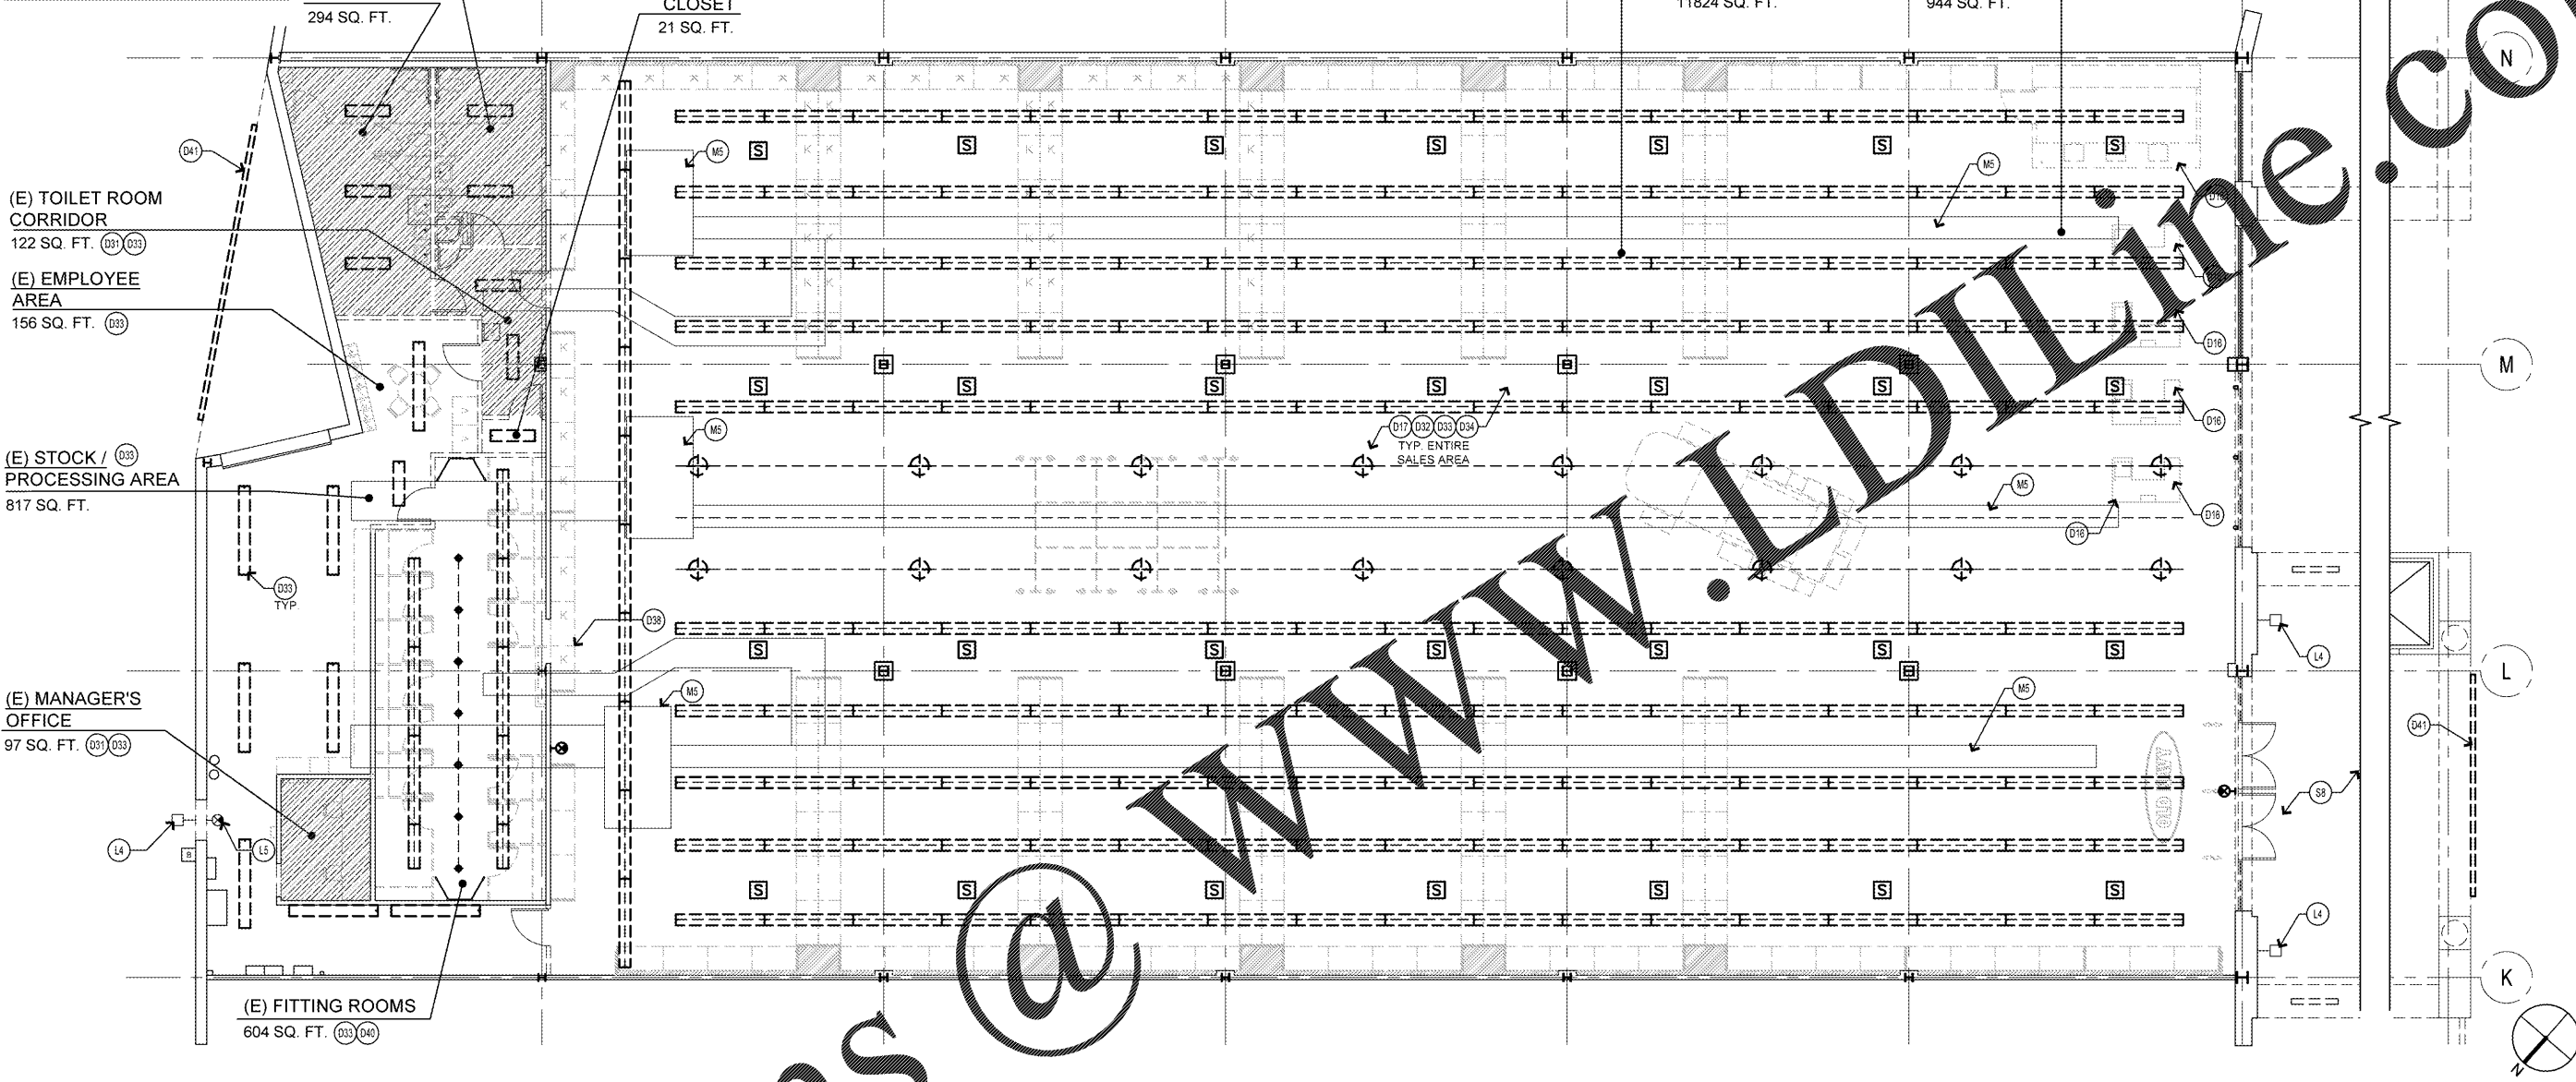

REMODEL STORE

OLD NAVY

CAPITAL DEVELOPMENT
 STORE DEVELOPMENT
 111 FRANKLIN STREET
 SAN FRANCISCO, CA 94105

REPS. I.D.: 00000131847
 STORE NUMBER: 5724
 STORE LOCATION: BUCKHEAD STATION
 1 BUCKHEAD LOOP NE
 ATLANTA, GA 30326

DESIGN TYPE: P3
 GENERATION: 18012
 PROTOTYPE DATE: 08/31/17
 OPENING DATE: 2018

CONSULTANT INFO:

PROFESSIONAL STAMP:


ARCHITECT INFO:
brr
 ARCHITECT OF RECORD:
 BOYD W. RAY
 6709 ANTIPOCH PLAZA
 SUITE 300
 METairie, LA 70004
 www.brrarch.com
 TEL: 513-262-9095
 FAX: 513-262-9044

ISSUE TYPE:
 BID/PERMIT 01/05/18

DEMO REFLECTED CEILING PLAN

SCALE 1
 1/8" = 1'-0"

KEY	DESCRIPTION	SYM.	KEY DESCRIPTION	SYM.	KEY DESCRIPTION	SYM.
SHELL						
(S8)	(E) EXTERIOR BREEZEWAY				MECHANICAL / PLUMBING	
					(M5)	(E) HVAC DUCTWORK REFERENCE MECH. SHEETS FOR SCOPE OF WORK
DEMOLITION						
(D0)	NO RCP DEMOLITION WORK IN THIS AREA		(L1)	REMOVE & DISPOSE OF (E) EXTERIOR AWNING LIGHTING/RELMAP AND CLEAN	(M6)	REMOVE (E) SUPPLY AIR GRILLES. THE ASSOCIATED DUCT OPENINGS SHALL BE REUSED AS APPLICABLE PER NEW WORK. SEE MECH. DRAWINGS.
(D16)	REMOVE & DISPOSE OF (E) CASHWRAP POWER POLE AND SIGNAGE		(L2)	REMOVE (E) VESTIBULE FLUORESCENT LIGHTING WITH VESTIBULE MECH. LOCATION	(M7)	(E) DUCTWORK & SPRINKLER HEADS IN VESTIBULE TO BE RELOCATED TO NEW VESTIBULE LOCATION
(D17)	REMOVE AND DISPOSE OF (E) SUSPENDED SIGNAGE AND SUPPORTS. TAKE POWER BACK TO "J" BOX		(L3)	(E) EXTERIOR LIGHTING TO REMAIN	(M8)	(E) WATER HEATER TO BE REMOVED - REFER TO PLBG SHEETS
(D18)	REMOVE & DISPOSE OF (E) RELAYING PANS & SUPPORTS. TAKE POWER BACK TO "J" BOX		(L4)	(E) ILLUMINATED EXIT SIGN TO REMAIN		
(D19)	REMOVE & DISPOSE OF (E) POWER STRUT SUPPORTS & BRACKETS. TAKE POWER AS AT MAINS/FREEL		(L5)	(E) ILLUMINATED EXIT SIGN TO REMAIN		
(D21)	REMOVE & DISPOSE OF (E) CEILING		(L6)	(E) FLUORESCENT LIGHT FIXTURES TO REMAIN. CLEAN & REPAIR AS NECESSARY		
(D32)	REMOVE & DISPOSE OF (E) INSTRUMENT SUPPORTS & MOUNTING BRACKETS		(L7)	REMOVE AND SALVAGE (E) FLUORESCENT LIGHT FIXTURES. RELOCATE PER SHEET PL-11. SEE SYMBOLS LEGEND FOR FIXTURE POINTS		
(D33)	REMOVE & DISPOSE OF (E) LIGHT FIXTURES. TAKE POWER BACK TO J-BOX		(L8)	(E) EXTERIOR LIGHTING CENTERED ABOVE DOOR. TO BE RELOCATED		
(D34)	REMOVE & DISPOSE OF (E) BREAKERS		(L9)	(E) EXTERIOR LIGHTING CENTERED ABOVE DOOR. TO BE RELOCATED		
(D38)	REMOVE & DISPOSE OF (E) FITTING ROOM WAYFINDING SIGNAGE & PIPE SUPPORTS		(L10)	(E) PEOPLE COUNTING TO REMAIN		
(D40)	REMOVE AND DISPOSE OF (E) FITTING ROOM SUSPENDED CEILING ELEMENT AND SUPPORTS		(L11)	(E) ILLUMINATED EXIT SIGN TO BE RELOCATED		
			(L12)	(E) MUSIC SPEAKER TO BE RELOCATED. GC TO COORDINATE WITH VENDOR		
			(L13)	(E) MUSIC SPEAKER TO REMAIN. GC TO COORDINATE WITH VENDOR		

 

DEMO RCP KEY NOTES

REVISIONS:

DRAWN BY: CAR
 A/E JOB NUMBER: 65013029

TITLE SHEET:
 DEMO REFLECTED
 CEILING PLAN

SHEET NUMBER:
D1-1