

NOTE TO CONTRACTOR:  
SEE "GENERAL SHEETS" IN THIS SET FOR  
RESPONSIBILITY MATRIX ITEMS AND REFER TO  
SPECIFICATION BOOK FOR GENERAL NOTES.

CHANGES TO THE DESIGN OF ANY SYSTEM IDENTIFIED ON  
THESE DRAWINGS OR SPECIFICATIONS SHALL BE SUBMITTED  
TO THE ENGINEER OF RECORD FOR REVIEW AND APPROVAL  
PRIOR TO THE FABRICATION AND INSTALLATION. ANY  
MODIFICATIONS WITHOUT THE ORIGINATING ENGINEER'S  
WRITTEN AUTHORIZATION AND APPROVAL SHALL BE THE  
RESPONSIBILITY, AS WELL AS THE COST TO CORRECT SUCH  
MODIFICATION, OF THE CONTRACTOR.

| EXISTING CONDENSATE LIFT STATION SCHEDULE |        |         |         |          |           |     |       |     |      |       |         |
|---|--------|---------|---------|----------|-----------|-----|-------|-----|------|-------|---------|
| TAG                                       |        |         |         |          | PUMP      |     |       |     |      |       |         |
| ITEM                                      | SYSTEM | SERVICE | MFR.    | MODEL    | HEAD (FT) | GPH | VOLTS | PH. | AMPS | WATTS | REMARKS |
| (E)CP-1                                   | AHU-1  | COND    | HARTELL | A2X-1965 | 12        | 240 | 120   | 1   | 3.5  | 420   | 1, 2    |
| (E)CP-2                                   | AHU-2  | COND    | HARTELL | A2X-1965 | 12        | 240 | 120   | 1   | 3.5  | 420   | 1, 2    |
| (E)CP-3                                   | AHU-3  | COND    | HARTELL | A2X-1965 | 12        | 240 | 120   | 1   | 3.5  | 420   | 1, 2    |

REMARKS:  
1. PUMP TO BE POWERED FROM NEAREST 120V CKT HARDWIRED AT J-BOX W/ MOTOR RATED SW.  
2. ENSURE WORKING CONDITION, REPLACE AS REQUIRED.


**PLUMBING GENERAL NOTES**

1. THE ABBREVIATION G.C., WHEREVER IT APPEARS IN THESE PLUMBING DRAWINGS, SHALL REFER TO THE GENERAL CONTRACTOR.
2. THE CONTRACTOR FOR THIS DIVISION OF WORK IS REQUIRED TO READ THE SPECIFICATIONS AND REVIEW DRAWINGS FOR ALL DIVISIONS OF WORK AND IS RESPONSIBLE FOR THE COORDINATION OF THIS WORK AND THE WORK OF ALL SUBCONTRACTORS WITH ALL DIVISIONS OF WORK. IT IS THE CONTRACTOR'S RESPONSIBILITY TO PROVIDE ALL SUB-CONTRACTORS WITH A COMPLETE SET OF BID DOCUMENTS.
3. ALL ROOF CUTTING, PATCHING AND FLASHING REQUIRED TO INSTALL THE PLUMBING SYSTEMS SHALL BE BY A LANDLORD APPROVED ROOFING CONTRACTOR. COORDINATE ROOF PENETRATIONS WITH LANDLORD AND G.C.
4. ALL PLUMBING FIXTURES SHALL BE INSTALLED WITH STOP VALVES TO ISOLATE EACH FIXTURE. REFER TO RISER DIAGRAM AND PLUMBING SPECIFICATIONS FOR ADDITIONAL REQUIREMENTS.
5. ALL SHUT-OFF VALVES LOCATED IN AREAS WITH HARD CEILINGS SHALL HAVE ACCESS PANELS INSTALLED. COORDINATE LOCATION AND TYPE WITH G.C. AND ARCHITECT.
6. CONTRACTOR TO VERIFY THAT ALL ITEMS ON THE CONTRACTOR CHECKLIST ARE COMPLETED PRIOR TO MEP COMMISSIONING. CONTRACTOR WILL RECEIVE CONTRACTOR CHECKLIST IN ELECTRONIC FORM WITH BID DOCUMENTS.

**PLUMBING SYMBOLS LEGEND**

- COLD WATER (CW)
- D- CONDENSATE LINE (D)
- F- FIRE PROTECTION (F) (SPRINKLER/STANDPIPE)
- G- GAS LINE (G)
- H- HOT WATER (HW)
- V- PLUMBING VENT (V)
- S- SANITARY WASTE (SAN) - BELOW SLAB/GRADE
- A- ABOVE FINISHED FLOOR/GRADE
- B- BACKFLOW PREVENTER
- C- CHECK VALVE
- CO- CLEANOUT
- E- CONNECT TO EXISTING
- EX- EXISTING
- FCO- FLOOR CLEAN OUT
- FD- FLOOR DRAIN (FD)
- FS- FLOOR SINK (FS)
- TU- PIPE TURNING UP/DOWN
- RD- REDUCER
- TV- SHUTOFF VALVE (BALL TYPE)
- TU- TEE TURNING UP/DOWN
- LL- LANDLORD
- TP- TRAP PRIMER
- VTR- VENT THRU ROOF
- WHA- WATER HAMMER ARRESTOR
- WCO- WALL CLEAN OUT

**RESPONSIBILITY MATRIX LEGEND**

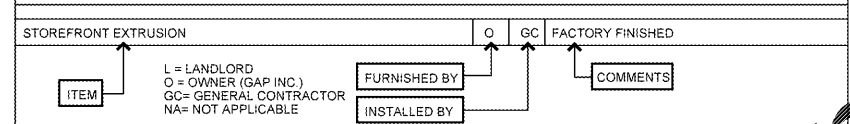

**RESPONSIBILITY MATRIX**

| ITEM   | FURNISHED BY | INSTALLED BY | COMMENT       |
|--|--------------|--------------|---------------|
| WATER LINE TO LEASE SPACE  | E            | E            |               |
| SEWER LINE TO LEASE SPACE  | E            | E            |               |
| RTU CONDENSATE DRAIN CONNECTIONS, TRAPS AND PIPING                                   | GC           | GC           | EXTEND NEW MS |
| GAS METER AND MAIN SHUT-OFF VALVE  | NA           | NA           |               |
| WATER METER  | E            | E            |               |
| GAS PIPING WITH SUPPORTS, DIRT LEGS AND INDIVIDUAL SHUT-OFF VALVES TO EACH HVAC UNIT |              | NA           |               |

REMARKS:  
NOTE:  
1. THE RESPONSIBILITY MATRIX ONLY DELINEATES THE SUPPLIER AND/OR INSTALLED BY OWNER AND/OR LANDLORD. ANY WORK SHOWN IN THE CONSTRUCTION DOCUMENTS NOT DEFINED AS RESPONSIBILITY OF OWNER OR LANDLORD IS FURNISHED AND INSTALLED BY THE CONTRACTOR. SEE BID CLARIFICATION LETTER FOR ANY VARIATION BY SCOPE OF WORK RESPONSIBILITY.  
2. THE CONTRACTOR IS RESPONSIBLE FOR THE UNLOADING OF ANY OWNER SUPPLIED CONSTRUCTION ITEMS.

REMODEL STORE



GAP INC.  
STORE DEVELOPMENT  
FOLSOM STREET  
FRANCOIS, CA 94105

REPS. I.D.: 0000131847  
STORE NUMBER: 5724  
STORE LOCATION: BUCKHEAD STATION  
1 BUCKHEAD LOOP NE  
ATLANTA, GA 30326

DESIGN TYPE: P3  
GENERATION: 18Q12  
PROTOTYPE DATE: 08/31/17  
OPENING: 2018

CONSULTANT INFO:  
**M-Engineering**  
750 Brookside Blvd.  
Westerville, Ohio 43081  
phone: 614.539.4533  
fax: 614.839.2232  
www.mengineering-us.com

PROFESSIONAL STAMP:

ARCHITECT INFO:  
**brr**  
ARCHITECT OF RECORD:  
BOYD W. BAU  
6700 ANTIPOCH PLAZA  
SUITE 300  
MERRIAM, KS 66204  
www.brrarch.com  
TEL: 913-263-9095  
FAX: 913-262-9044

ISSUE TYPE:  
BID/PERMIT 01/05/18


REVISIONS:

| NO. | DESCRIPTION |
|-----|-------------|
|     |             |
|     |             |
|     |             |
|     |             |

DRAWN BY: RRD/JAH  
AVE JOB NUMBER: 65013029/1742070

TITLE SHEET:  
PLUMBING PLANS, NOTES,  
AND LEGENDS

SHEET NUMBER:  
P1-0

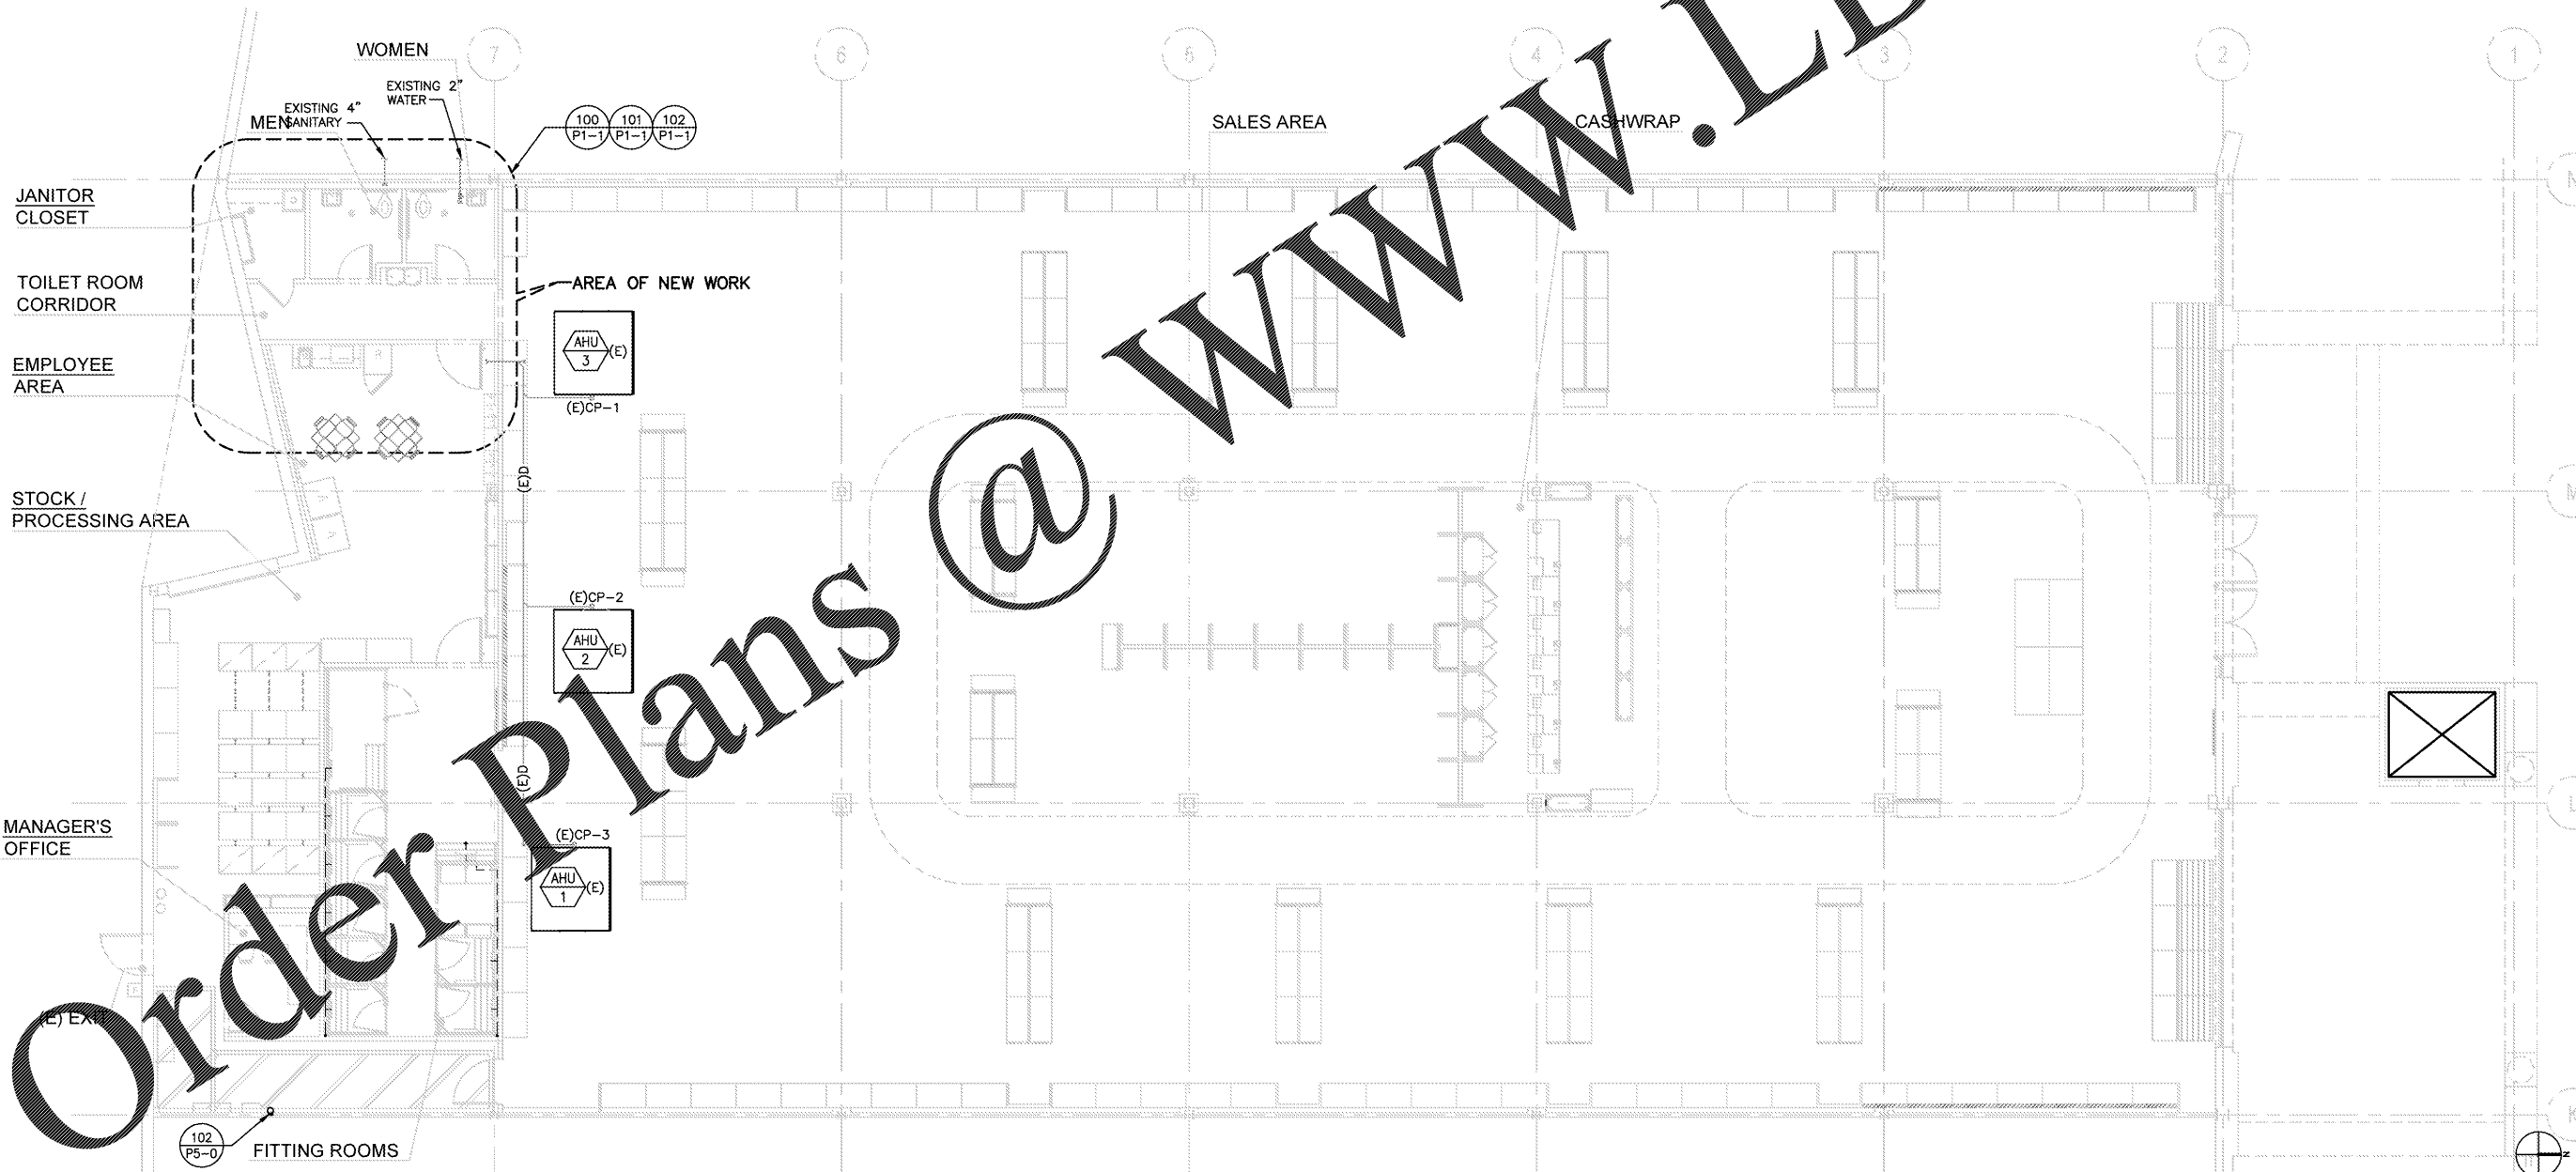

WWW.LDILINE.COM

Order Plans @