


WASTE AND VENT RISER DIAGRAM

NO SCALE
100

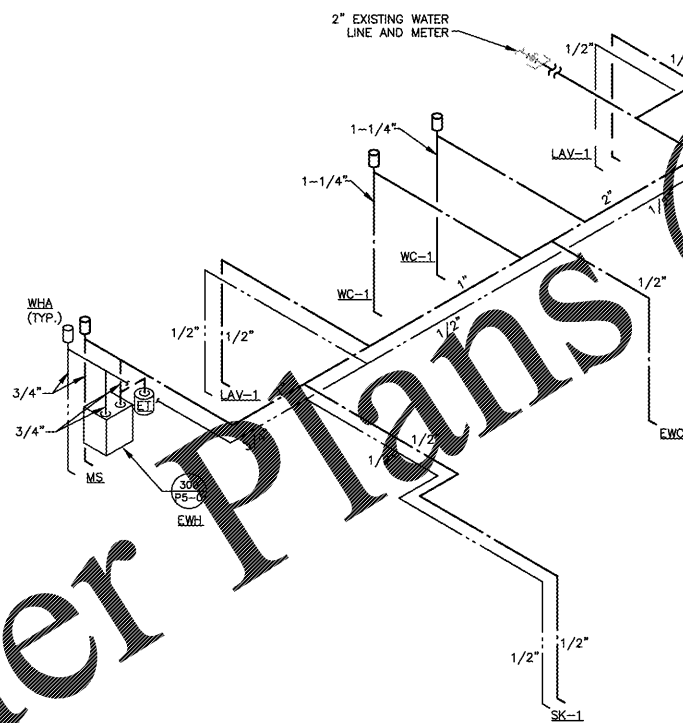


COLD WATER AND HOT WATER RISER DIAGRAM

NO SCALE
101

PLUMBING CODED NOTES

- 100 CONNECT NEW SANITARY LINE INTO THE LANDLORD'S EXISTING SANITARY SERVICE AS SHOWN. FIELD VERIFY EXACT LOCATION OF LANDLORD'S MAIN PRIOR TO BIDDING. INSTALL CLEANOUT AT CONNECTION TO LANDLORD'S MAIN AND COORDINATE LOCATION AND TYPE OF COVER REQUIRED TO MATCH FLOOR FINISH WITH G.C. REFER TO WASTE AND VENT RISER DIAGRAM AND PLUMBING SPECIFICATIONS FOR ADDITIONAL REQUIREMENTS.
- 101 CONNECT NEW VENT LINE INTO THE EXISTING VENT TAP. REFER TO WASTE AND VENT RISER DIAGRAM AND PLUMBING SPECIFICATIONS FOR ADDITIONAL REQUIREMENTS.
- 102 CONNECT NEW COLD WATER LINE INTO THE EXISTING COLD WATER TAP. NOTIFY G.C. IF TAP IS SMALLER THAN SHOWN. REFER TO COLD WATER AND HOT WATER RISER DIAGRAM AND PLUMBING SPECIFICATIONS FOR ADDITIONAL REQUIREMENTS.
- 103 PROVIDE FLOOR DRAIN WITH TRAP SEAL DEVICE (TS) PER SCHEDULE. INSTALL DEVICE PER MANUFACTURER'S INSTALLATION MANUAL.
- 104 CONNECT CONDENSATE LINE INTO THE EXISTING CONDENSATE. COORDINATE LOCATION AND SIZE OF EXISTING CONDENSATE MAIN PRIOR TO ROUGH-IN.
- 105 1-1/4" SLOPE CONDENSATE PIPING AT 1" PER 8'-0" TOWARD MOP SINK

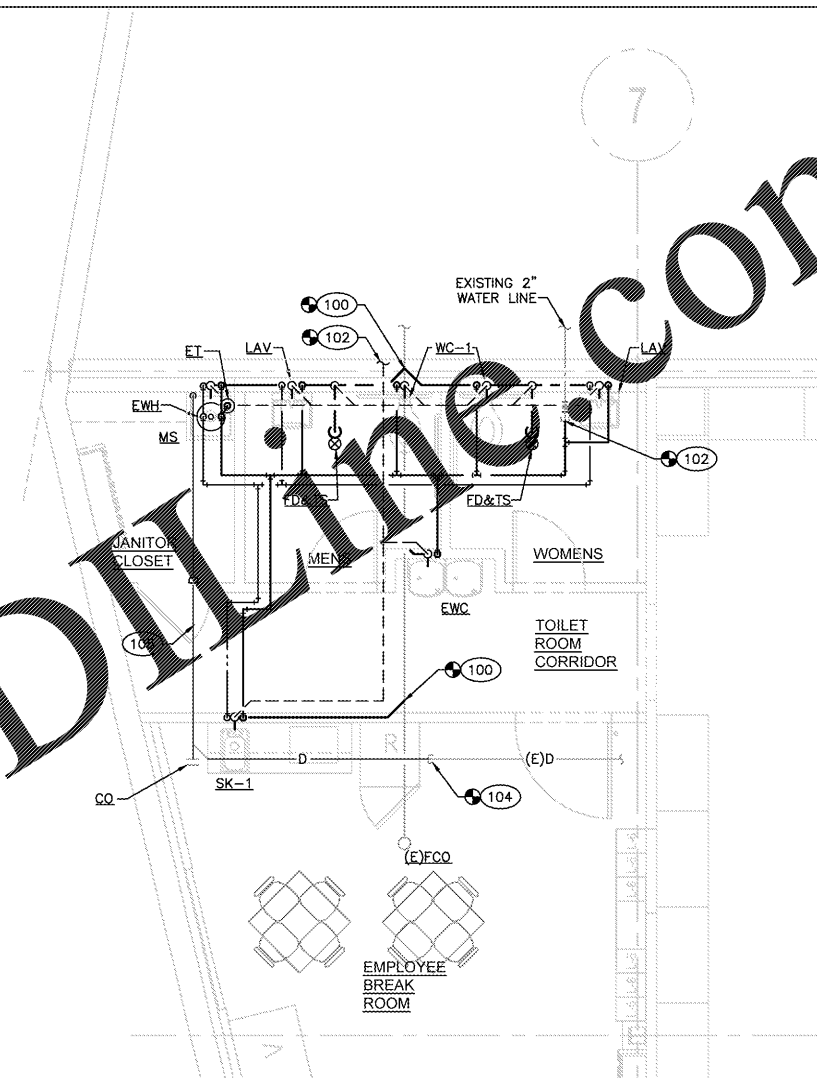

ENLARGED PLUMBING PLAN

1/4" = 1'-0"
102

REMODEL STORE

OLD NAVY

CAP INC.
STORE DEVELOPMENT
FOLSOM STREET
SAN FRANCISCO, CA 94105

REPS. I.D.:
00000131847

STORE NUMBER: **5724**
STORE LOCATION:
BUCKHEAD STATION
1 BUCKHEAD LOOP NE
ATLANTA, GA 30326

DESIGN TYPE: P3
GENERATION: 18Q12
PROTOTYPE DATE: 08/31/17
OPENING: 2018

CONSULTANT INFO.



M-Engineering
750 Brooksidge Blvd.
Westerville, Ohio 43081
phone: 614.533.4533
fax: 614.839.2222
www.m-engineering-us.com

PROFESSIONAL STAMP:

ARCHITECT INFO.



ARCHITECT OF RECORD:
BOYD W. RAU
6708 ANTOCH PLAZA
SUITE 300
MERRIAM, KS 66204
www.brrarch.com
TEL: 913-263-9095
FAX: 913-262-9044

ISSUE TYPE:

BID/PERMIT 01/05/18

REVISIONS:

DRAWN BY: RRD/JAH

A/E JOB NUMBER: 65013029/1742070

TITLE SHEET:
PLUMBING PLANS, RISERS,
AND SCHEDULES

SHEET NUMBER:

P1-1

Order Plans @ WWW.LDPLUMBING.COM