



DEVELOPMENT
STORE DEVELOPMENT
FOLSOM STREET
SAN FRANCISCO, CA 94105

REPS. I.D.:
00000131847

STORE NUMBER:
5724
STORE LOCATION:
BUCKHEAD STATION
1 BUCKHEAD LOOP NE
ATLANTA, GA 30326

DESIGN TYPE: P3
GENERATION: 18012
PROTOTYPE DATE: 08/31/17
OPENING: 2018

CONSULTANT INFO:

M-Engineering
750 Brookside Blvd.
Westerville, Ohio 43081
phone: 614.939.4039
fax: 614.939.2222
www.mengineering.us.com

PROFESSIONAL STAMP:

ARCHITECT INFO:

ARCHITECT OF RECORD:
BOYD W. RAU
6700 ANTOCH PLAZA
SUITE 300
MEMPHIS, TN 38124
www.brrarch.com
TEL: 913-262-9095
FAX: 913-262-9044

ISSUE TYPE:

BID/PERMIT 01/05/18


REVISIONS:

DRAWN BY: AMH
AVE JOB NUMBER: 65013029/1742070

TITLE SHEET:
ELECTRICAL DETAILS

SHEET NUMBER:

E9-5

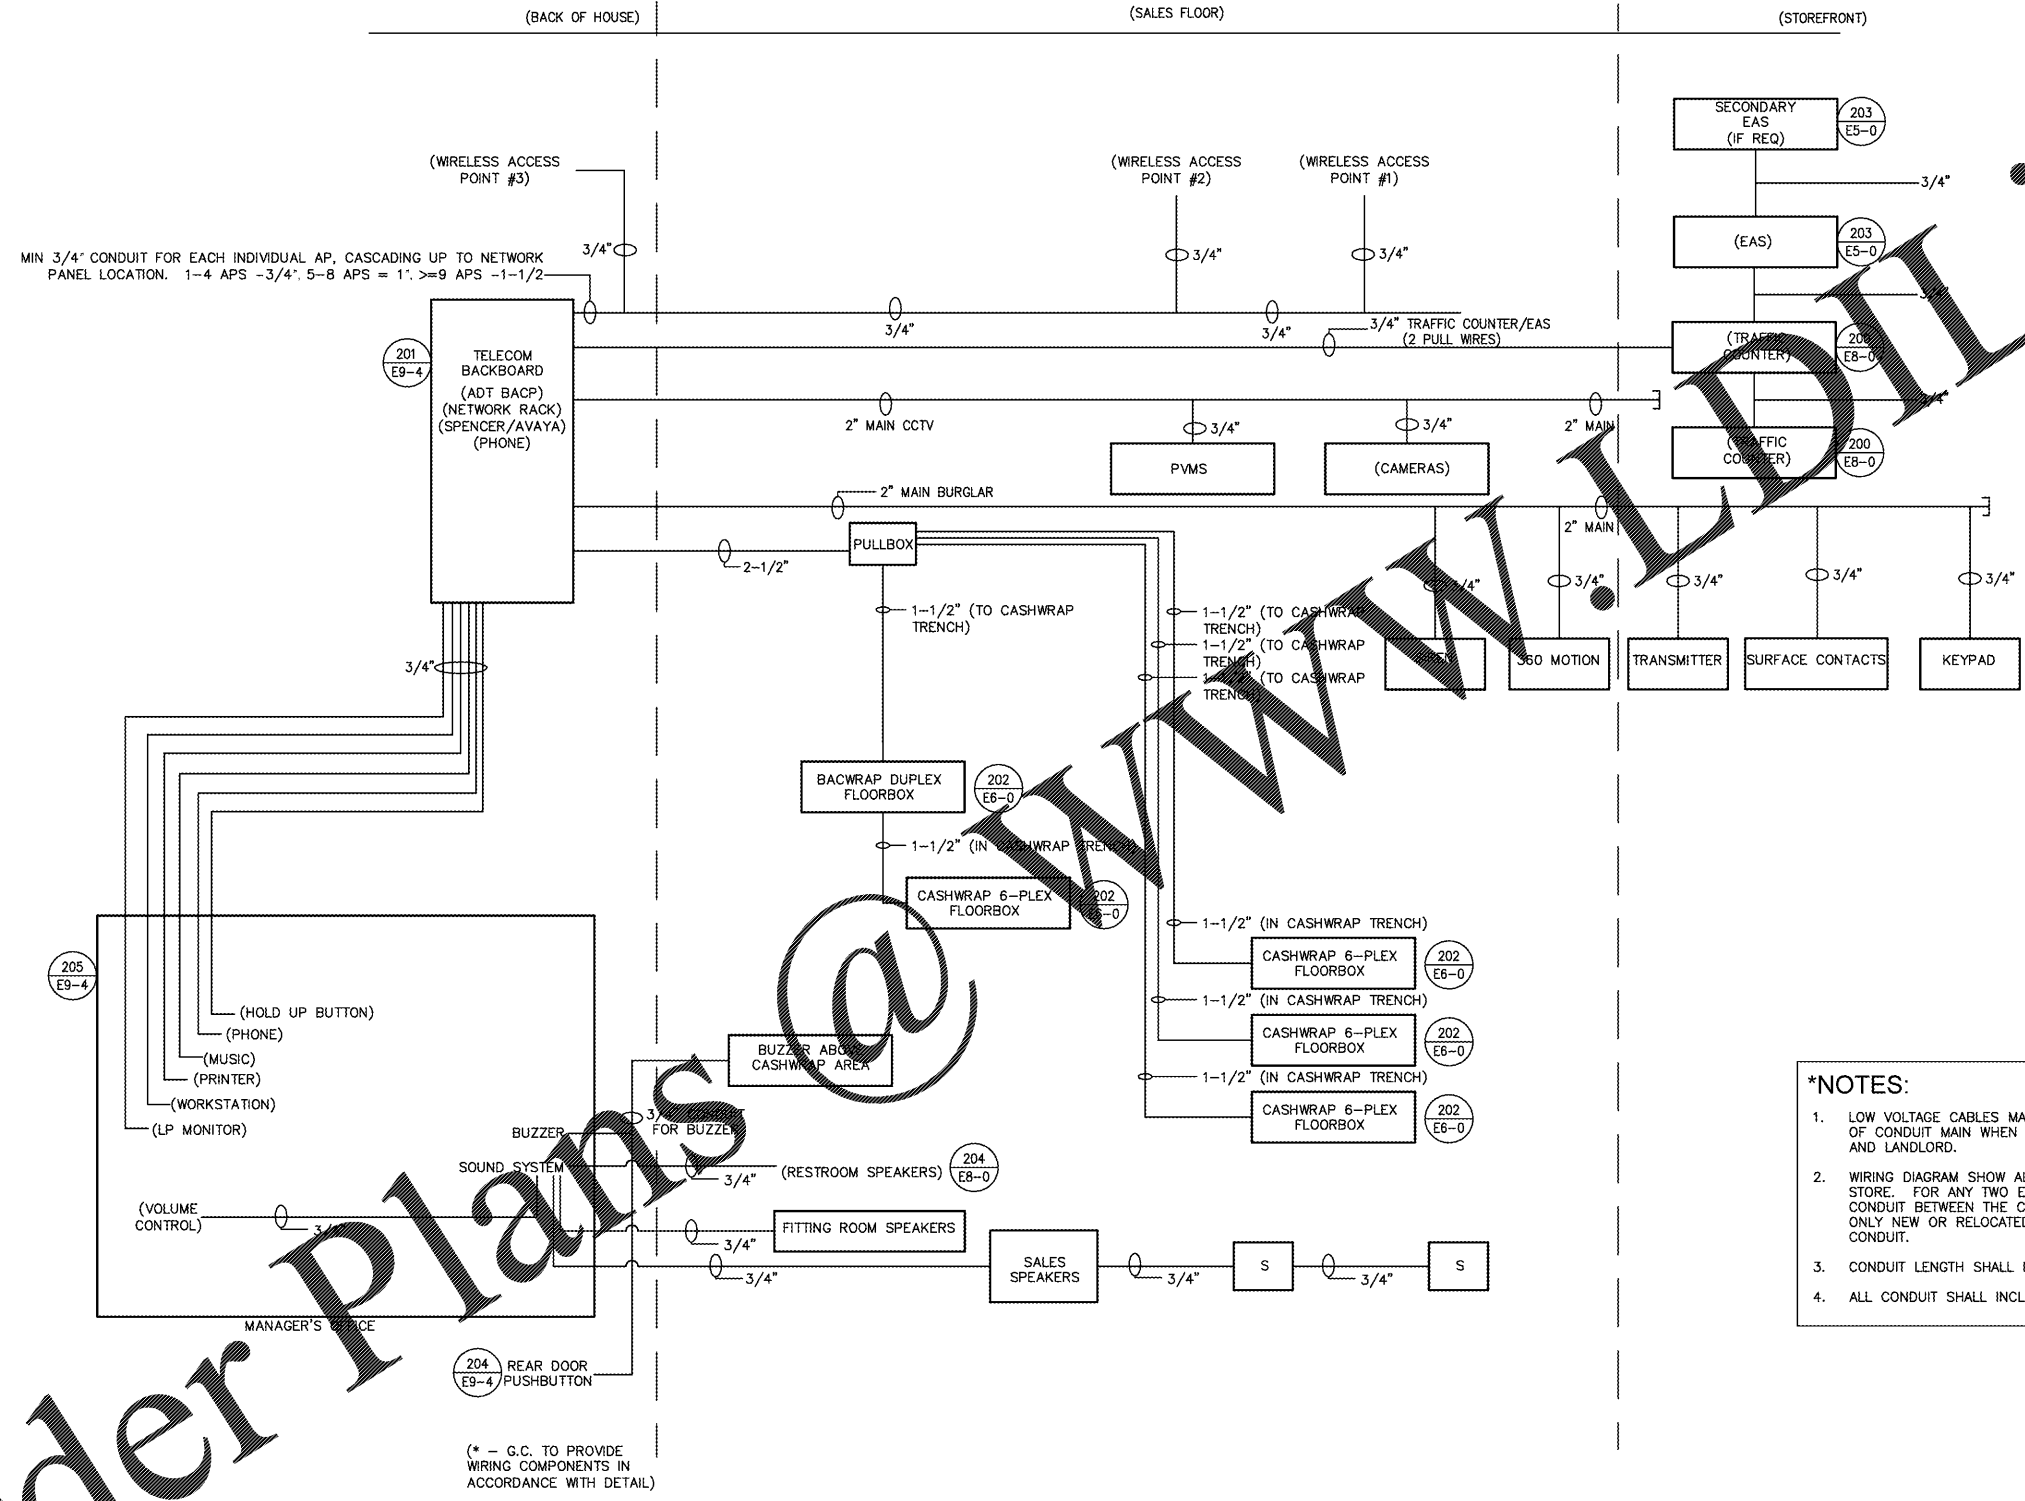

- *NOTES:**
1. LOW VOLTAGE CABLES MAY BE RUN IN CABLE TRAY IN LIEU OF CONDUIT MAIN WHEN PERMITTED BY LOCAL AUTHORITIES AND LANDLORD.
 2. WIRING DIAGRAM SHOW ALL COMPONENTS FOR A NEW STORE. FOR ANY TWO EXISTING COMPONENTS, THE CONDUIT BETWEEN THE COMPONENTS WILL REMAIN AS IS. ONLY NEW OR RELOCATED COMPONENTS REQUIRE NEW CONDUIT.
 3. CONDUIT LENGTH SHALL NOT EXCEED 300 FT.
 4. ALL CONDUIT SHALL INCLUDE A PULLSTRING.

Order Plans