


KEYNOTES: 1

1. LIGHT FIXTURE TYPE "B" IN CEILING OF ICE DISPENSER ALCOVE, SEE ELECTRICAL DRAWINGS.
2. NEW SIGNAGE BOX, SEE DETAIL 10 FOR MORE INFORMATION.

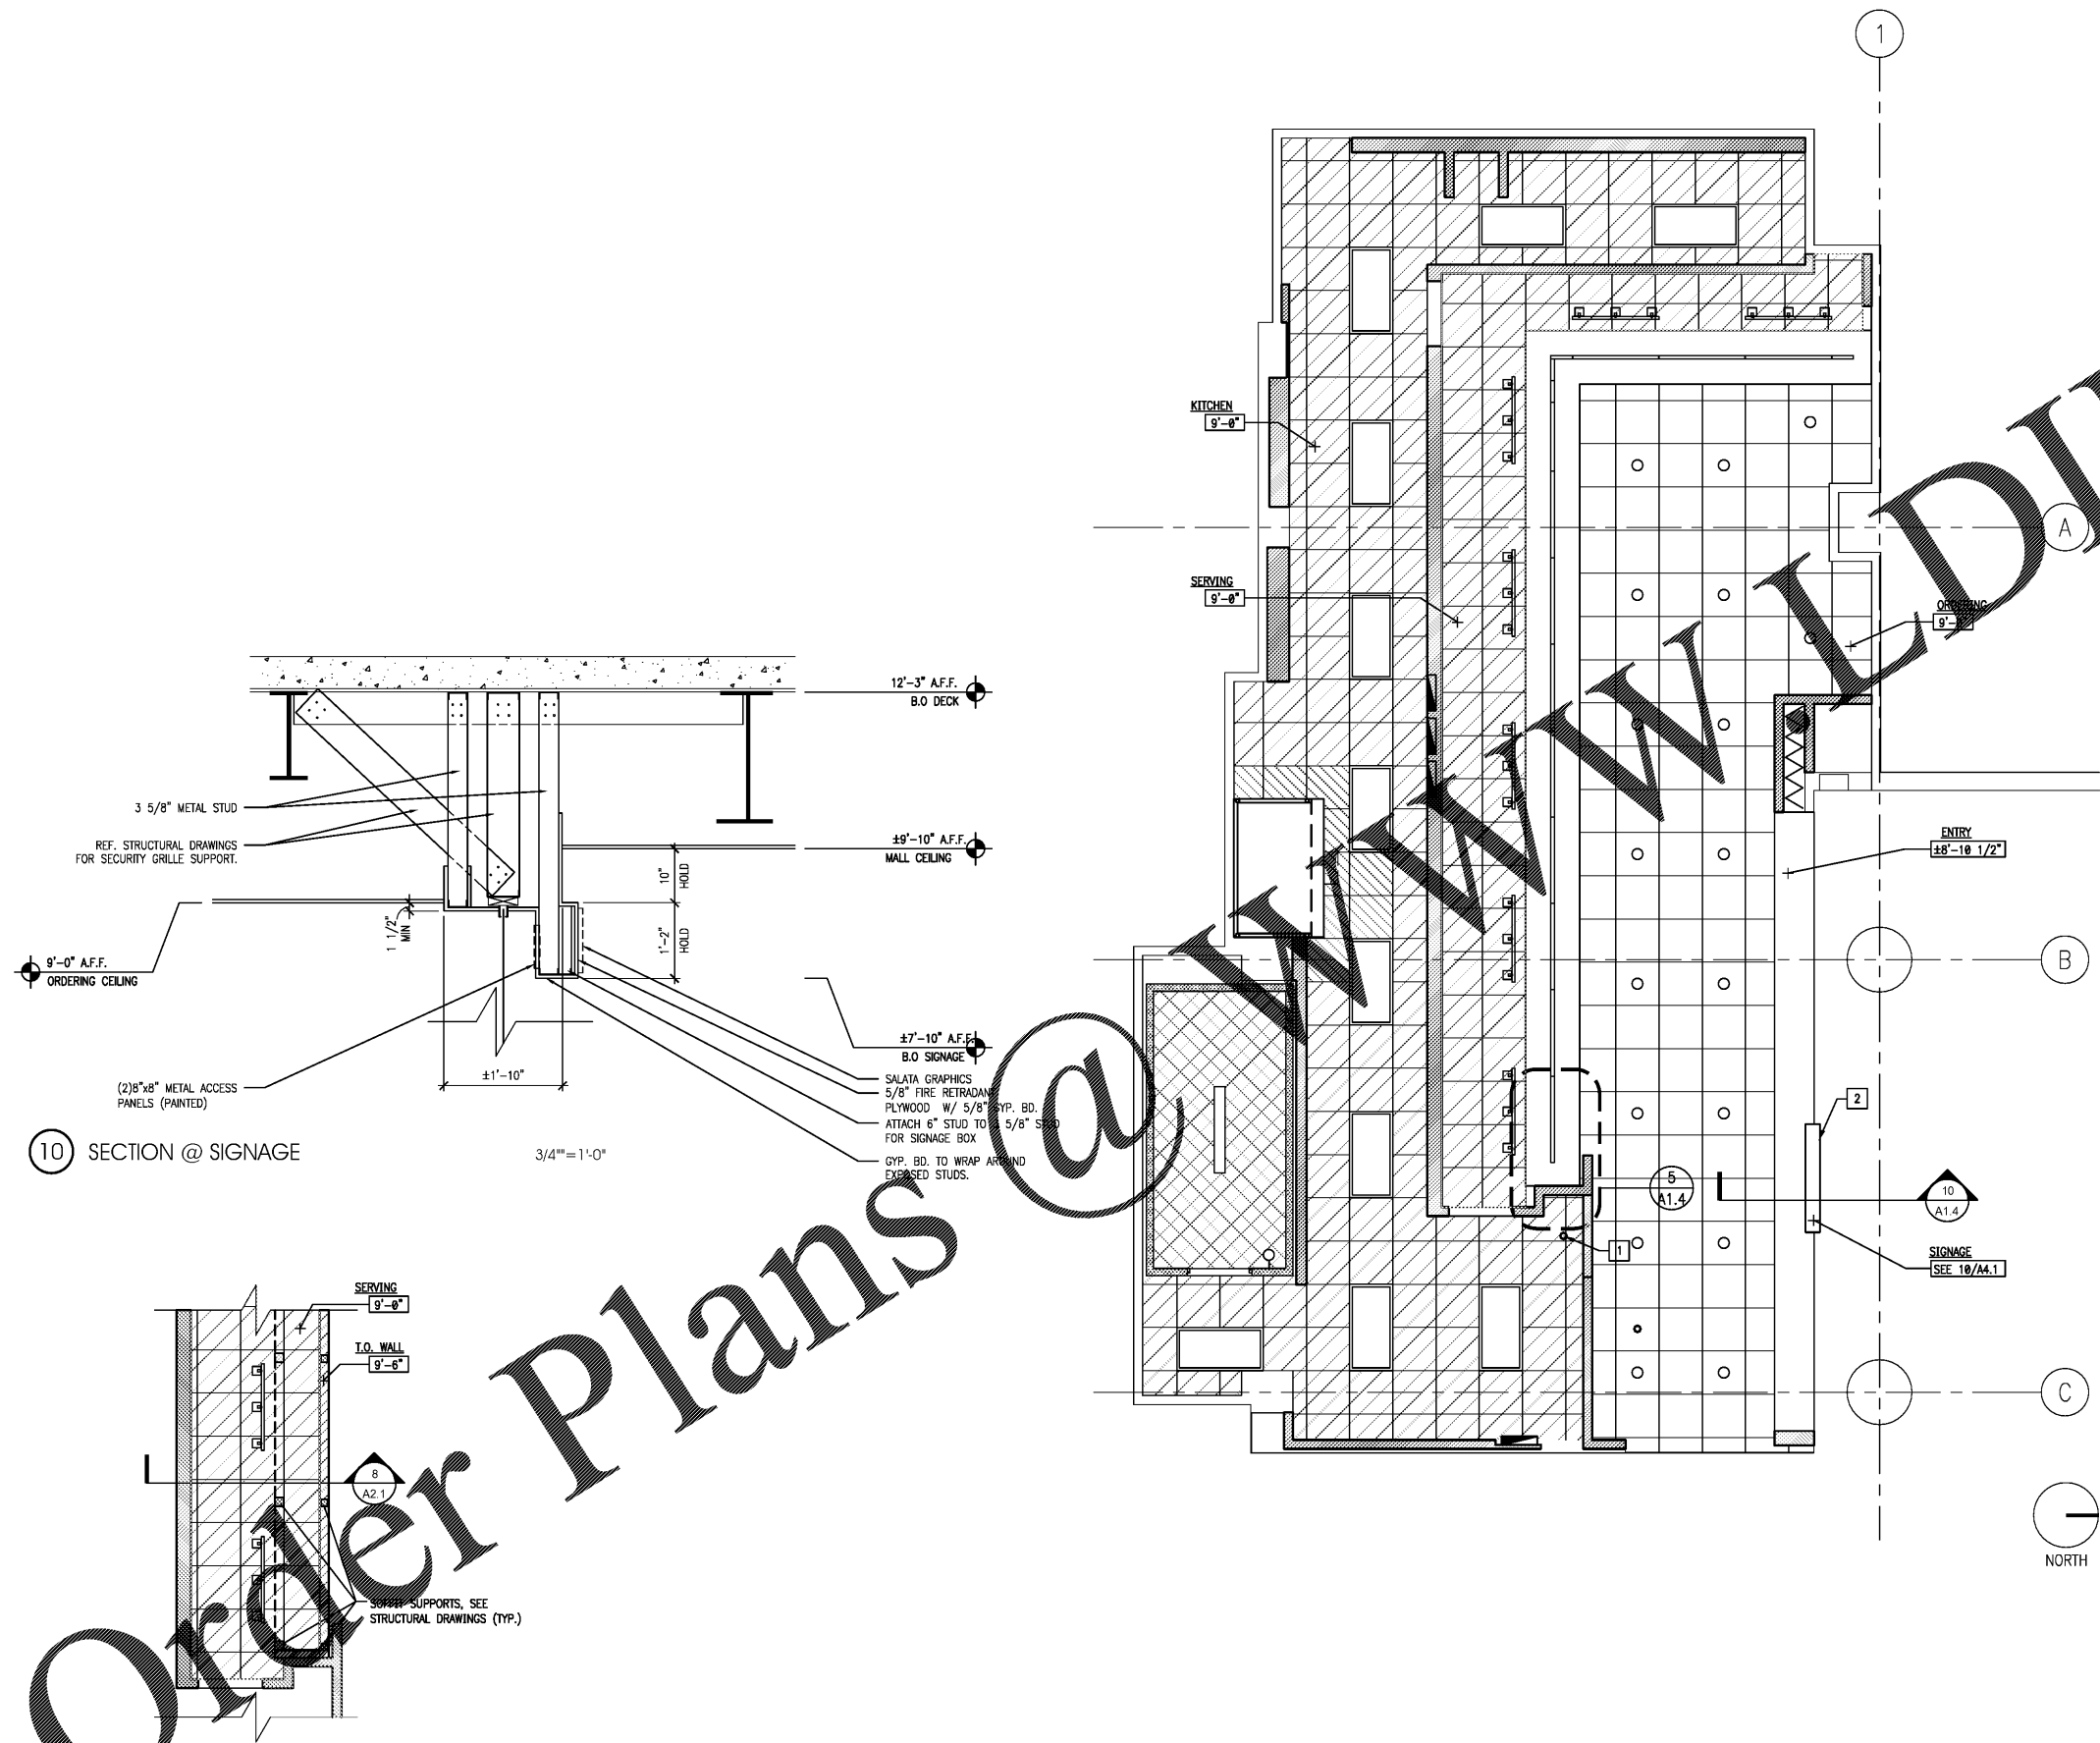

10 SECTION @ SIGNAGE

5 REFLECTED CEILING PLAN @ SOFFIT CUBICLES

REFLECTED CEILING PLAN

SCALE: 1/4" = 1'-0"

REFLECTED CEILING PLAN LEGEND:

- 2X4 LED LIGHT FIXTURE WITH PROTECTIVE LENS COVER
- EXTERIOR EGRESS LIGHT 90 MINUTE BATTERY BACKUP
- RECESSED LED CAN LIGHT FIXTURE CENTER IN TILE U.N.O.
- RECESSED LED CAN LIGHT WITH PROTECTIVE LENS COVER
- TRACK LIGHT FIXTURE WITH LENS COVERS
- LED RECESSED STRIP LIGHT
- POINT ELEVATION ABOVE FINISH FLOOR
- 2X2 CEILING GRID AND TILE (SEE SHEET A1.3 FOR SPECIFICATIONS)
- 2X2 CEILING GRID AND TILE - VINYL FACED (SEE SHEET A1.3 FOR SPECIFICATIONS)
- BY COOLER MANUFACTURER
- STAINLESS STEEL CEILING TILE
- EMERGENCY/EGRESS LIGHT FIXTURE
- EMERGENCY/EGRESS LIGHT FIXTURE W/ EXIT SIGN
- SPEAKER BY SALATA
- SECURITY CAMERA BY SALATA

NO.	DATE	REVISIONS
2	01.04.18	ISSUED/RELEASED FOR CONSTRUCTION
1	12.28.17	LANDLORD COMMENTS
		NO. DATE REMARKS

Salata
PEACHTREE CENTER MALL
 231 PEACHTREE ST. NE SUITE B14
 ATLANTA, GA 30303

PROJECT NO: 2017.0221
 DATE: 12.08.2017

A1.4
 REFLECTED CEILING PLAN

CHECKED: MP DRAWN: RS