




REVISIONS	
#	DATE

A
NEW TOWN
HALL FOR:

THE TOWN OF
NORTH
HIGH
SHOALS

260 HILLSBORO
ROAD

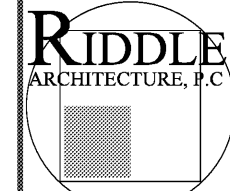


AMERICAN
INSTITUTE
OF
ARCHITECTS

1481 HODGES MILL ROAD
BOGART, GA
30622
(404) 285-8646

TITLE: MECHANICAL
PLAN


JOB #: 1510
DATE: 11.17.17

SHEET #
M1

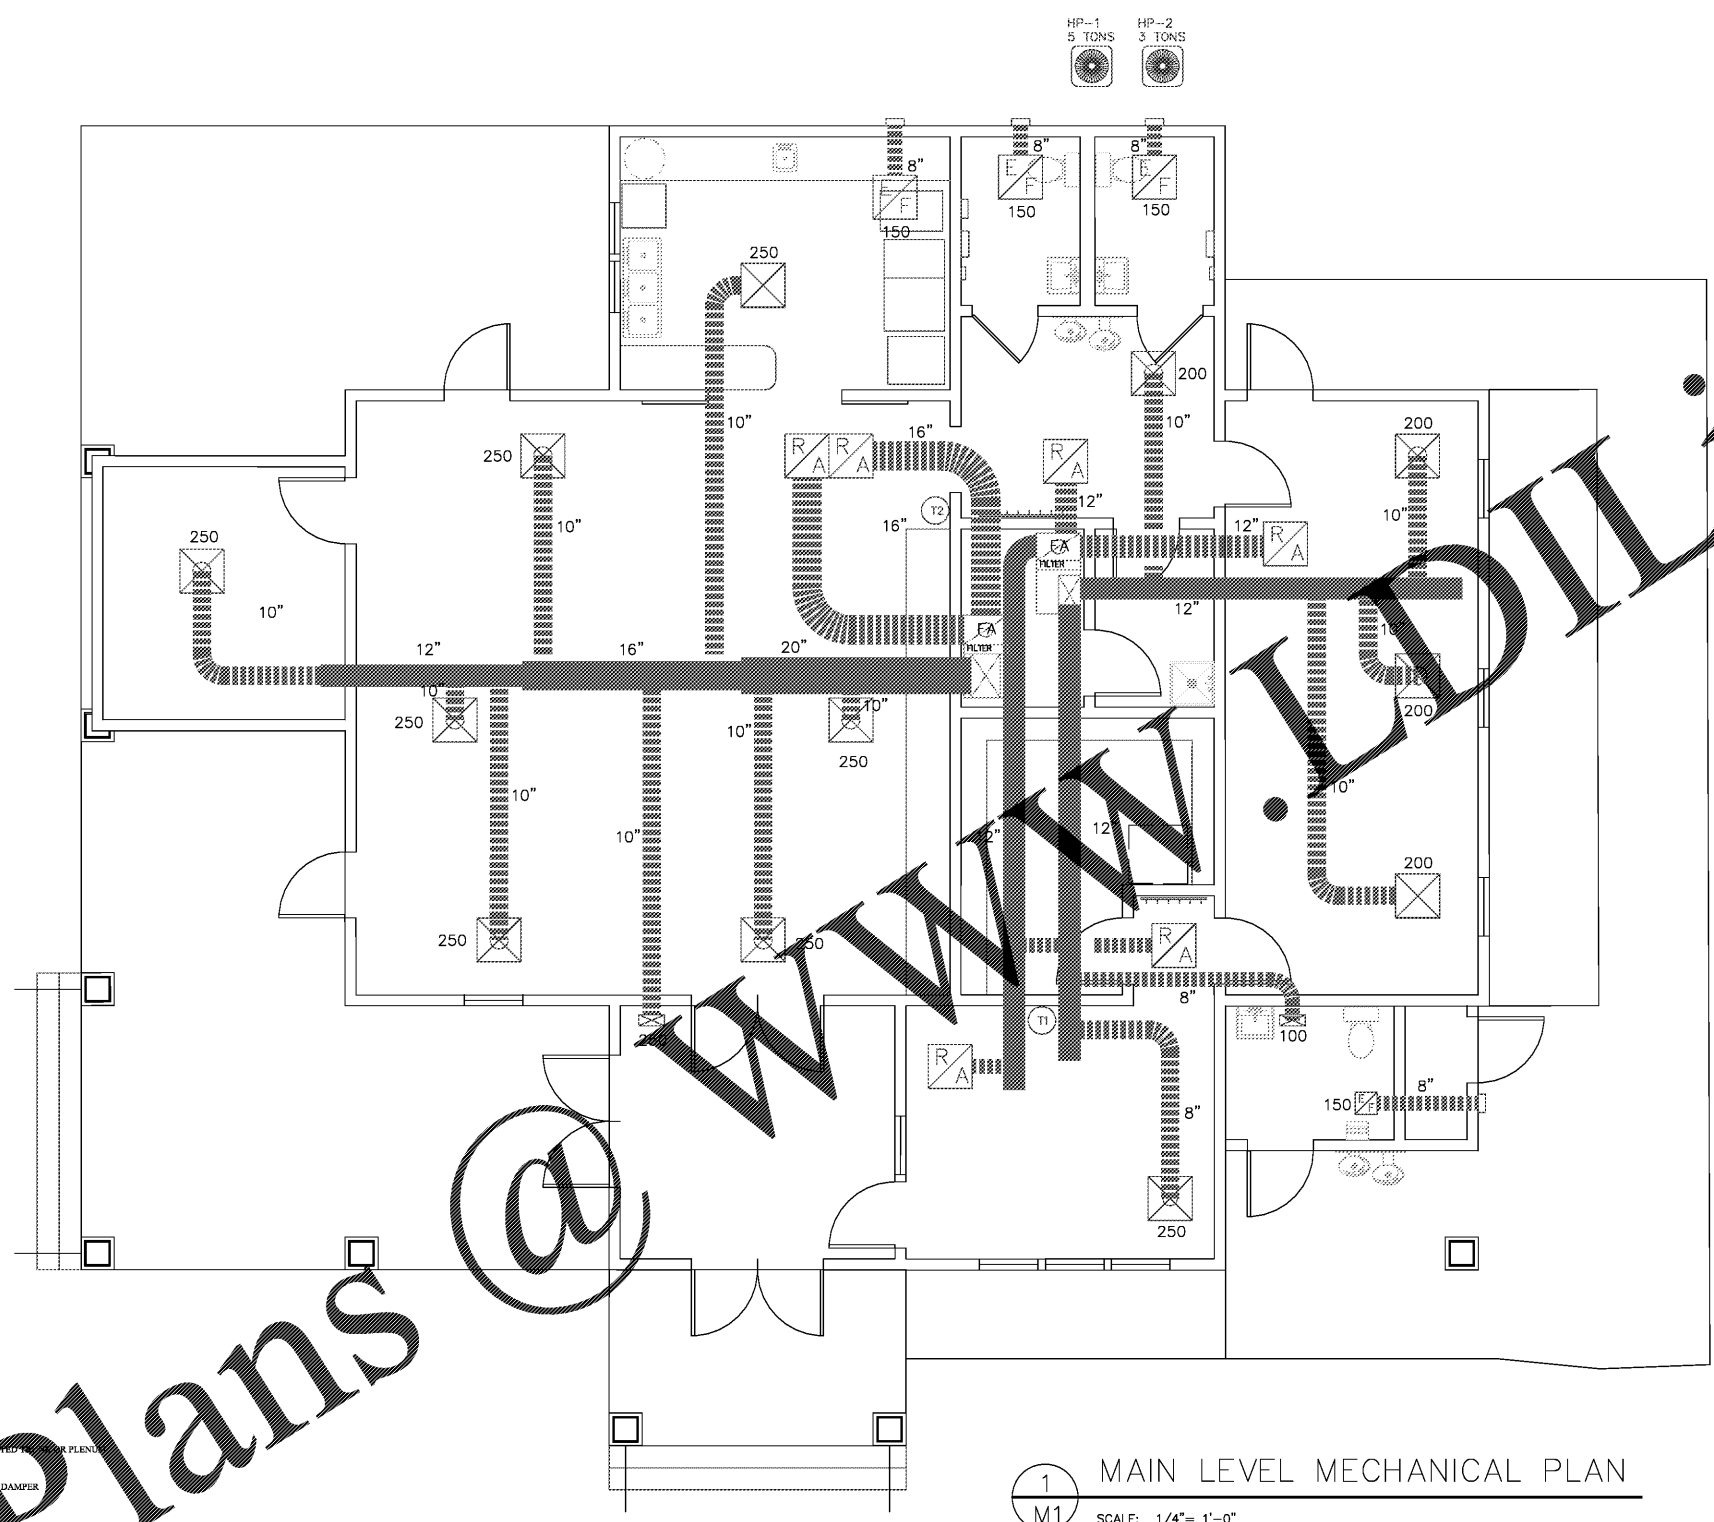

1 MAIN LEVEL MECHANICAL PLAN
M1 SCALE: 1/4" = 1'-0"

NOTES:
PROVIDE FRESH AIR INTO RETURN SIDE OF EACH SYSTEM PER TABLE 403.3 2012 IMC.
PROVIDE A TEST & BALANCE REPORT PRIOR TO REQUESTING FINAL INSPECTION.

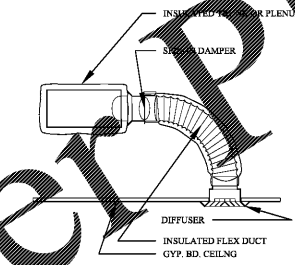

2 DIFFUSER DETAIL
M1 SCALE: NTS

Order Plans @ WWW.DILine.com