


REVISIONS	
NO.	DATE

A
NEW TOWN
HALL FOR:

THE TOWN OF
NORTH
HIGH
SHOALS

260 HILLSBORO
ROAD

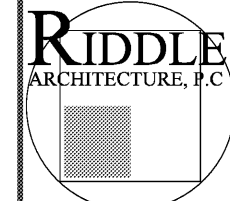



1481 HODGES MILL ROAD
BOGART, GA
30622
(404) 285-8646

TITLE: MAIN LEVEL
PLUMBING
PLAN


JOB #: 1510
DATE: 11.17.17

SHEET #
P1

FOR BIDDING & PRICING

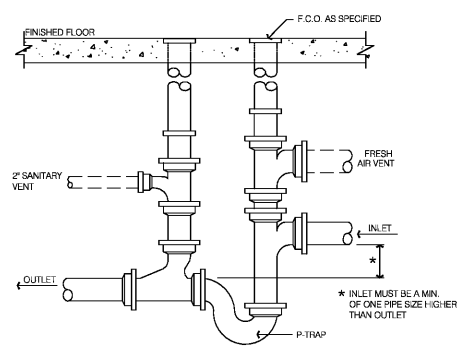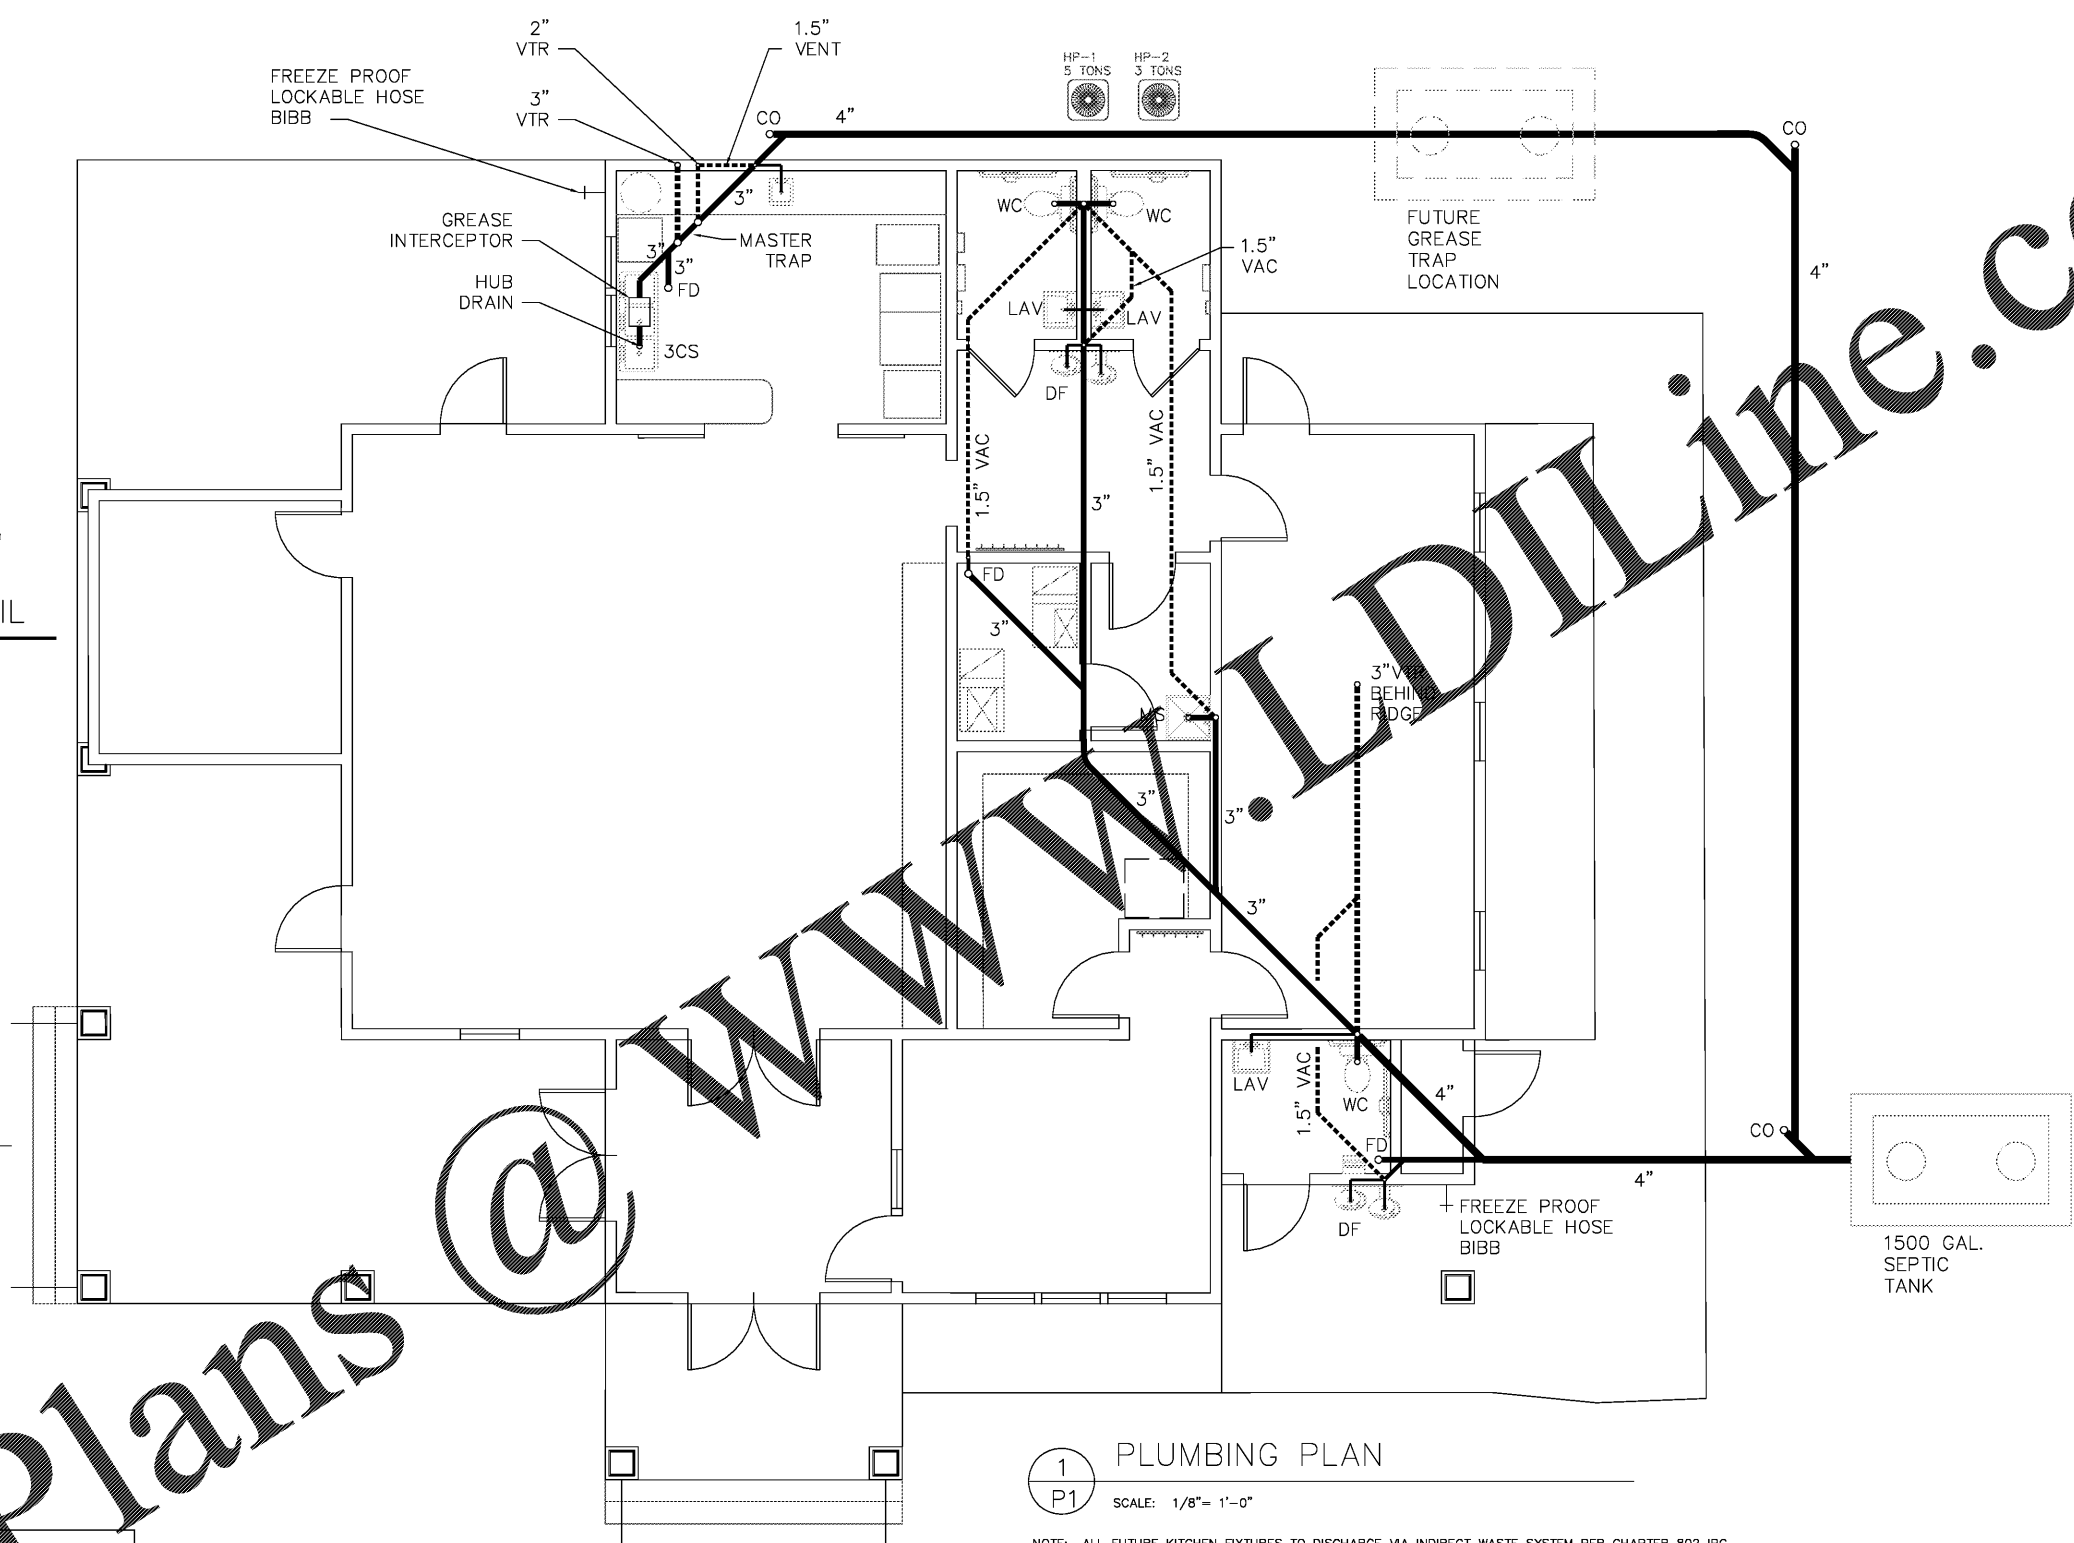

2 MASTER TRAP DETAIL
P1 SCALE: N.T.S.

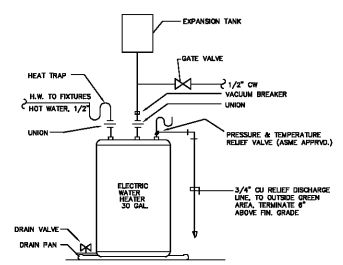

3 WATER HEATER DETAIL
P1 SCALE: N.T.S.

1 PLUMBING PLAN
P1 SCALE: 1/8" = 1'-0"

NOTE: ALL FUTURE KITCHEN FIXTURES TO DISCHARGE VIA INDIRECT WASTE SYSTEM PER CHAPTER 802 IPC
LAVATORIES REQUIRE 0.5 GPM AERATORS OR 0.25 GPM PER METERING CYCLE (IPC TABLE 604.4)
WATER CLOSETS TO USE NO MORE THEN 1.28 GAL. PER FLUSHING CYCLE
FLUSH HANDLES FOR WATER CLOSETS MUST BE ON WIDE SIDE OF WATER CLOSET COMPARTMENT
PROVIDE 110 DEGREE TEMPERED WATER TO ACCESSIBLE HAND WASH.

- PLUMBING NOTES:
- PERFORM ALL WORK IN ACCORDANCE WITH LOCAL GOVERNING CODES.
 - PLUMBING CONTRACTOR TO PAY ALL PERMIT FEES.
 - BACKFLOW PREVENTER SHALL BE HOUSED IN A SEPARATE BOX OR VAULT.
 - PLUMBING CONTRACTOR SHALL VERIFY ALL SITE CONDITIONS PRIOR TO COMMENCEMENT OF WORK.
 - PROVIDE CUT SHEETS OF ALL FIXTURES, FITTINGS AND ACCESSORIES TO OWNER PRIOR TO PURCHASE.
 - PLUMBING CONTRACTOR TO FURNISH AND INSTALL FIXTURES AND PROVIDE AIR CHAMBERS AT EACH GROUP OF FIXTURES AS REQUIRED.
 - PROVIDE CUT-OFF VALVES FOR EACH FIXTURE.
 - JOIN DISSIMILAR METALS WITH DIELECTRIC FITTING.
 - PIPING & FITTINGS:
A. COLD WATER PIPING DOWNSTREAM OF WATER METER SHALL BE TYPE "L" COPPER BELOW GROUND AND TYPE "M" COPPER ABOVE GROUND.
B. SANITARY TO BE SCHEDULE 40 PVC
 - PROVIDE TRAP PRIMER FOR ALL FLOOR DRAINS.

PLUMBING SCHEDULE:

MARK	FIXTURE	MFG'R	MODEL	REMARKS
WC	ADA WATER CLOSET FLUSH VALVE SEAT	KOHLER	K-4302-0	OR MAYOR APPROVED EQUAL
		KOHLER	K-13516	
		KOHLER	K-4837-0	
LAV	ADA LAVATORY FAUCET SET	K&H	K-728-0	OR MAYOR APPROVED EQUAL
		DELTA	BZ-91LF-PPU	PROVIDE 591TP0250 FAUCET SET UNISEX
MS	MOP SINK	ZURN	11990	OR MAYOR APPROVED EQUAL
	FAUCET	ZURN	11996-SF	
DF	LOW FLOW SINK	HALLOWELL TAYLOR	DWL-II SEBP-FR W/O REFRIGERATION	OR MAYOR APPROVED EQUAL
EWH	WATER HEATER	BRADFORD WHITE	LE130L3-3	OR MAYOR APPROVED EQUAL
FD	FLOOR DRAIN	ZURN	FD-2202 4"	OR MAYOR APPROVED EQUAL
	HOT FREEZE PROOF BIBB OPERATED	WOODFORD	B65AL	OR MAYOR APPROVED EQUAL
3CS	3 COMPART'T SINK	REGENCY	600S31515	OR MAYOR APPROVED EQUAL
		W/ DELTA	28P4202LF	W/ T & S BRASS LEVER TYPE POP-UP DRAINS #: B-3960