

GENERAL NOTES

A. CO2 MONITORING SYSTEM PROVIDED BY 7-ELEVEN. CONTRACTOR TO COORDINATE INSTALLATION OF CO2 MONITORING SYSTEM WITH AUTHORIZED INSTALLER. REFERENCE EF-1 SHEET FOR SPECIFICATIONS.

KEY NOTES

- LOGICO2 MODEL MK10 SET 2A WITH CENTRAL UNIT.
- CO2 ALERT WITH BUILT IN LAMP/ BUZZER/ 15FT POWER CABLE.
- WARNING LAMP INCLUDING 15FT CALBE AND CONNCTOR.
- POWER SUPPLY.
- CO2 WARNING SIGN.
- STAINLESS STEEL PROTECTION BAR.
- EXTERIOR CO2 TANK.
- BAG IN BOX RACKS
- POST MIX

SEAL:

NO. DATE REMARKS
REVISIONS



BID SET
JANUARY 8, 2018


7-ELEVEN
STORE #32810

5544 RONALD REAGAN PARKWAY
DAVENPORT, FL
33896

PROJECT NO: 2016.0305
DATE: MAY 31, 2017


A0.4
CO2 SENSOR FLOOR PLAN

CHECKED: RW DRAWN: JUM

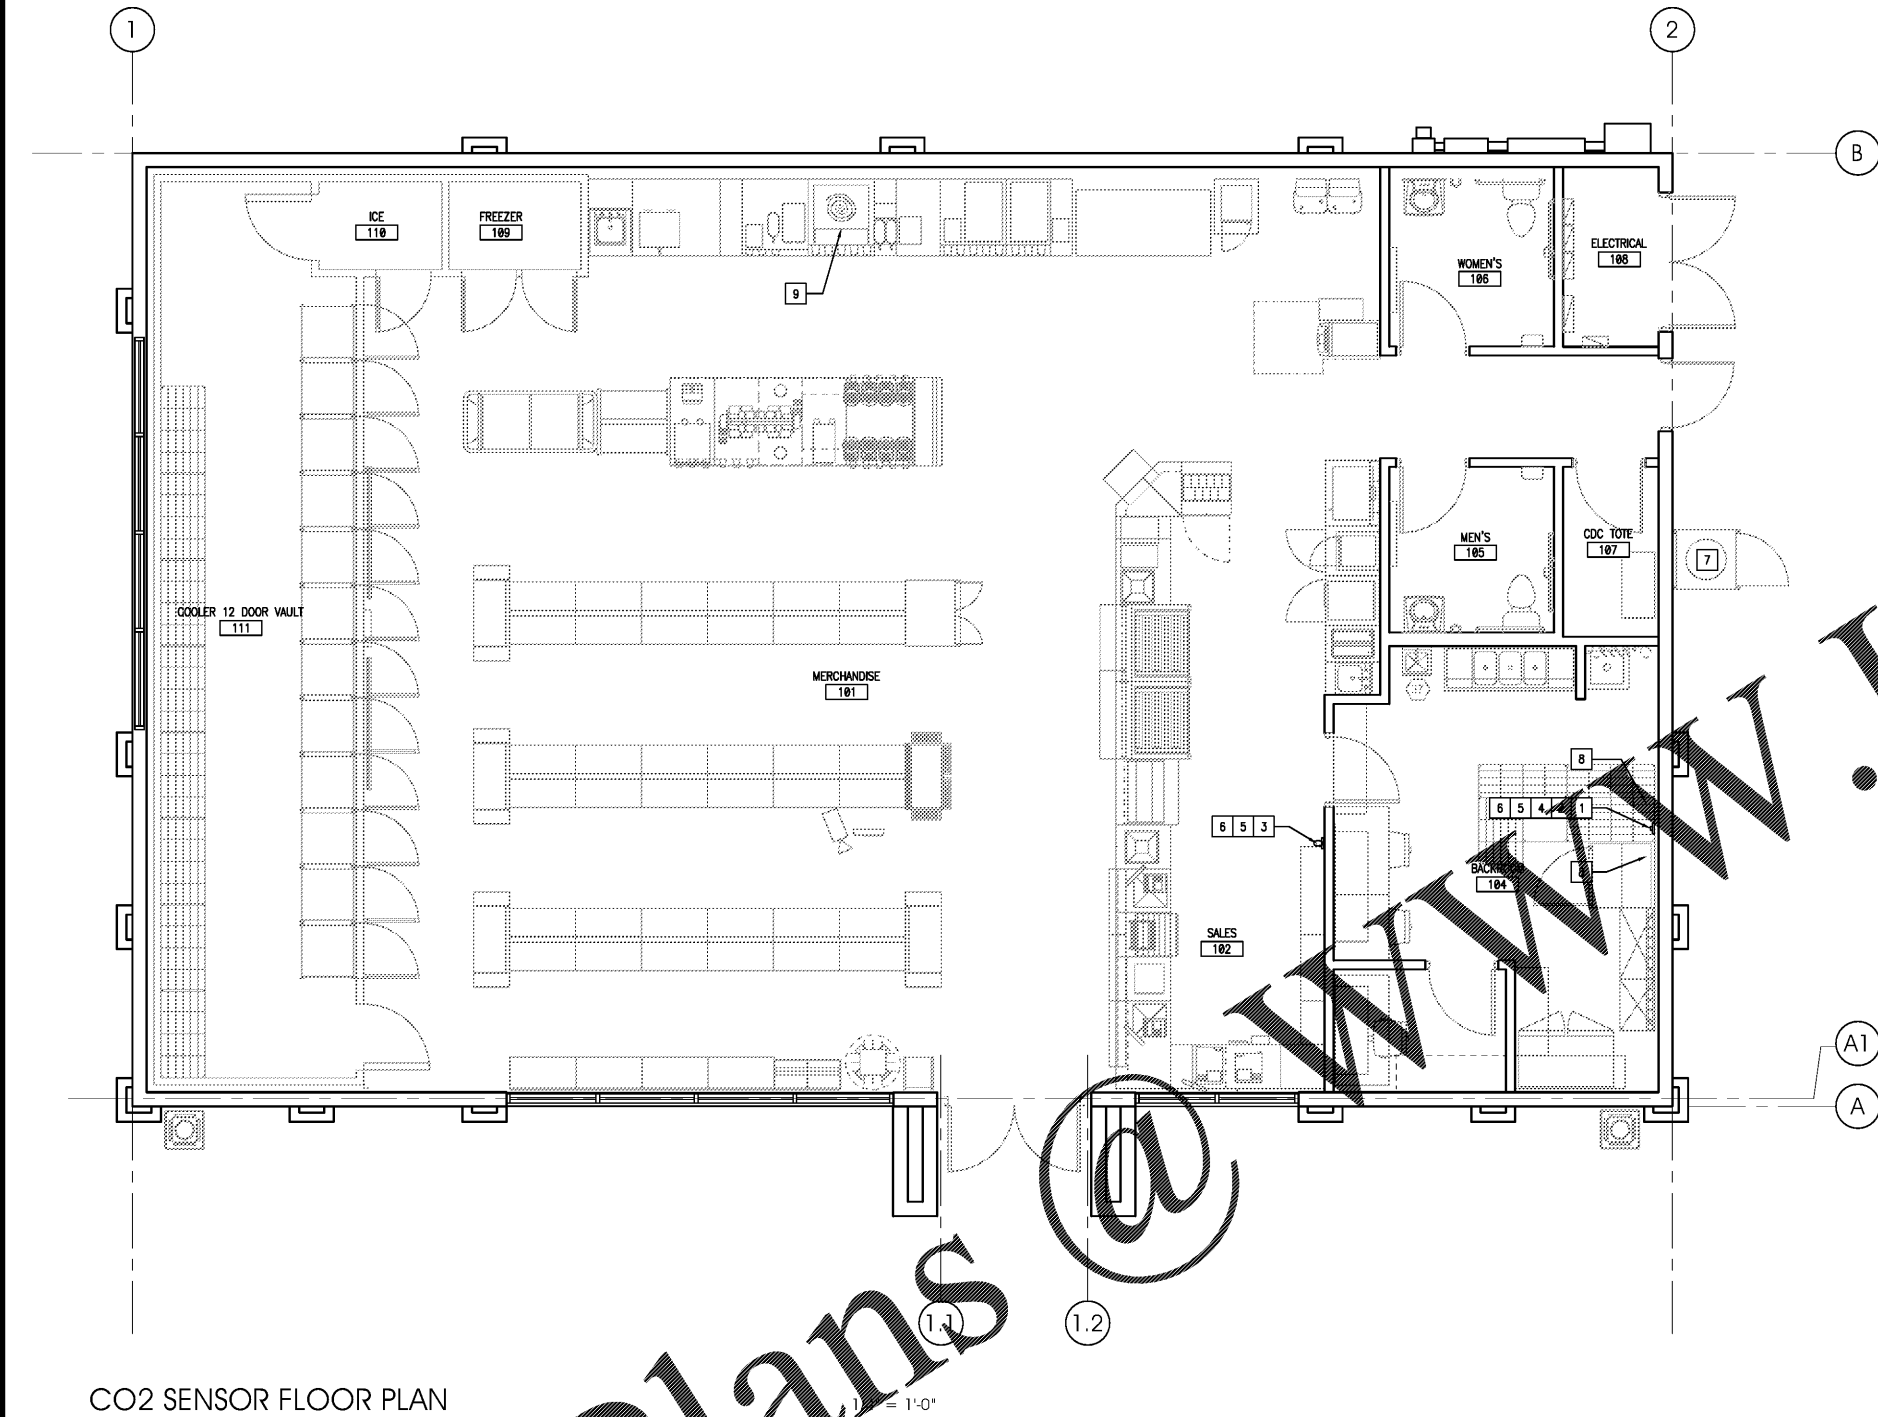

CO2 SENSOR FLOOR PLAN

 1" = 1'-0"



Order Plans

WWW.LDILine.com

INTERPLAN, LLC RESERVE COPYRIGHTS & OTHER RIGHTS RESTRICTING THESE DOCUMENTS TO THE ORIGINAL SITE OR PURPOSE FOR WHICH THEY WERE PREPARED. REPRODUCTIONS, CHANGES OR ASSIGNMENTS ARE PROHIBITED. COPYRIGHT © 2016