


SEAL:

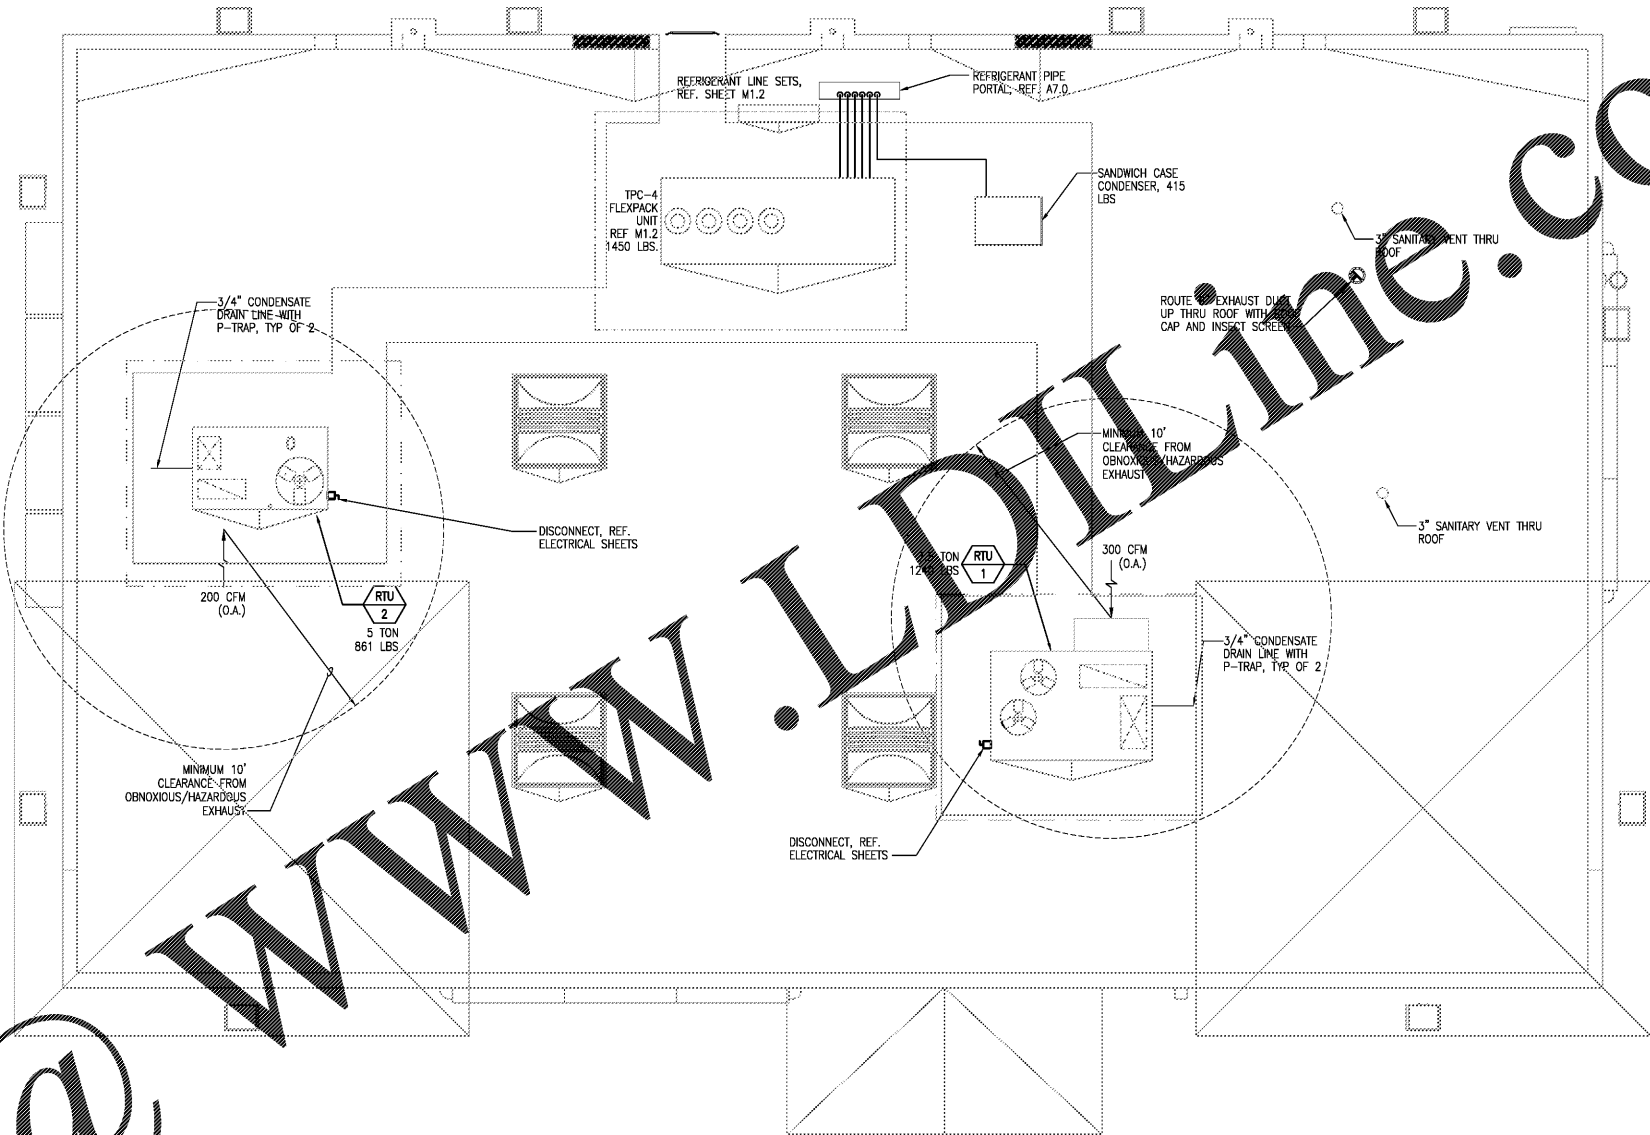

1 MECHANICAL ROOF PLAN 1/4" = 1'-0"



NO. DATE REMARKS  
REVISIONS



BID SET  
JANUARY 8, 2018

7-ELEVEN  
STORE #32810

5544 RONALD REAGAN PARKWAY  
DAVENPORT, FL  
33896

PROJECT NO: 2016.0305  
DATE: MAY 31, 2017

M1.1  
MECHANICAL ROOF PLAN

CHECKED: AS DRAWN: MM

Order Plans @

@

WWW.LDOnline.com