


SEAL:

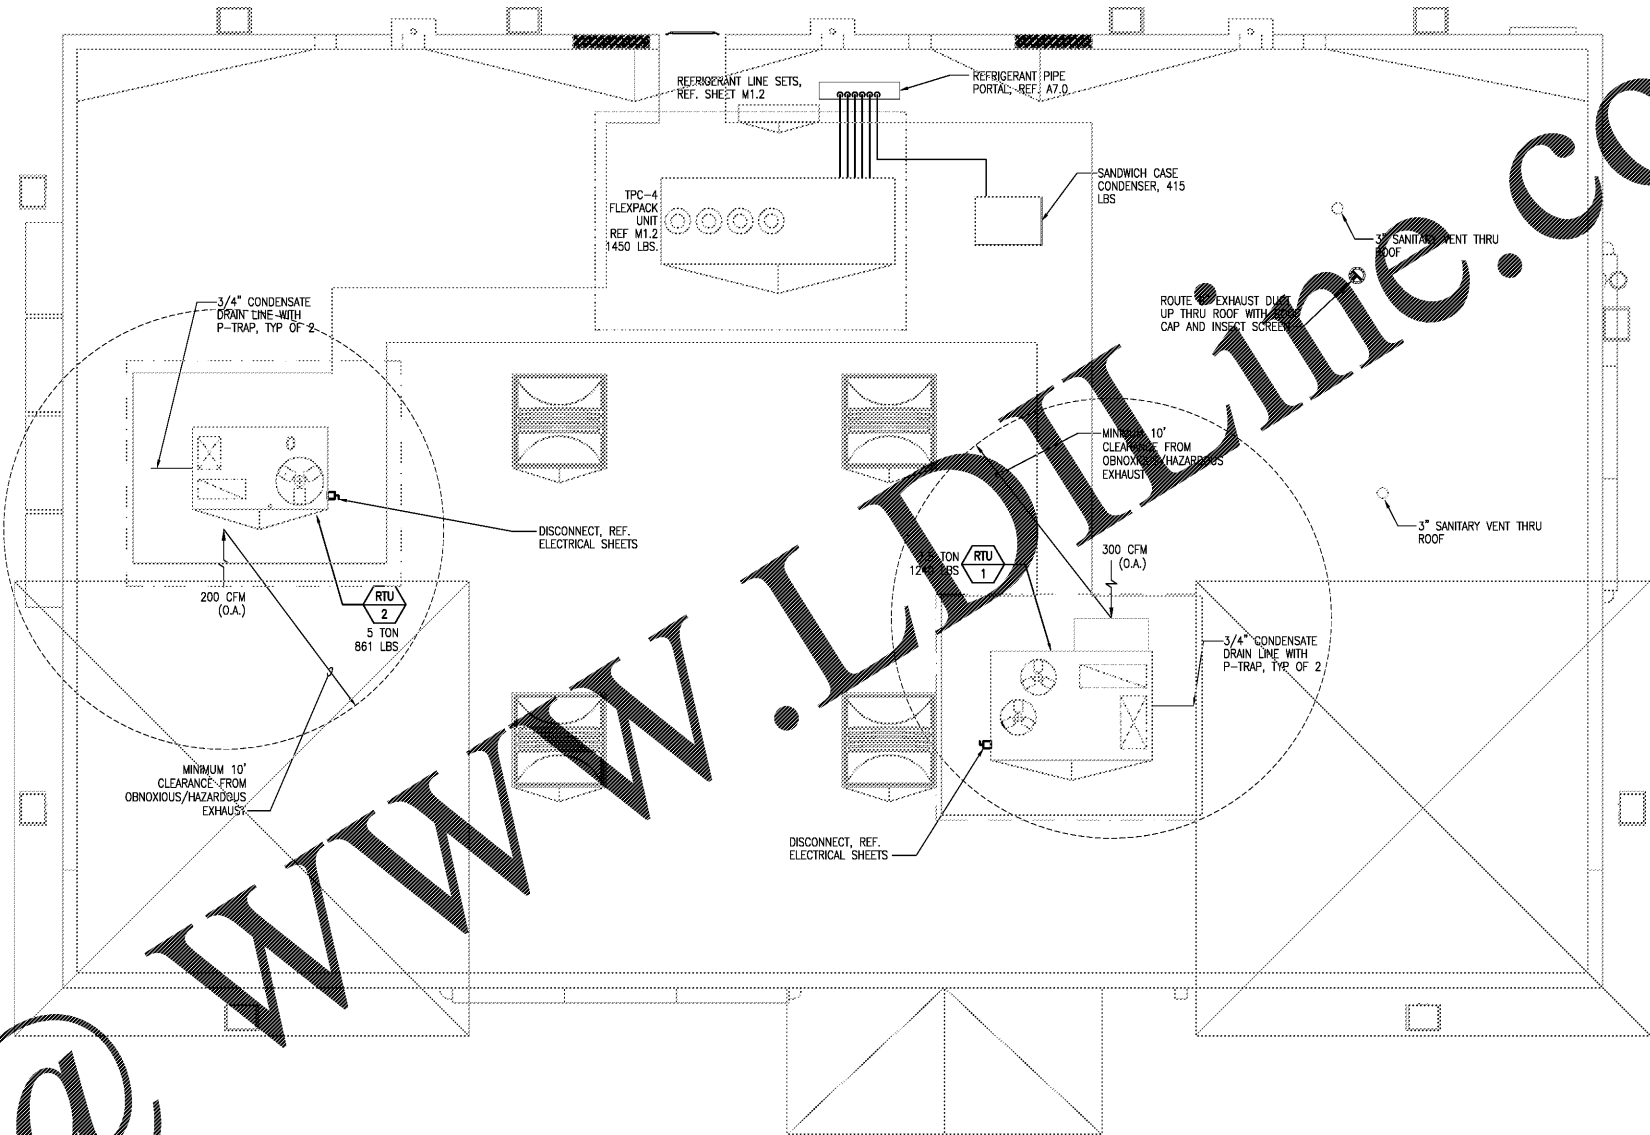

1 MECHANICAL ROOF PLAN 1/4" = 1'-0"



NO. DATE REMARKS
REVISIONS



BID SET
JANUARY 8, 2018

7-ELEVEN
STORE #32810

5544 RONALD REAGAN PARKWAY
DAVENPORT, FL
33896

PROJECT NO: 2016.0305
DATE: MAY 31, 2017

M1.1
MECHANICAL ROOF PLAN

CHECKED: AS DRAWN: MM

Order Plans

@

WWW.LDDLINE.COM