

REVISIONS:

No.	Description	Date

PROJECT: 9202-169779
 DATE: 12/18
 DRAWN BY: CDT
 CHECKED BY: JCC


FLOOR PLAN -
 DWV

P-200

DWV PIPING LEGEND

SANITARY BELOW SLAB
 VENT PIPING
 GREASE WASTE BELOW SLAB

Note: Sanitary tees are not allowed in a horizontal to horizontal connection. (2012 NCCP table 706.3)

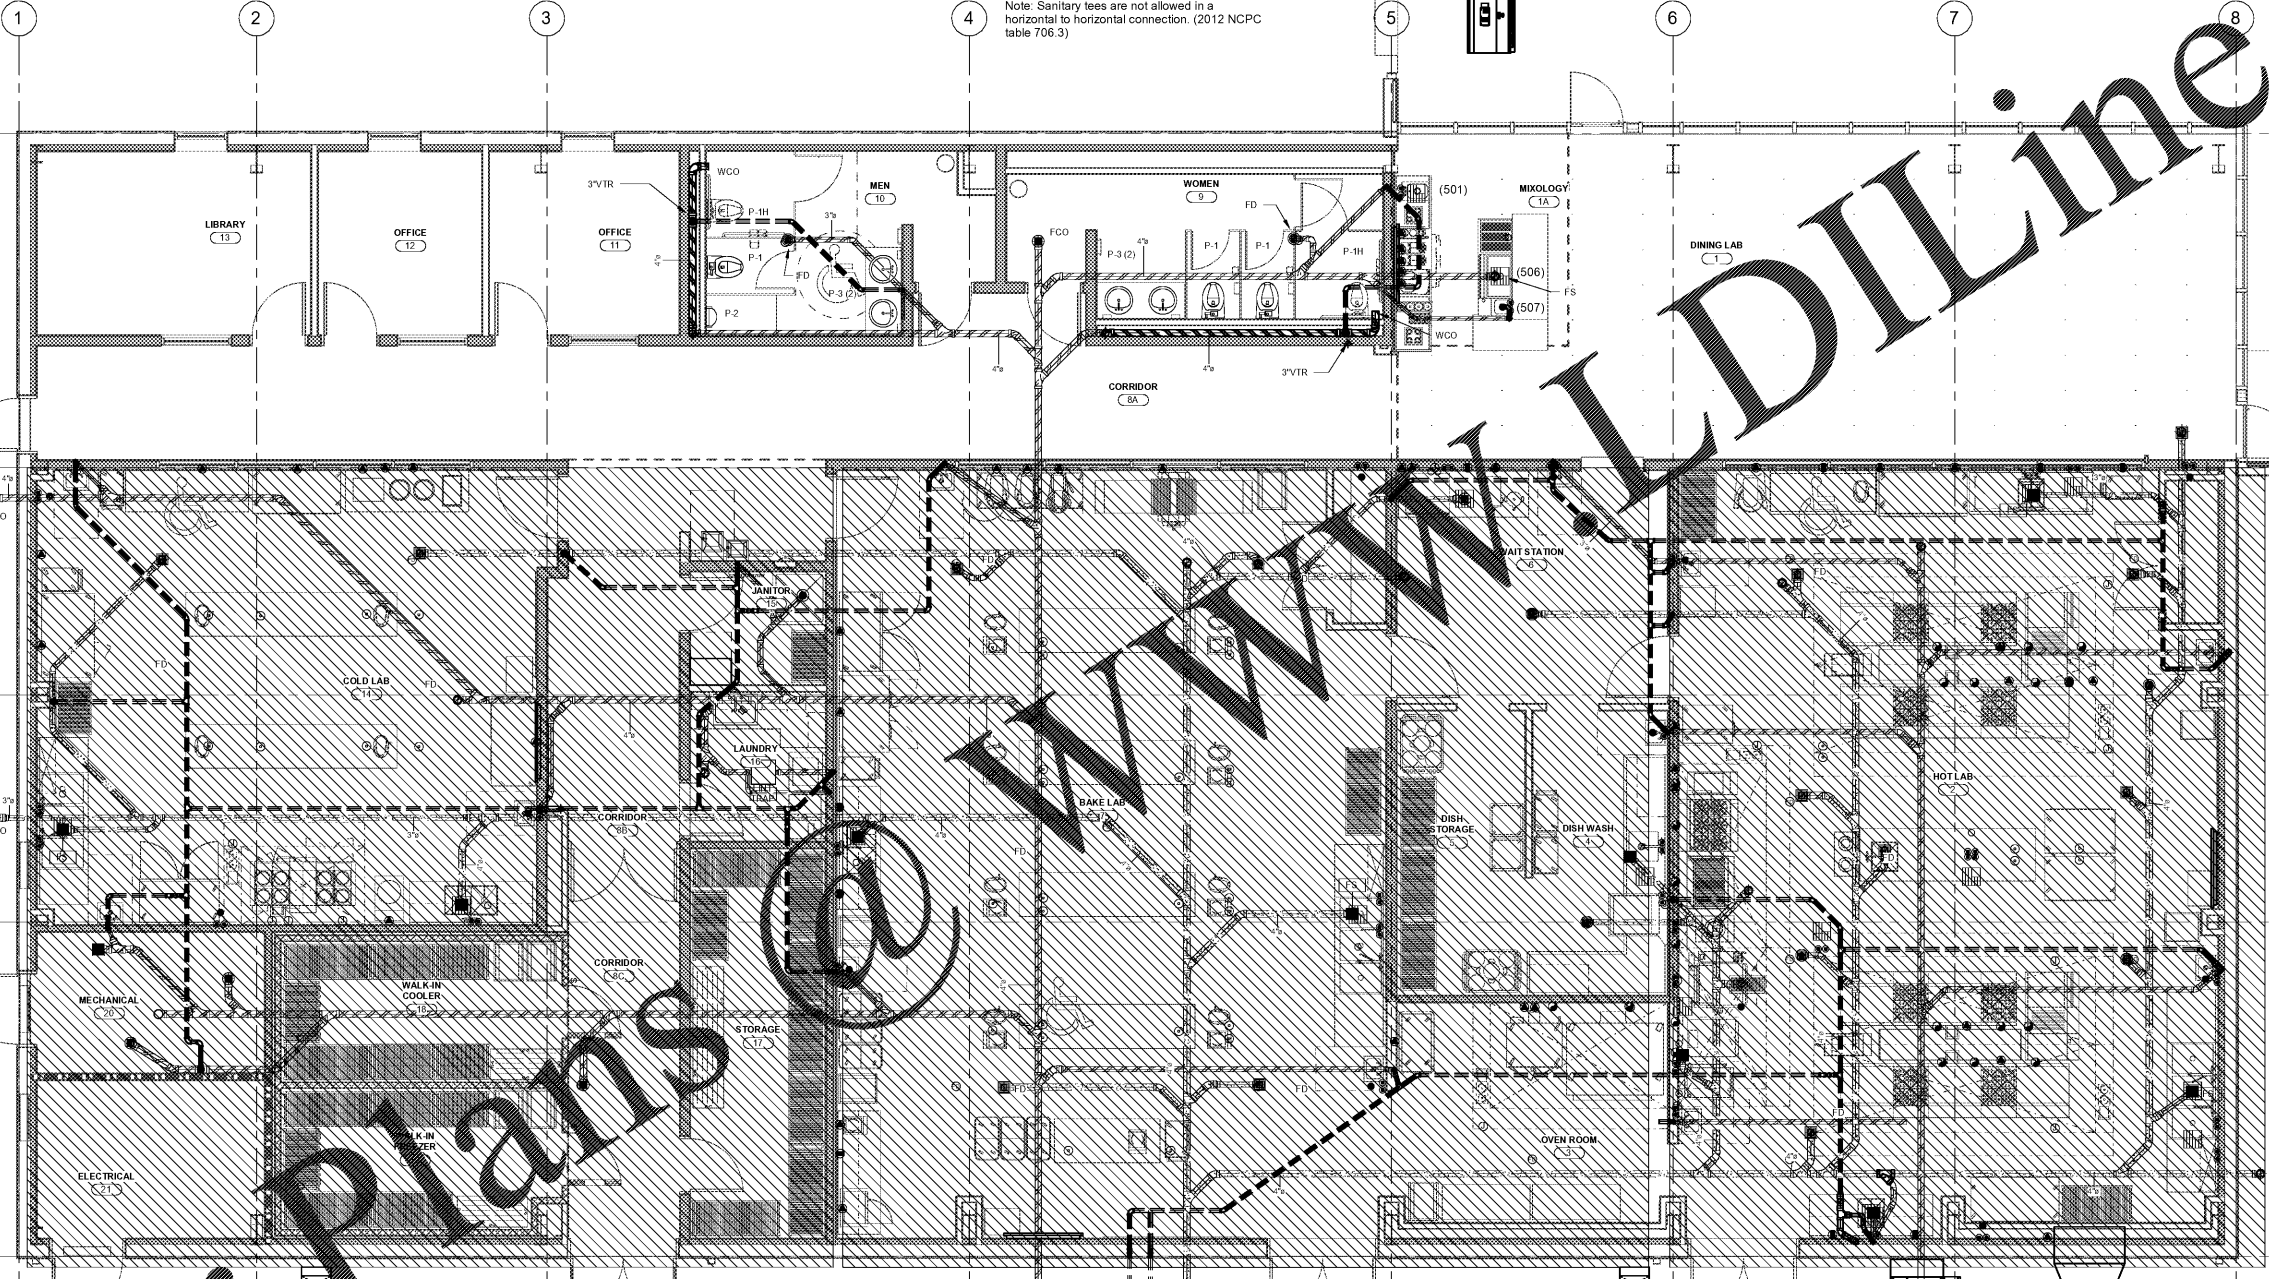

SEE P201 PLANS FOR COLD LAB

SEE P202 PLANS FOR BAKE LAB

SEE P203 PLANS FOR HOT LAB

1 FIRST FLOOR PLAN - DWV
 P-200 1/4" = 1'-0"

YCO: 4"SS @ -36"
 GREASE TRAP (SEE 1/P101); 4"SS @ -36"

YCO: 4"SS @ -36"

C:\Users\krowm\BIB\DWG\Documents\17413_WILKES CC CULINARY LAB_BIB\DWG_MP_2016_brown.rvt
 1/3/2018 2:01:27 PM

Order Plans @ www.lsdline.com