


REVISIONS:

No.	Description	Date

PROJECT: 9202-169779
 DATE: 12/18
 DRAWN BY: CDT
 CHECKED BY: JCC

ENLARGED
 PARTIAL
 FLOOR PLAN -
 DWV

P-201

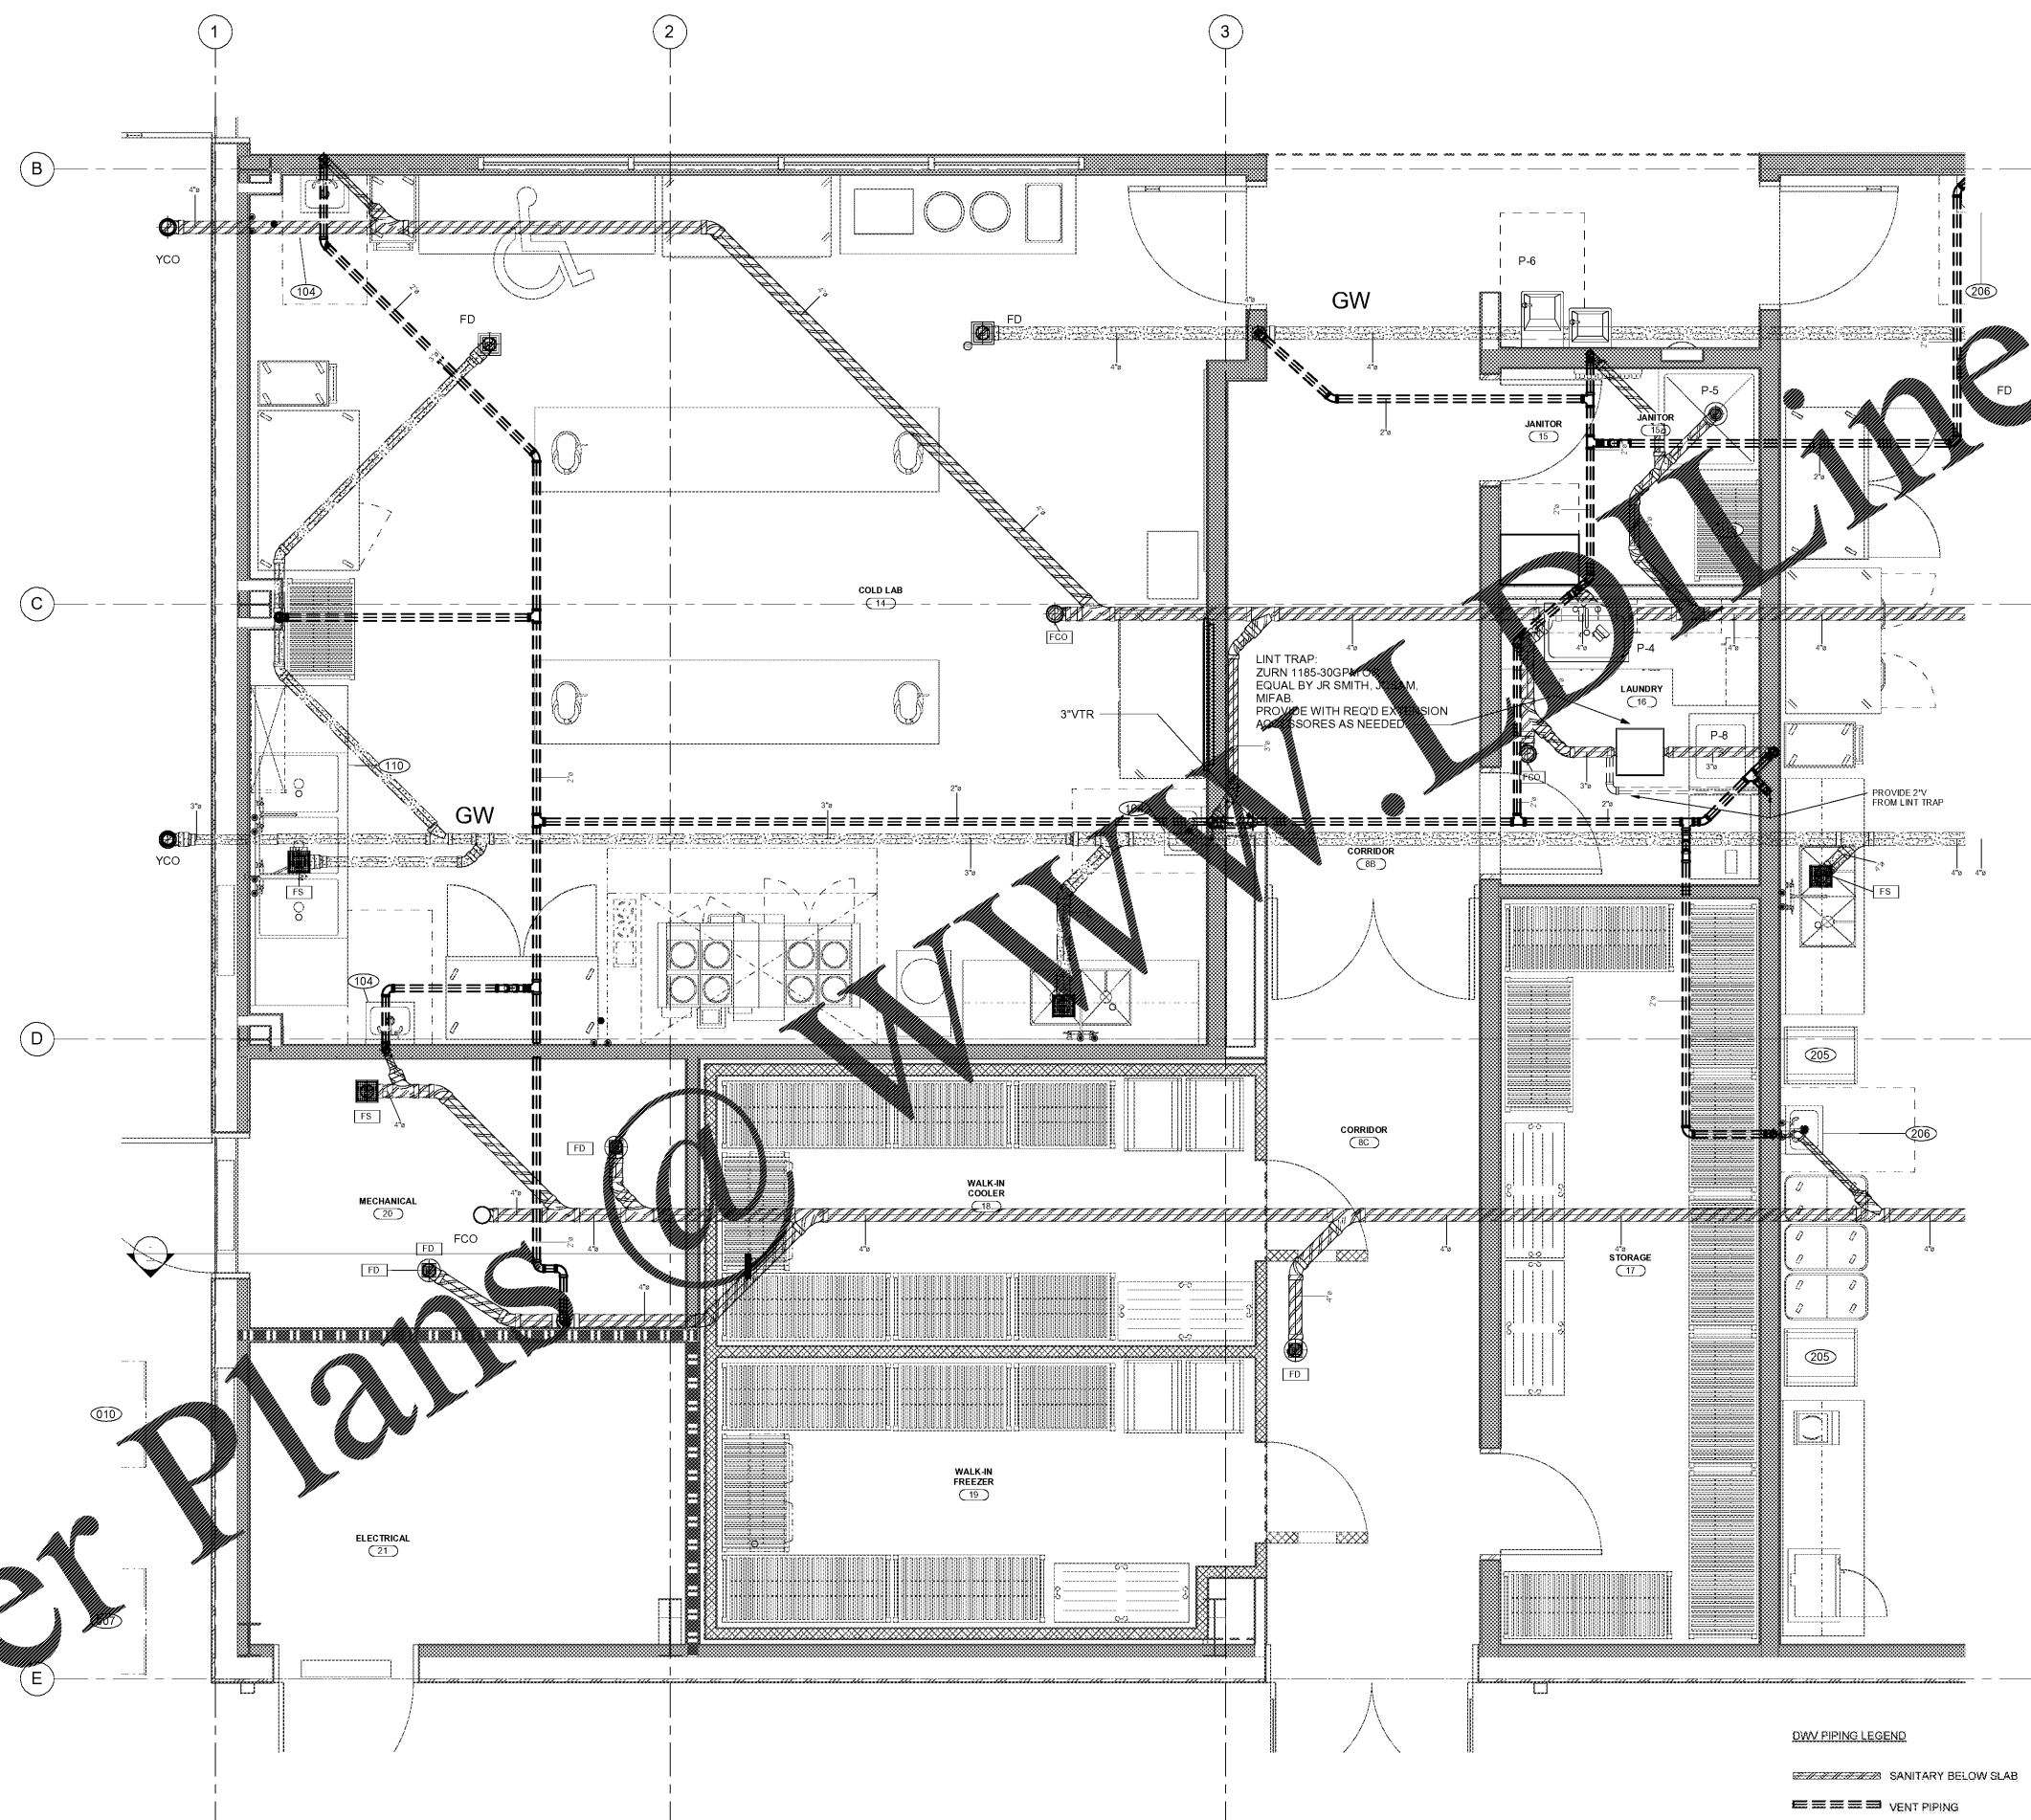

DWV PIPING LEGEND

	SANITARY BELOW SLAB
	VENT PIPING
	GREASE WASTE BELOW SLAB

1 ENLARGED PARTIAL FLOOR PLAN - COLD LAB & LAUNDRY AREA - DWV
 P-201 1/2" = 1'-0"

C:\Users\kswm\BWD\Documents\17413_WILKES CC CULINARY LAB_IBSWG_MP_2016_brown.rvt
 1/3/2018 2:02:01 PM

Order Plans @ www.lsdrawing.com