


REVISIONS:

No.	Description	Date

PROJECT: 9202-169779
 DATE: 12/18
 DRAWN BY: CDT
 CHECKED BY: JCC

ENLARGED
 PARTIAL
 FLOOR PLAN -
 DWV

P-203

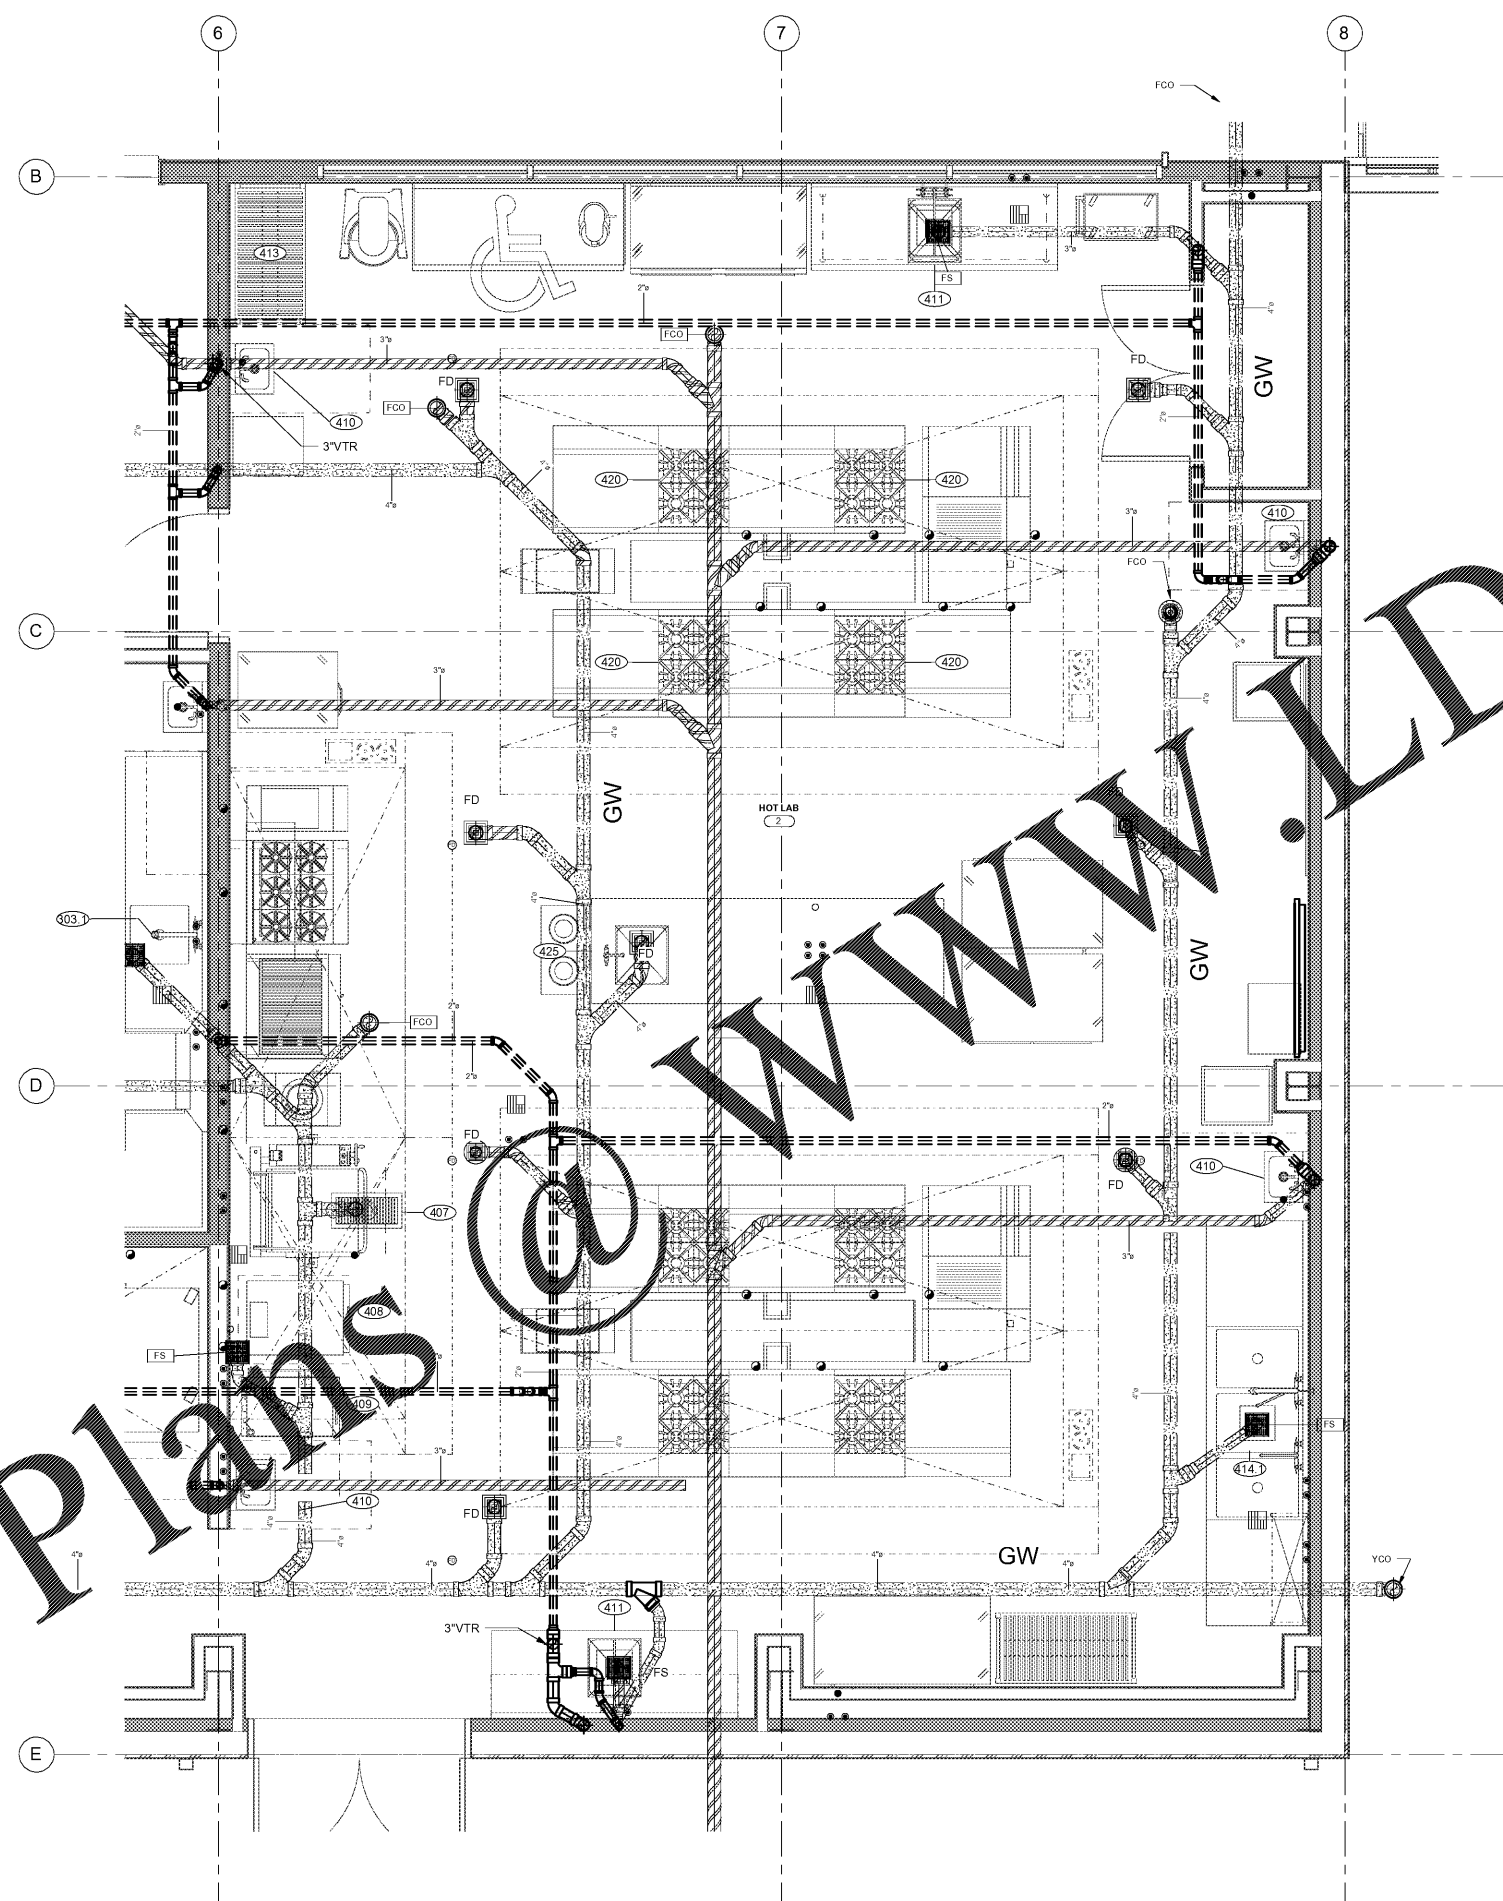

1 ENLARGED PARTIAL FLOOR PLAN - HOT LAB - DWV
 P-203 1/2" = 1'-0"

DWV PIPING LEGEND
 SANITARY BELOW SLAB
 VENT PIPING
 GREASE WASTE BELOW SLAB

C:\Users\skw\OneDrive\Documents\17-010-01A_WILKES CC_CULINARY LAB_IBSWG_MP_2016_brown.rvt
 1/2/2018 2:03:11 PM

Order Plans @ www.LDILine.com