



MEMBERS OF THE AMERICAN INSTITUTE OF ARCHITECTS


COPYRIGHT 2016 ALL RIGHTS RESERVED
 PRINTED OR ELECTRONIC DRAWINGS AND
 DOCUMENTATION MAY NOT BE REPRODUCED
 IN ANY FORM WITHOUT WRITTEN PERMISSION
 FROM LS3P ASSOCIATES LTD.

REVISIONS:


No.	Description	Date

PROJECT: 9202-169779
 DATE: 12/18
 DRAWN BY: CDT
 CHECKED BY: JCC

**FLOOR PLAN -
 WATER & GAS**
P-300

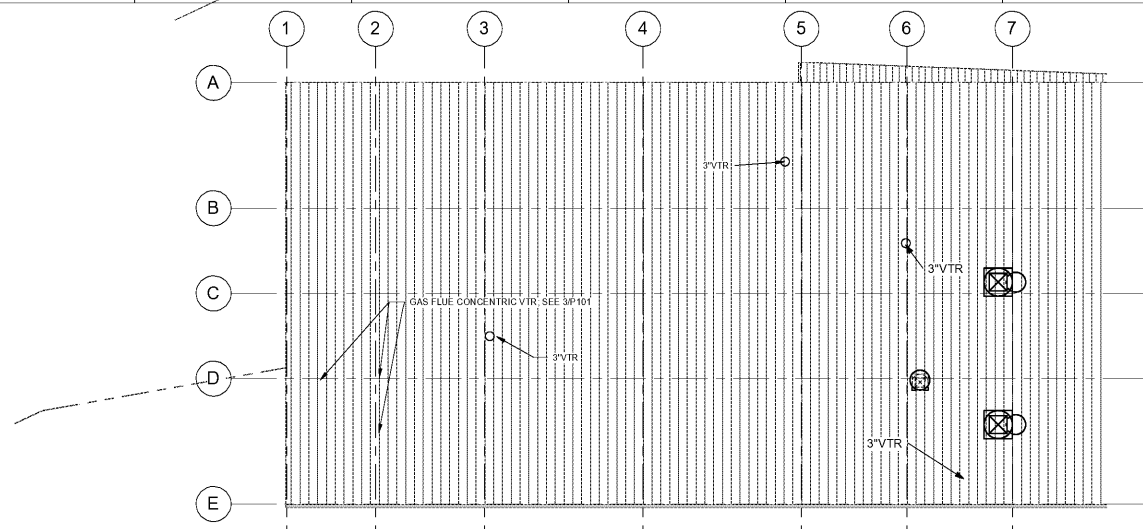

2 PARTIAL ROOF PLAN
 P-300 3/32" = 1'-0"

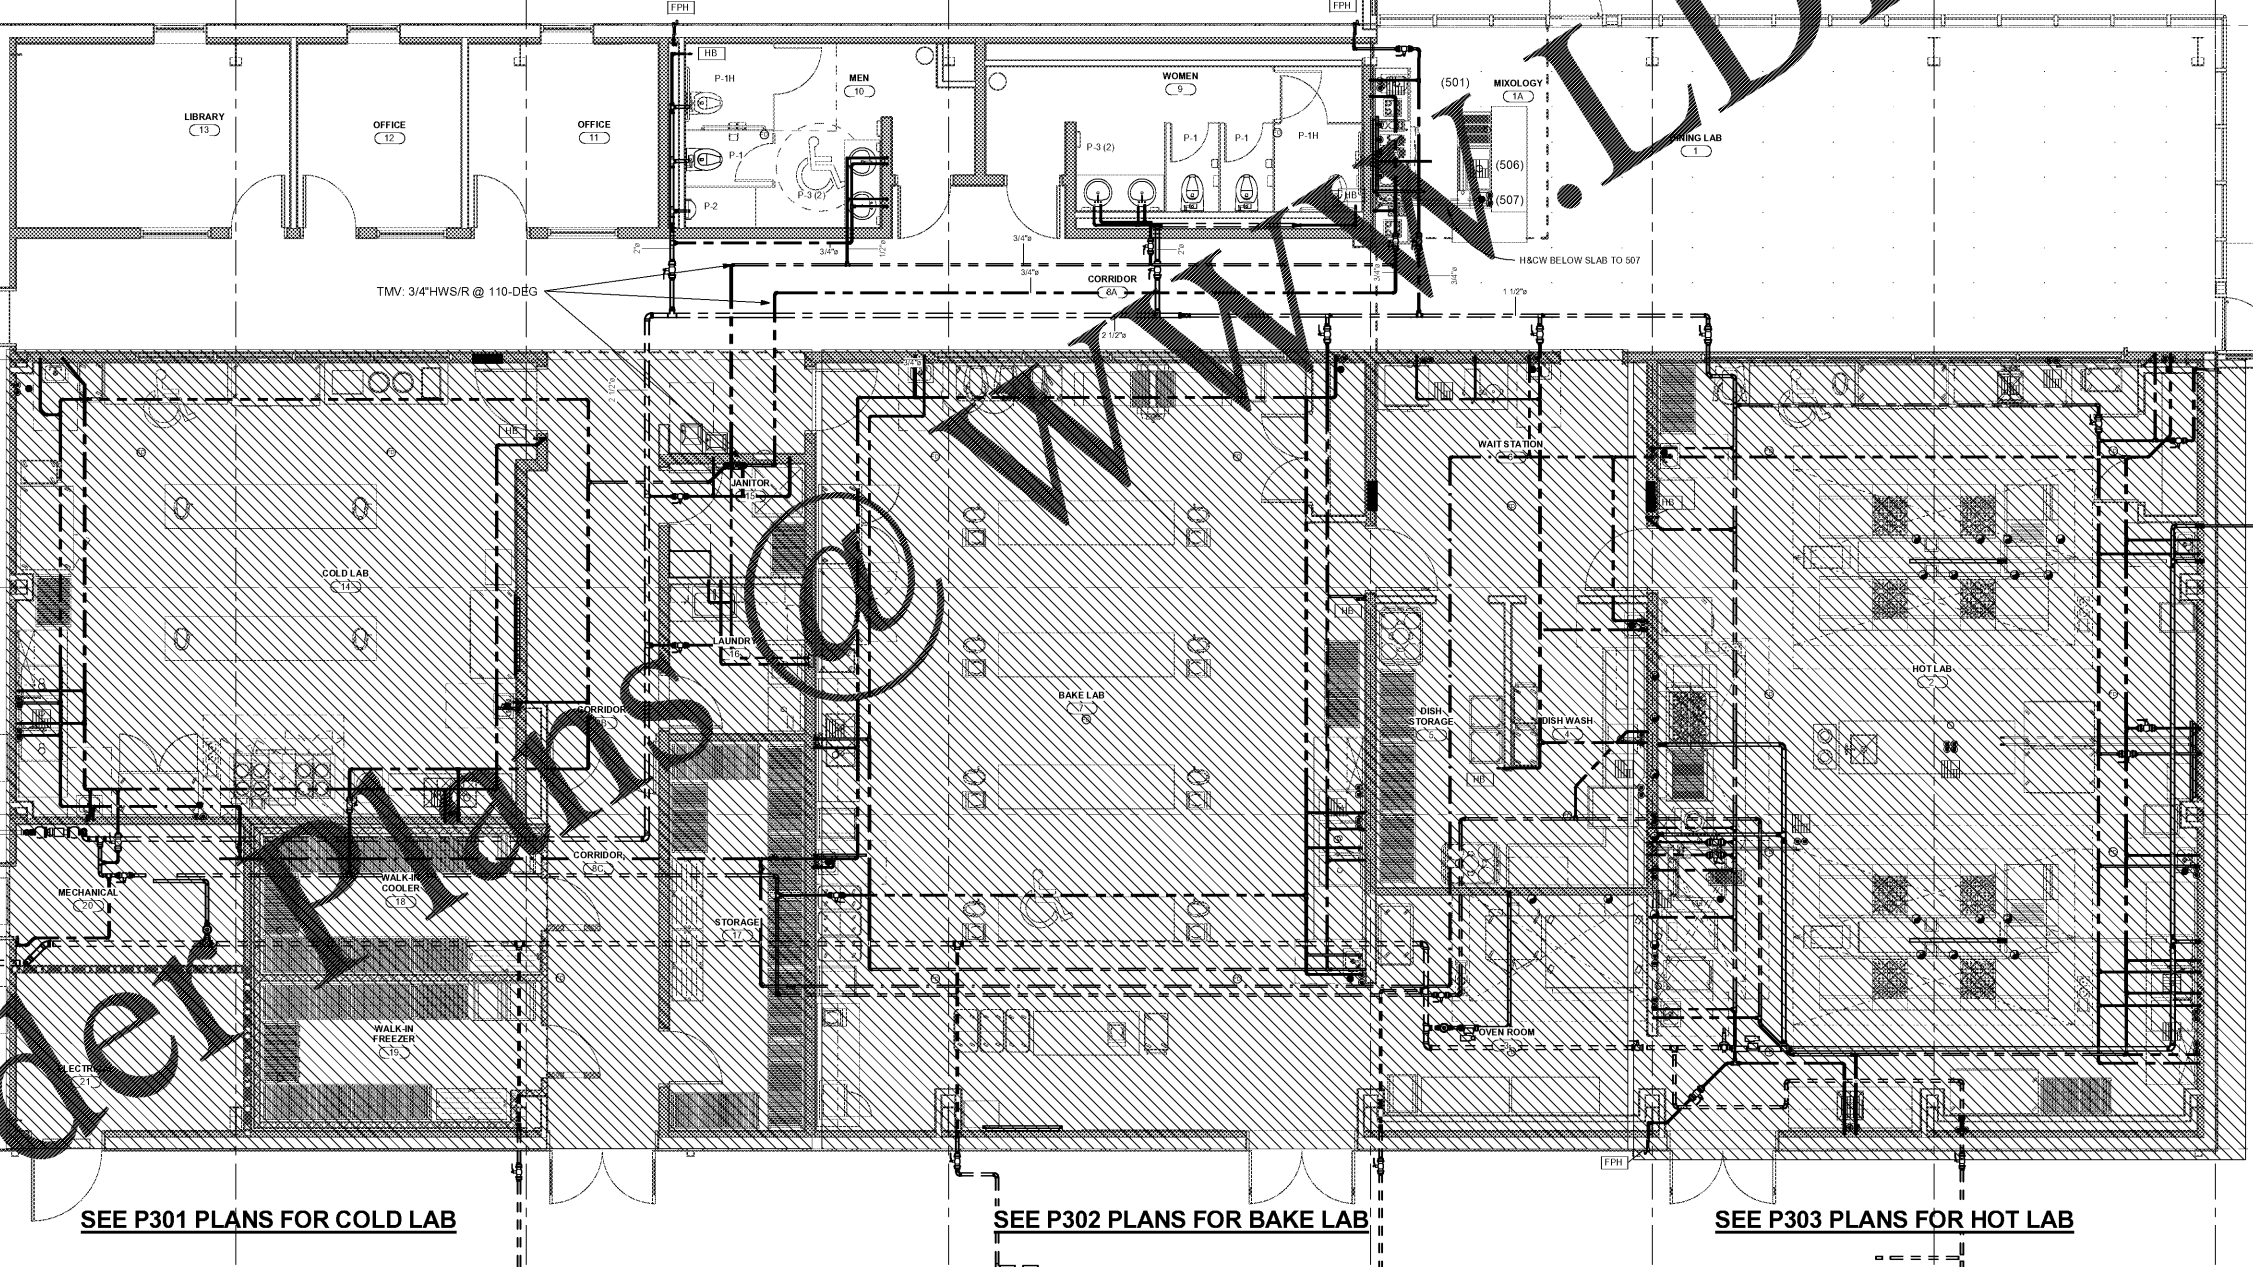

1 FIRST FLOOR PLAN - WATER
 P-300 1/4" = 1'-0"

SEE P301 PLANS FOR COLD LAB

SEE P302 PLANS FOR BAKE LAB

SEE P303 PLANS FOR HOT LAB

C:\Users\kswm\BROWDocuments\17413_WILKES CC CULINARY LAB_BROW_MP_2016_brownm\1/2/2018 2:03:48 PM