



MEMBERS OF THE AMERICAN INSTITUTE OF ARCHITECTS


COPYRIGHT 2016 ALL RIGHTS RESERVED  
 PRINTED OR ELECTRONIC DRAWINGS AND  
 DOCUMENTATION MAY NOT BE REPRODUCED  
 IN ANY FORM WITHOUT WRITTEN PERMISSION  
 FROM LS3P ASSOCIATES LTD.

REVISIONS:


No.	Description	Date

PROJECT: 9202-169779  
 DATE: 12/18  
 DRAWN BY: CDT  
 CHECKED BY: JCC

**FLOOR PLAN -  
 WATER & GAS**  
**P-300**

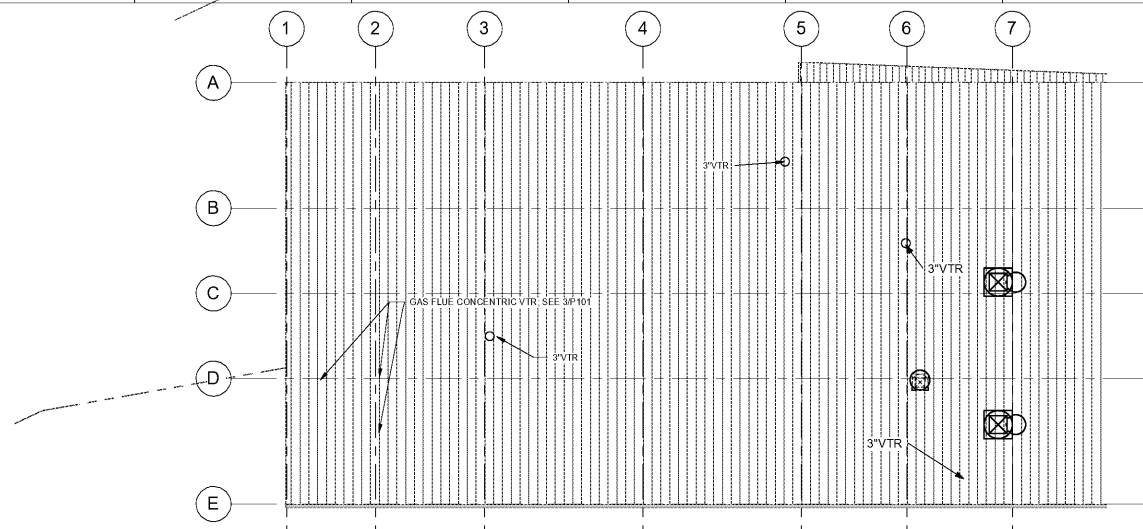

**2 PARTIAL ROOF PLAN**  
 P-300 3/32" = 1'-0"

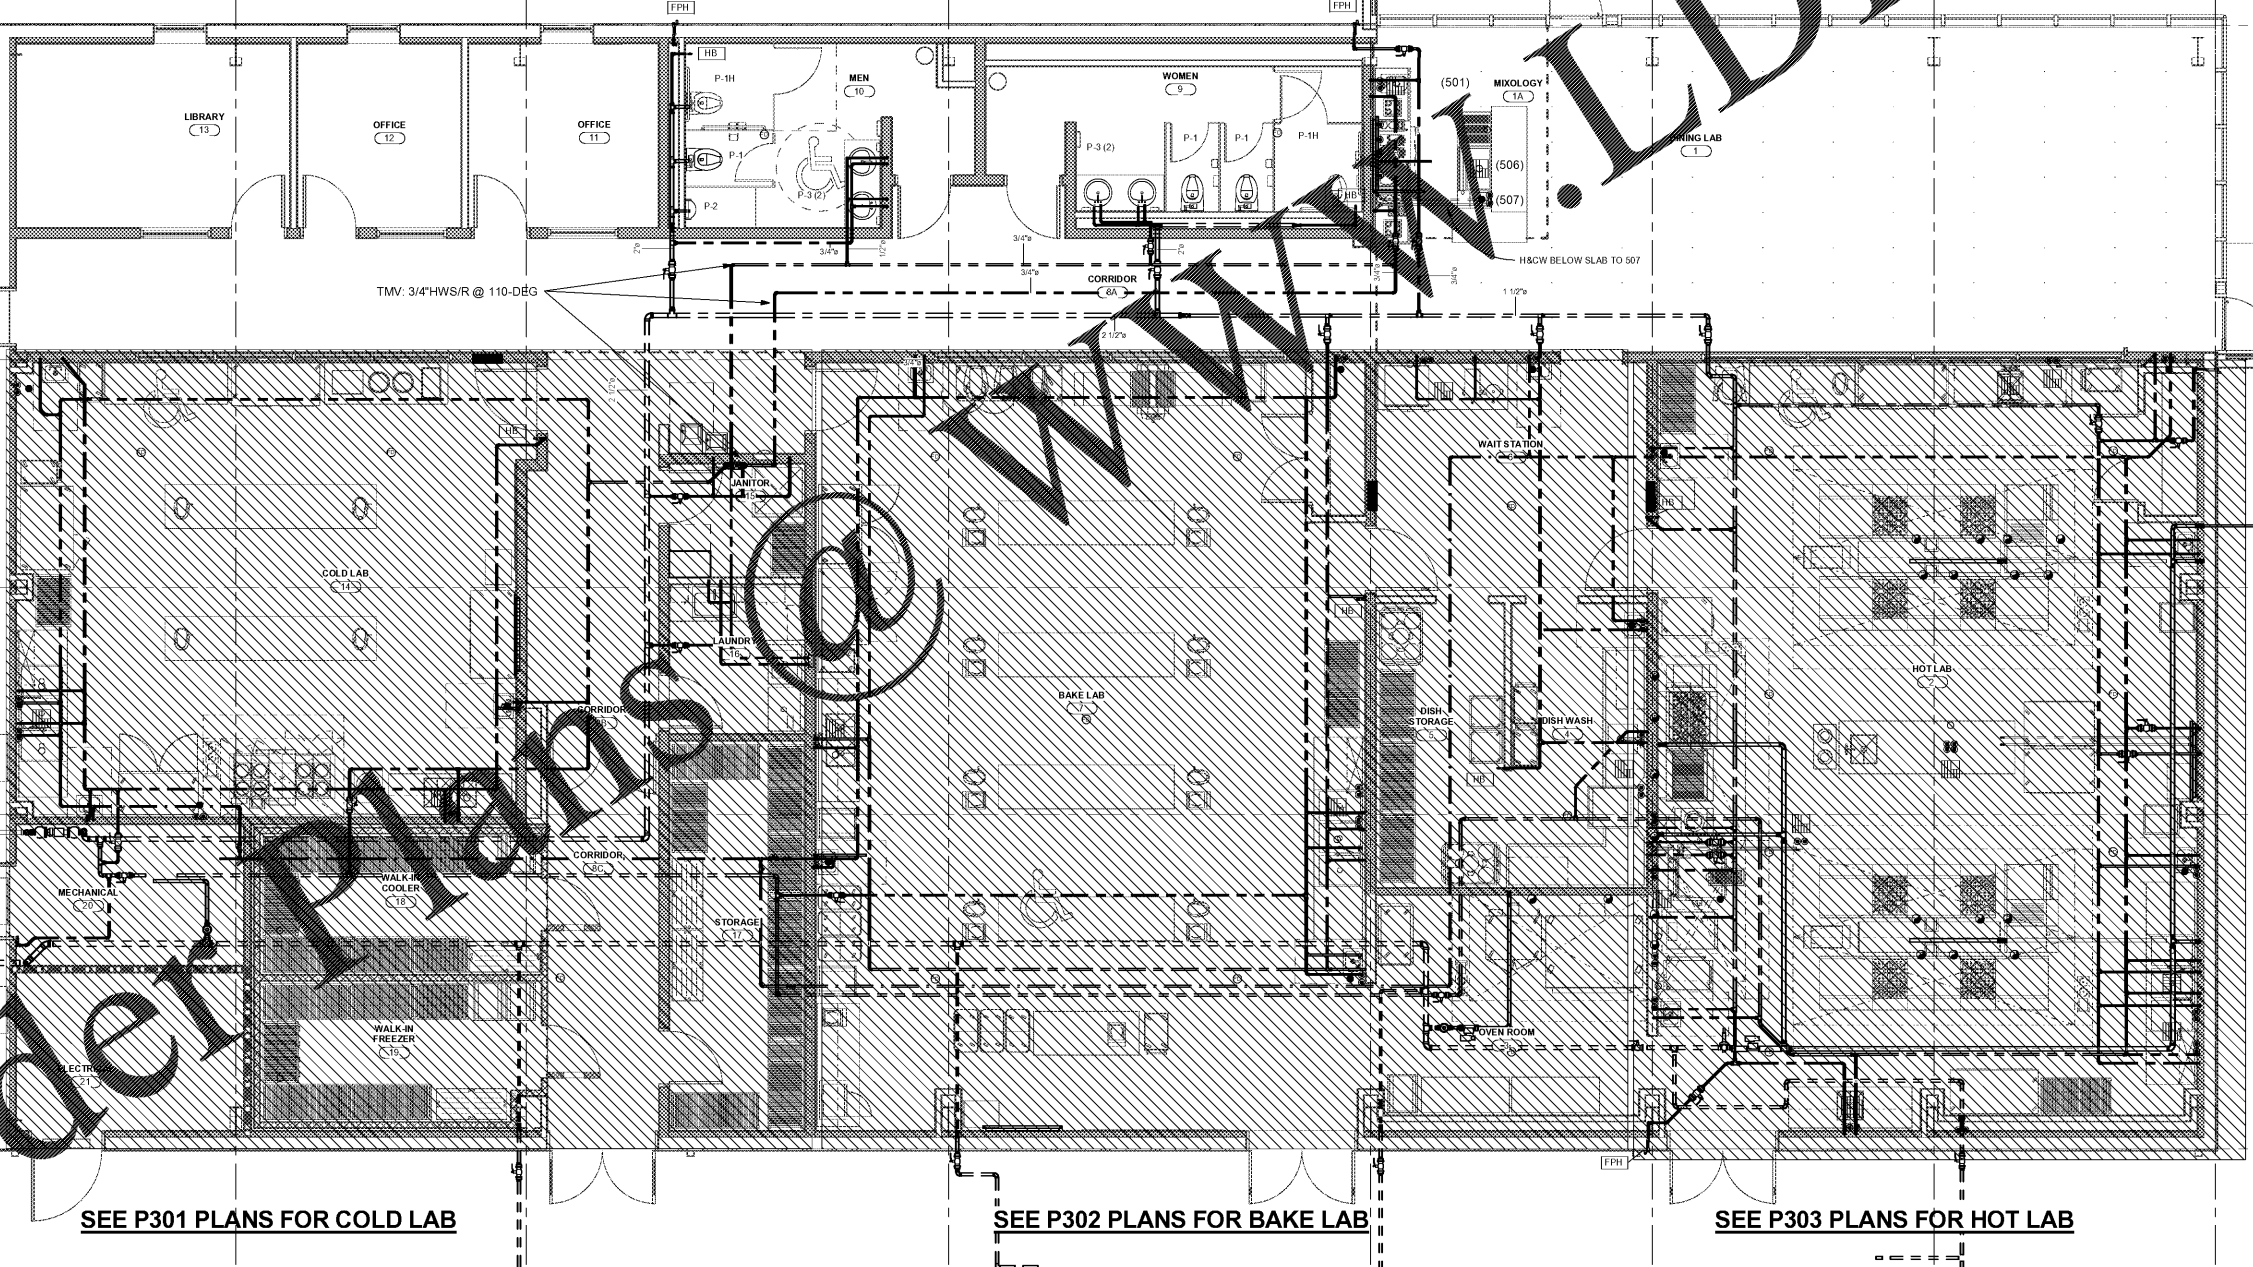

**1 FIRST FLOOR PLAN - WATER**  
 P-300 1/4" = 1'-0"

SEE P301 PLANS FOR COLD LAB

SEE P302 PLANS FOR BAKE LAB

SEE P303 PLANS FOR HOT LAB

C:\Users\shawn\BROW\Documents\17413\_WILKES CC CULINARY LAB\_BROW\_MP\_2016\_brown.rvt  
 1/3/2018 2:03:46 PM