


REVISIONS:

No.	Description	Date

PROJECT: 9202-169779
 DATE: 12/18
 DRAWN BY: CDT
 CHECKED BY: JCC

ENLARGED
 PARTIAL
 FLOOR PLAN -
 WATER & GAS

P-301

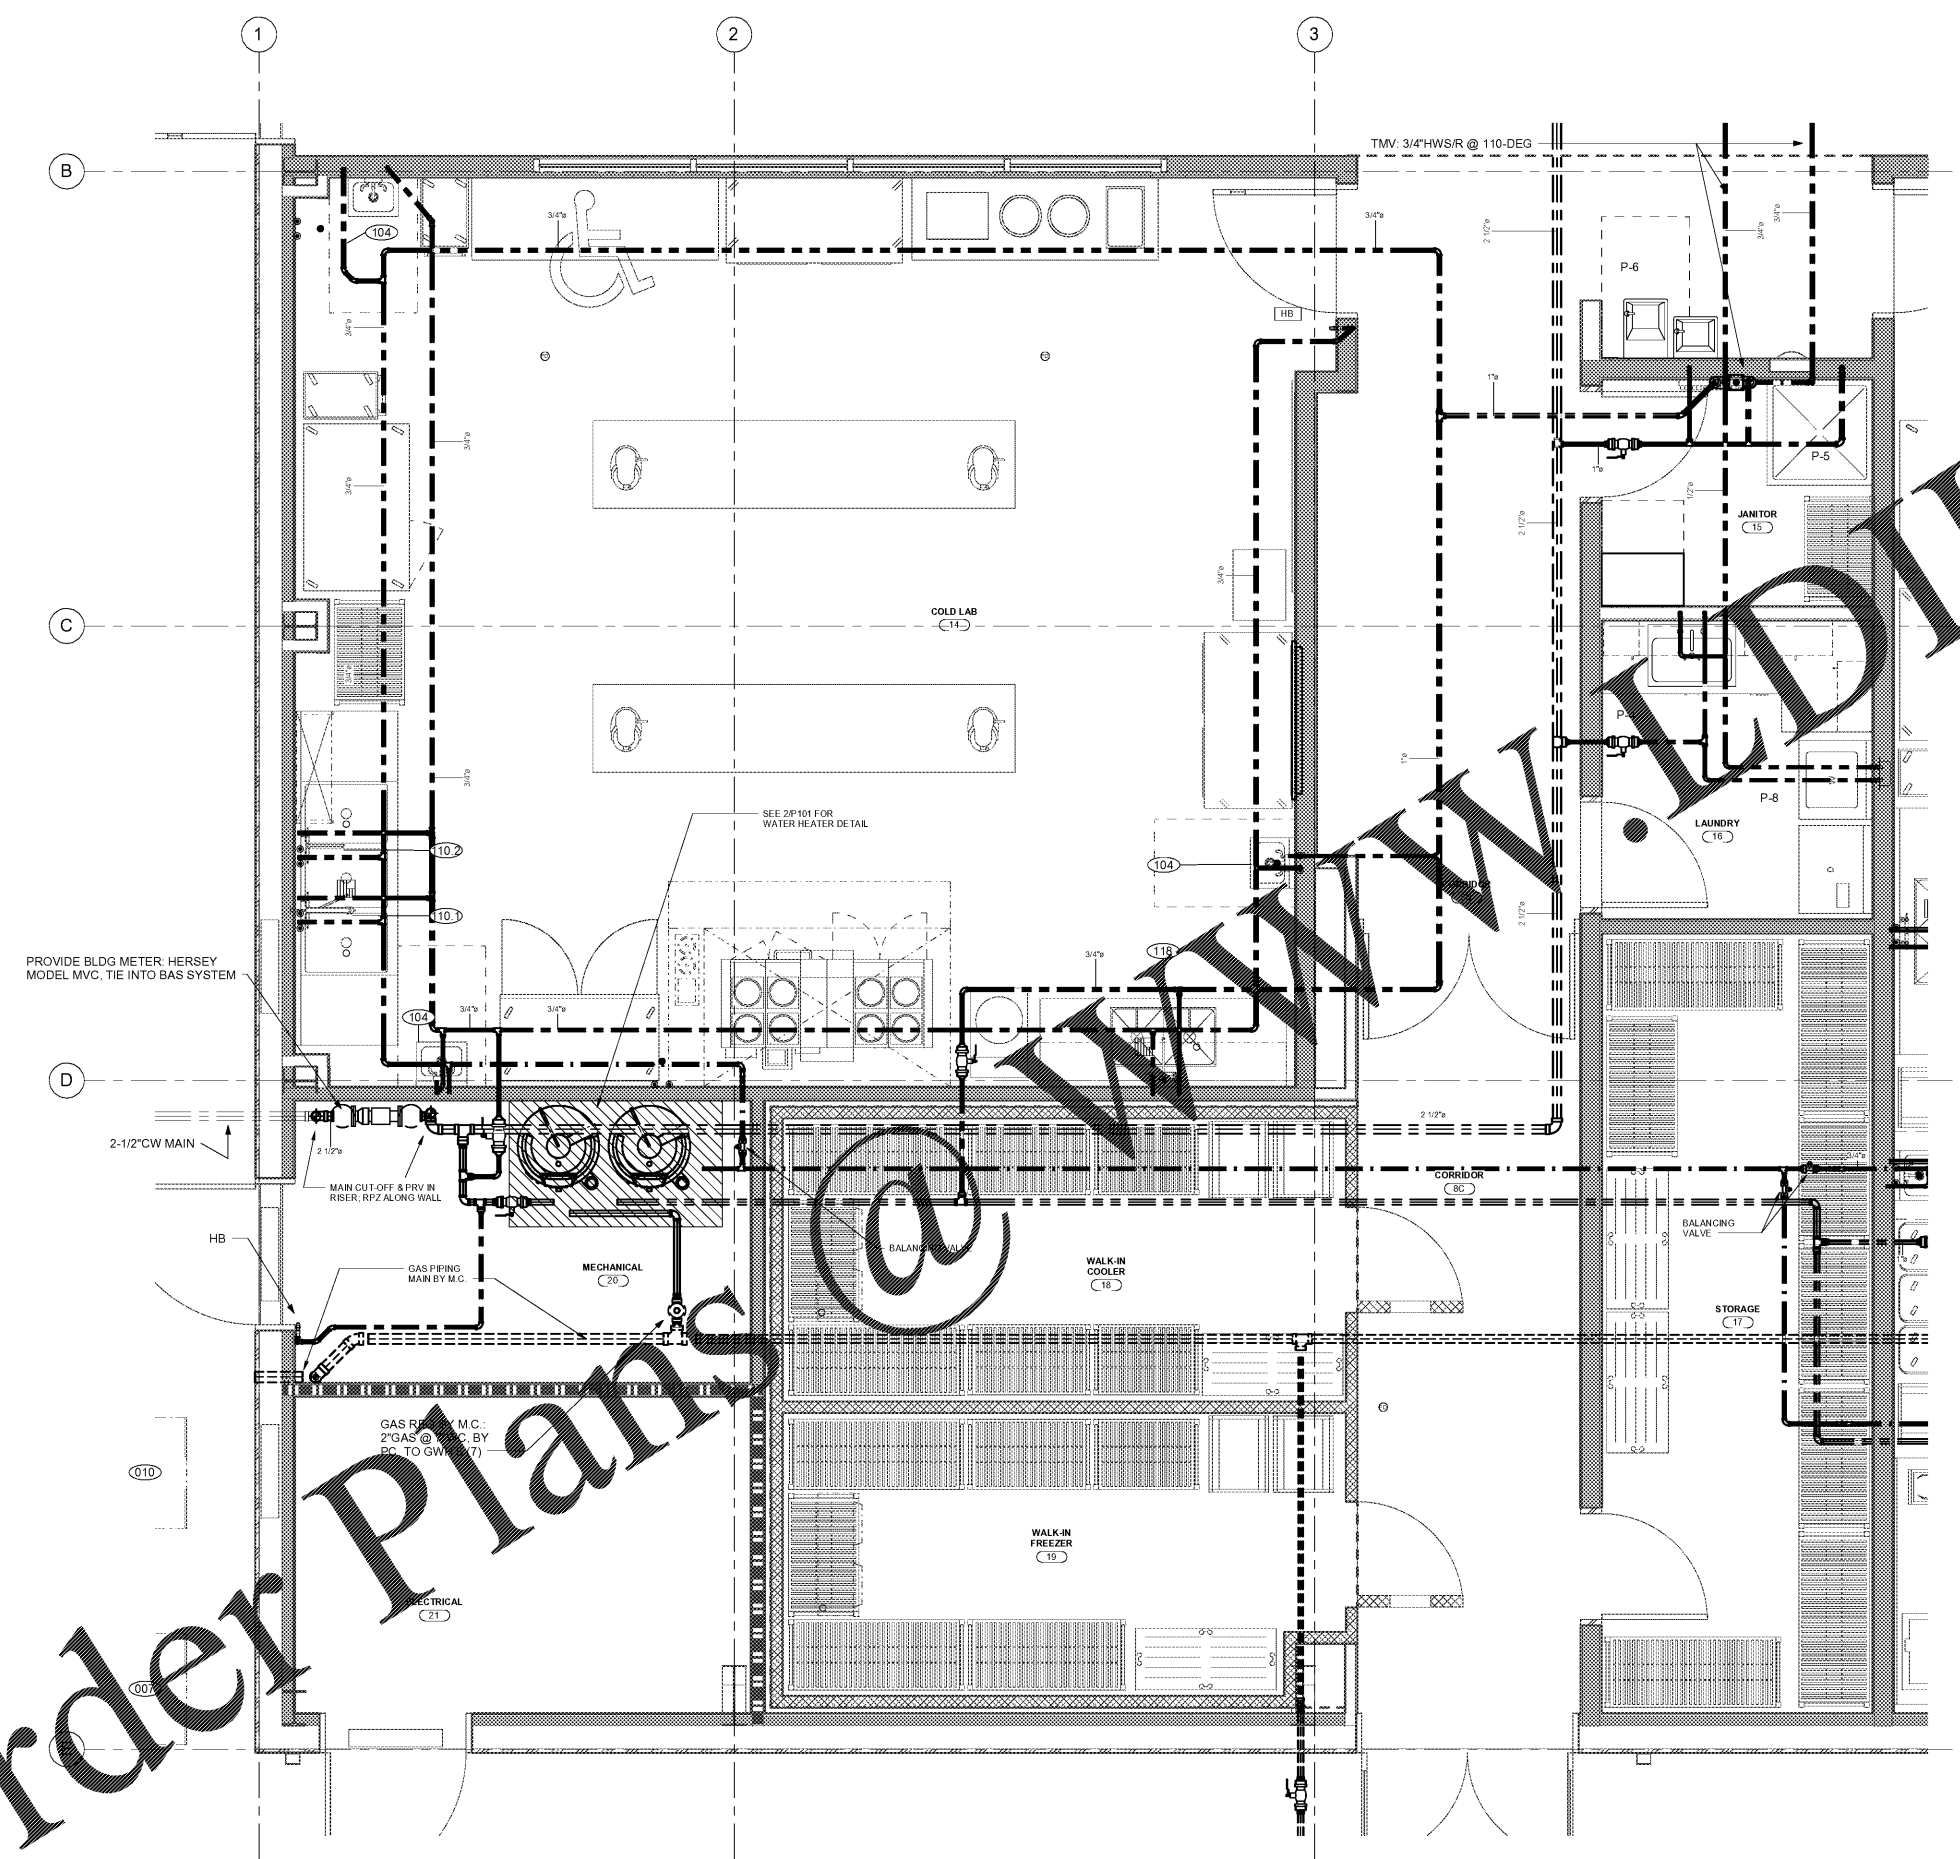

WATER & GAS PIPING LEGEND

	CW
	HW
	HWR
	GAS BY M.C.
	GAS BY PC

1
 P-301
 ENLARGED PARTIAL FLOOR PLAN - COLD LAB & LAUNDRY AREA -
 WATER & GAS
 1/2" = 1'-0"

C:\Users\jbrown\BROW\Documents\17413_WILKES CC CULINARY LAB_IBROWG_MP_2016_brown.rvt
 1/2/2018 2:54:09 PM

Order Plans @ www.wardgriffin.com