



MEMBERS OF THE AMERICAN INSTITUTE OF ARCHITECTS

COPYRIGHT 2018 ALL RIGHTS RESERVED  
 PRINTED OR ELECTRONIC DRAWINGS AND  
 DOCUMENTATION MAY NOT BE REPRODUCED  
 IN ANY FORM WITHOUT WRITTEN PERMISSION  
 FROM LS3P ASSOCIATES LTD.

REVISIONS:


No.	Description	Date

PROJECT: 9202-169779  
 DATE: 12/18  
 DRAWN BY: CDT  
 CHECKED BY: JCC

ENLARGED  
 PARTIAL  
 FLOOR PLAN -  
 WATER & GAS

**P-302**

C:\Users\krowm\OneDrive\Documents\17413\_WILKES CC CULINARY LAB\_IBSWG\_MP\_2018\_brown.rvt  
 1/2/2018 2:54:24 PM

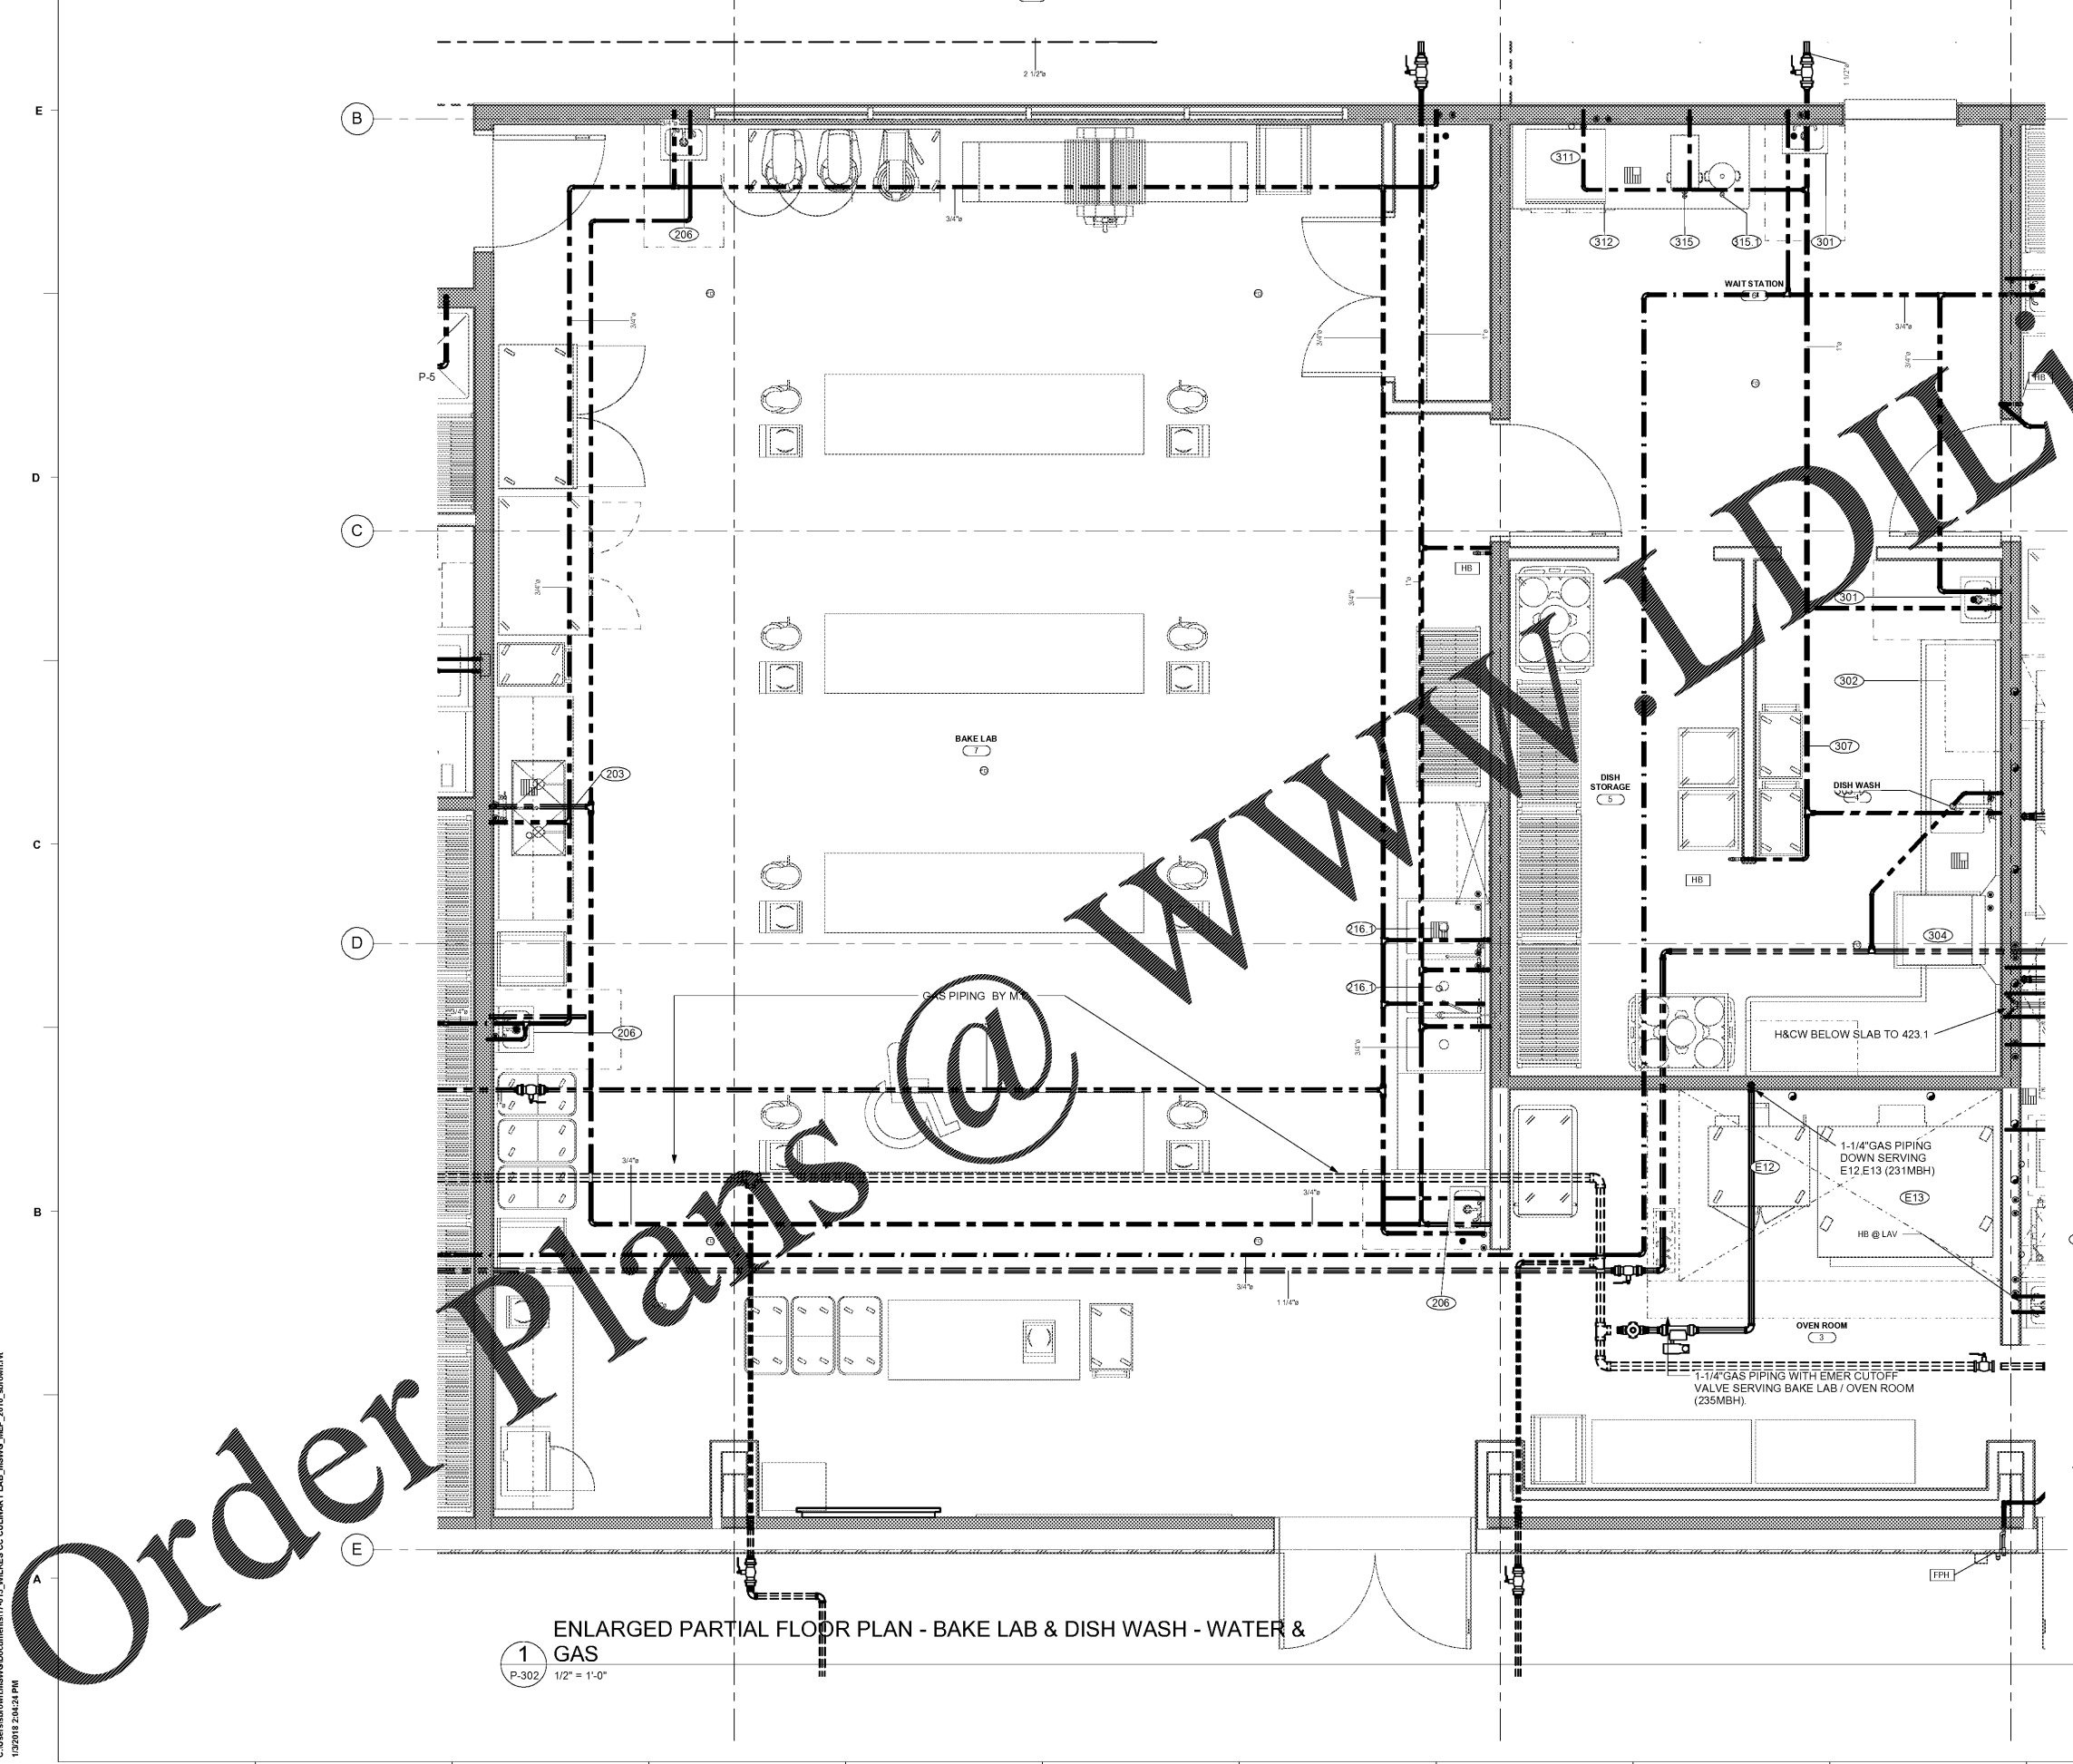

**1**  
 ENLARGED PARTIAL FLOOR PLAN - BAKE LAB & DISH WASH - WATER &  
 GAS  
 P-302 1/2" = 1'-0"

**WATER & GAS PIPING LEGEND**

	CW
	HW
	HWR
	GAS BY M.C.
	GAS BY PC

Order Plans @ [www.LDOnline.com](http://www.LDOnline.com)