



MEMBERS OF THE AMERICAN INSTITUTE OF ARCHITECTS

COPYRIGHT 2016 ALL RIGHTS RESERVED  
 PRINTED OR ELECTRONIC DRAWINGS AND  
 DOCUMENTATION MAY NOT BE REPRODUCED  
 IN ANY FORM WITHOUT WRITTEN PERMISSION  
 FROM LS3P ASSOCIATES LTD.


REVISIONS:

No.	Description	Date

PROJECT: 9202-169779  
 DATE: 12/18  
 DRAWN BY: CDT  
 CHECKED BY: JCC

**ENLARGED  
 PARTIAL  
 FLOOR PLAN -  
 WATER & GAS**

**P-303**

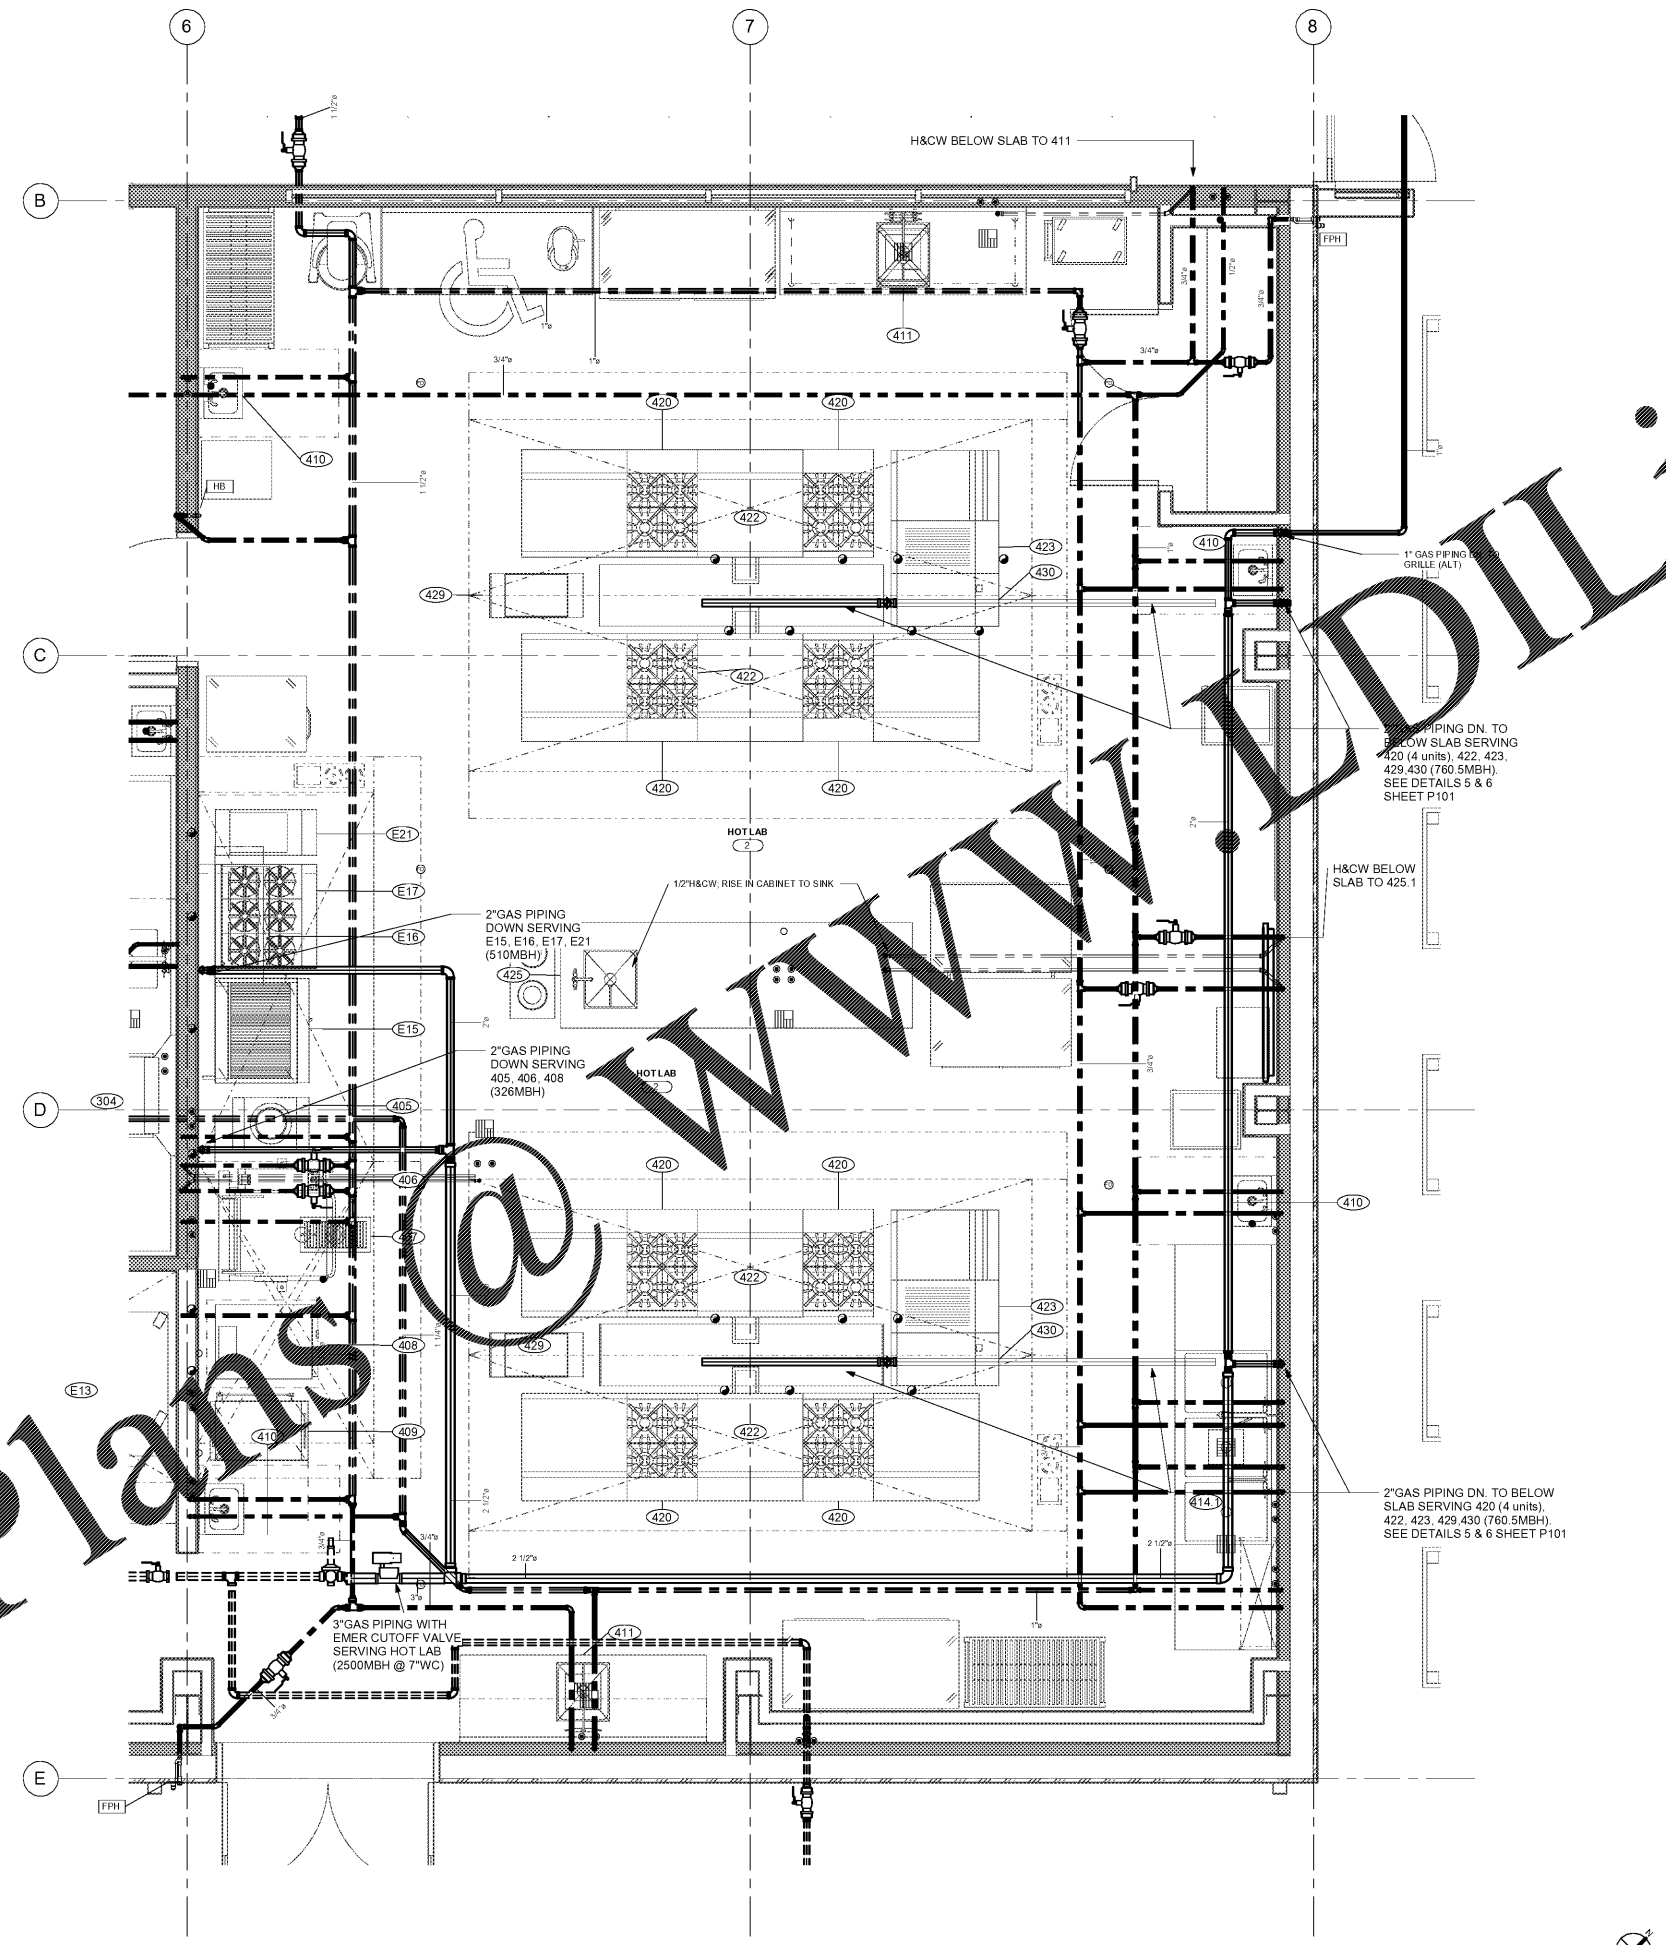

**WATER & GAS PIPING LEGEND**

- — — — — CW
- — — — — HW
- — — — — HWR
- — — — — GAS BY M.C.
- — — — — GAS BY P.C.

**1 ENLARGED PARTIAL FLOOR PLAN - HOT LAB - WATER & GAS**  
 P-303 1/2" = 1'-0"

C:\Users\krowm\BIBW\Documents\17413\_WILKES CC CULINARY LAB\_BIBW\MP\_2016\_brown.rvt  
 1/27/18 2:54:43 PM

Order Plans @ [www.LDLine.com](http://www.LDLine.com)