


C:\Users\slawna\BROW\Documents\17413_WILKES CC CULINARY LAB_BROW_MP_2016_brown.rvt
1/2/2018 1:53:51 PM

E
D
C
B
A

1 2 3 4 5 6

Order Plans @

WWW.LDILine.com

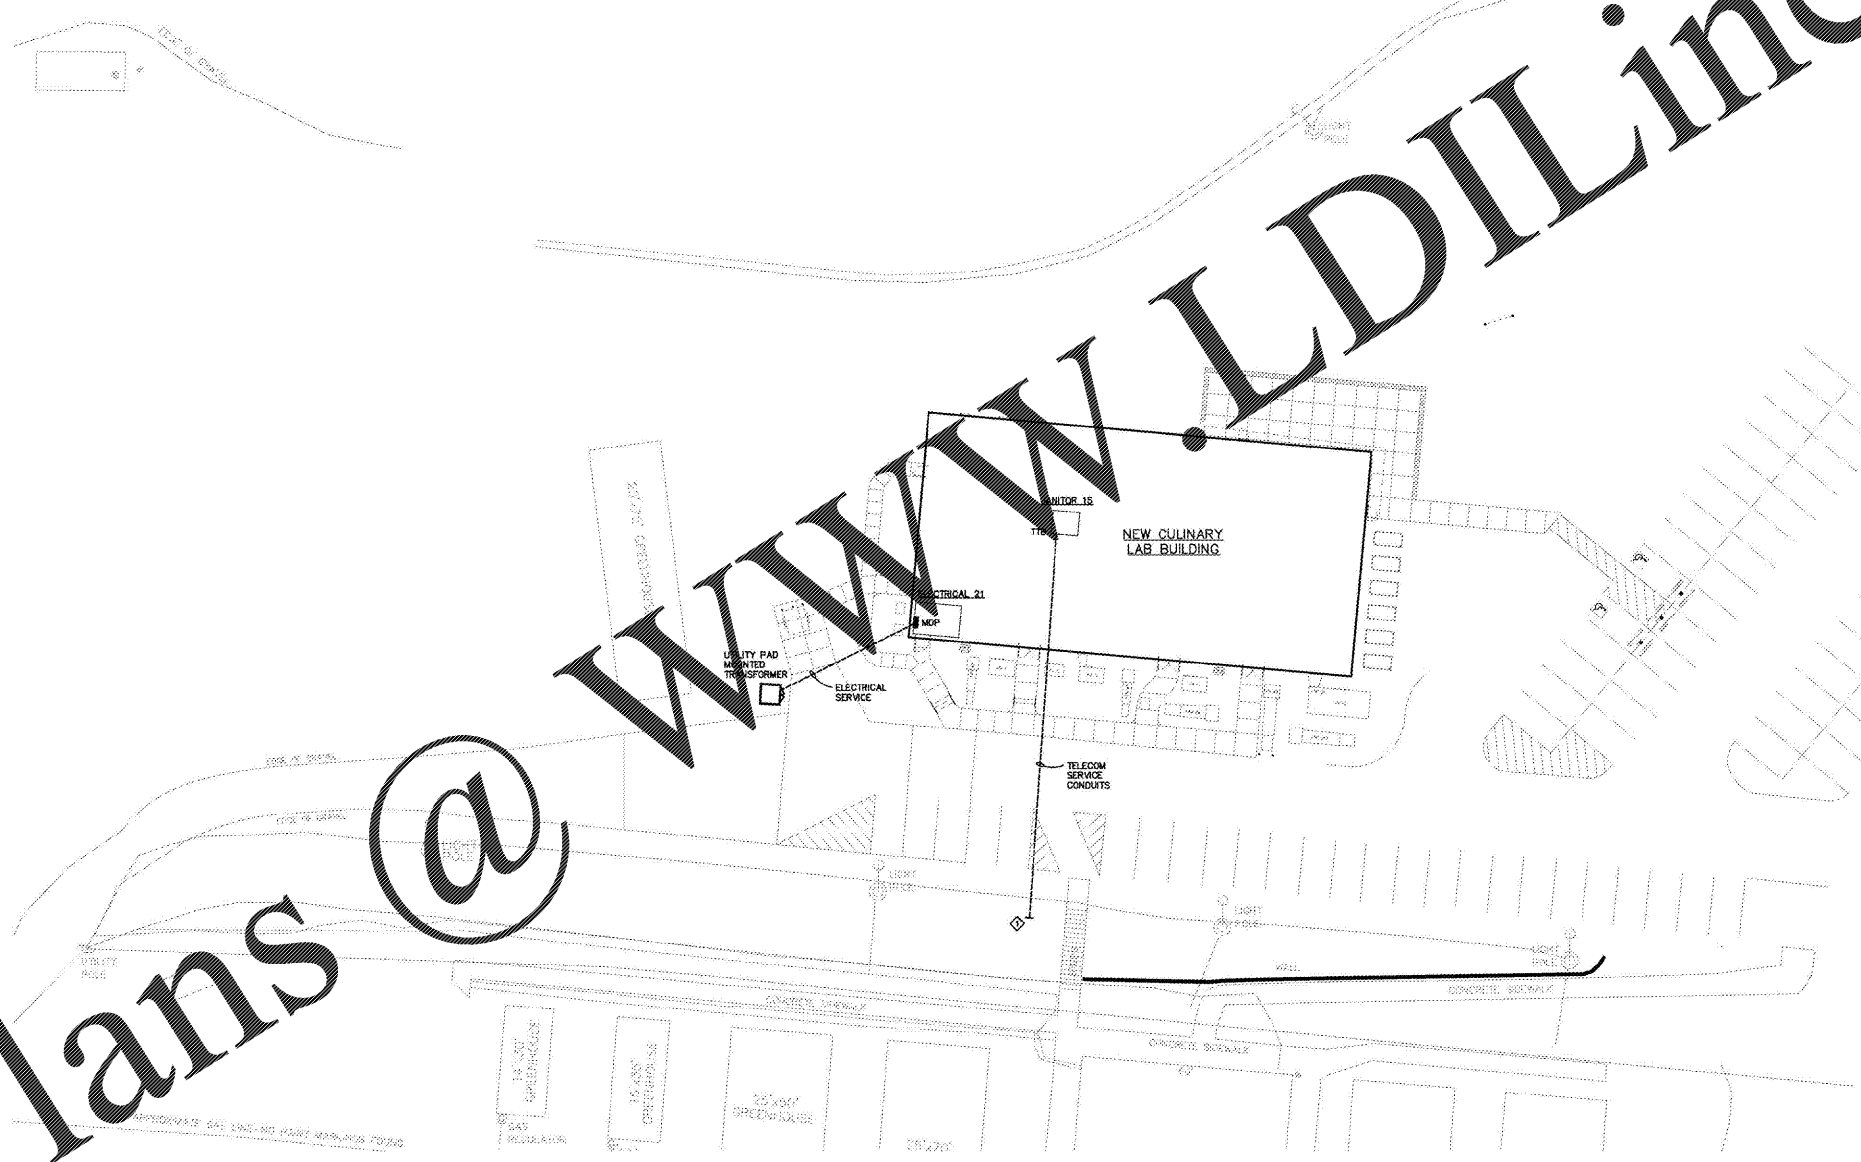

1 SITE PLAN - ELECTRICAL
E-101 SCALE: 1" = 20'-0"
NOTES:
◇ COORDINATE EXACT LOCATION OF SERVICE CONDUIT TERMINATION WITH UTILITY.

WILKES COMMUNITY COLLEGE
WILKES COMMUNITY COLLEGE
SCO# 17413-01A
NCCOS# 226

CULINARY LAB

McKNIGHT · SMITH
WARD · GRIFFIN
ENGINEERS, INCORPORATED
PO Box 245209 • 4223 South Boulevard
Charlotte, NC 28224
704/333-2812 17-013

LS3P

227 WEST TRADE STREET SUITE 700
CHARLOTTE, NORTH CAROLINA 28202
TEL. 704.333.6696 FAX 704.333.2926
WWW.LS3P.COM



MEMBERS OF THE AMERICAN INSTITUTE OF ARCHITECTS

COPYRIGHT 2016 ALL RIGHTS RESERVED
PRINTED OR ELECTRONIC DRAWINGS AND
DOCUMENTATION MAY NOT BE REPRODUCED
IN ANY FORM WITHOUT WRITTEN PERMISSION
FROM LS3P ASSOCIATES LTD.

REVISIONS:

No.	Description	Date

PROJECT: 9202-16979
DATE: 1/2/18
DRAWN BY: Author
CHECKED BY: Checker

SITE PLAN -
ELECTRICAL

E-101