



MEMBERS OF THE AMERICAN INSTITUTE OF ARCHITECTS


COPYRIGHT 2016 ALL RIGHTS RESERVED
 PRINTED OR ELECTRONIC DRAWINGS AND DOCUMENTATION MAY NOT BE REPRODUCED IN ANY FORM WITHOUT WRITTEN PERMISSION FROM LS3P ASSOCIATES LTD.

REVISIONS:

No.	Description	Date

PROJECT: 9202-169779
 DATE: 12/18
 DRAWN BY: SHS
 CHECKED BY: MPA

FLOOR PLAN - LIGHTING
E-201

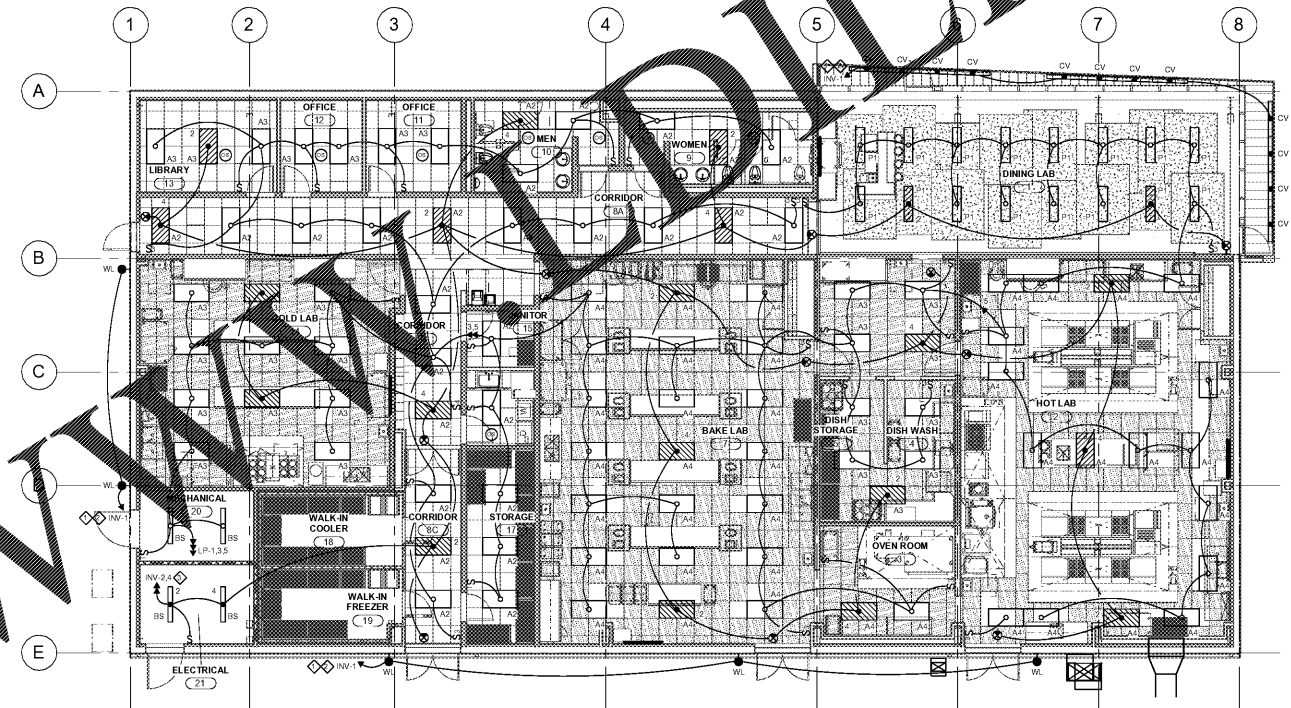

1 FIRST FLOOR PLAN - LIGHTING

E-201 1/8" = 1'-0"

NOTES:

- ◇ ROUTE CIRCUIT THROUGH EXTERIOR LIGHTING CON FACTOR, E.L.C. REFER TO EXTERIOR LIGHTING CONTROL DIAGRAM FOR ADDITIONAL INFORMATION.
- ◇ CONNECT WITH 1#12, 1#12N, 1#12G, 12°C TO 201 CIRCUIT BREAKER IN EMERGENCY LIGHTING INVERTER. REFER TO SPECIFICATION FOR ADDITIONAL INFORMATION.
- ◇ CONNECT WITH 2#12, 2#12N, 1#12G, 12°C TO 201 CIRCUIT BREAKERS IN EMERGENCY LIGHTING INVERTER. REFER TO SPECIFICATION FOR ADDITIONAL INFORMATION.



FIRE RATED WALLS
 1 HOUR WALL

IT IS THE RESPONSIBILITY OF THE CONTRACTOR TO APPLY THE PROPER FIRE-RATING DETAIL FOR ALL DUCT AND PIPE PENETRATIONS THROUGH RATED & NON-RATED WALL AND FLOOR/CILING ASSEMBLIES.

Order Plans @ WAWM@WAWMOnline.com