



MEMBERS OF THE AMERICAN INSTITUTE OF ARCHITECTS


COPYRIGHT 2016 ALL RIGHTS RESERVED  
 PRINTED OR ELECTRONIC DRAWINGS AND DOCUMENTATION MAY NOT BE REPRODUCED IN ANY FORM WITHOUT WRITTEN PERMISSION FROM LS3P ASSOCIATES LTD.

REVISIONS:

No.	Description	Date

PROJECT: 9202-169779  
 DATE: 12/18  
 DRAWN BY: SHW  
 CHECKED BY: MPA


FLOOR PLAN - POWER  
**E-301**

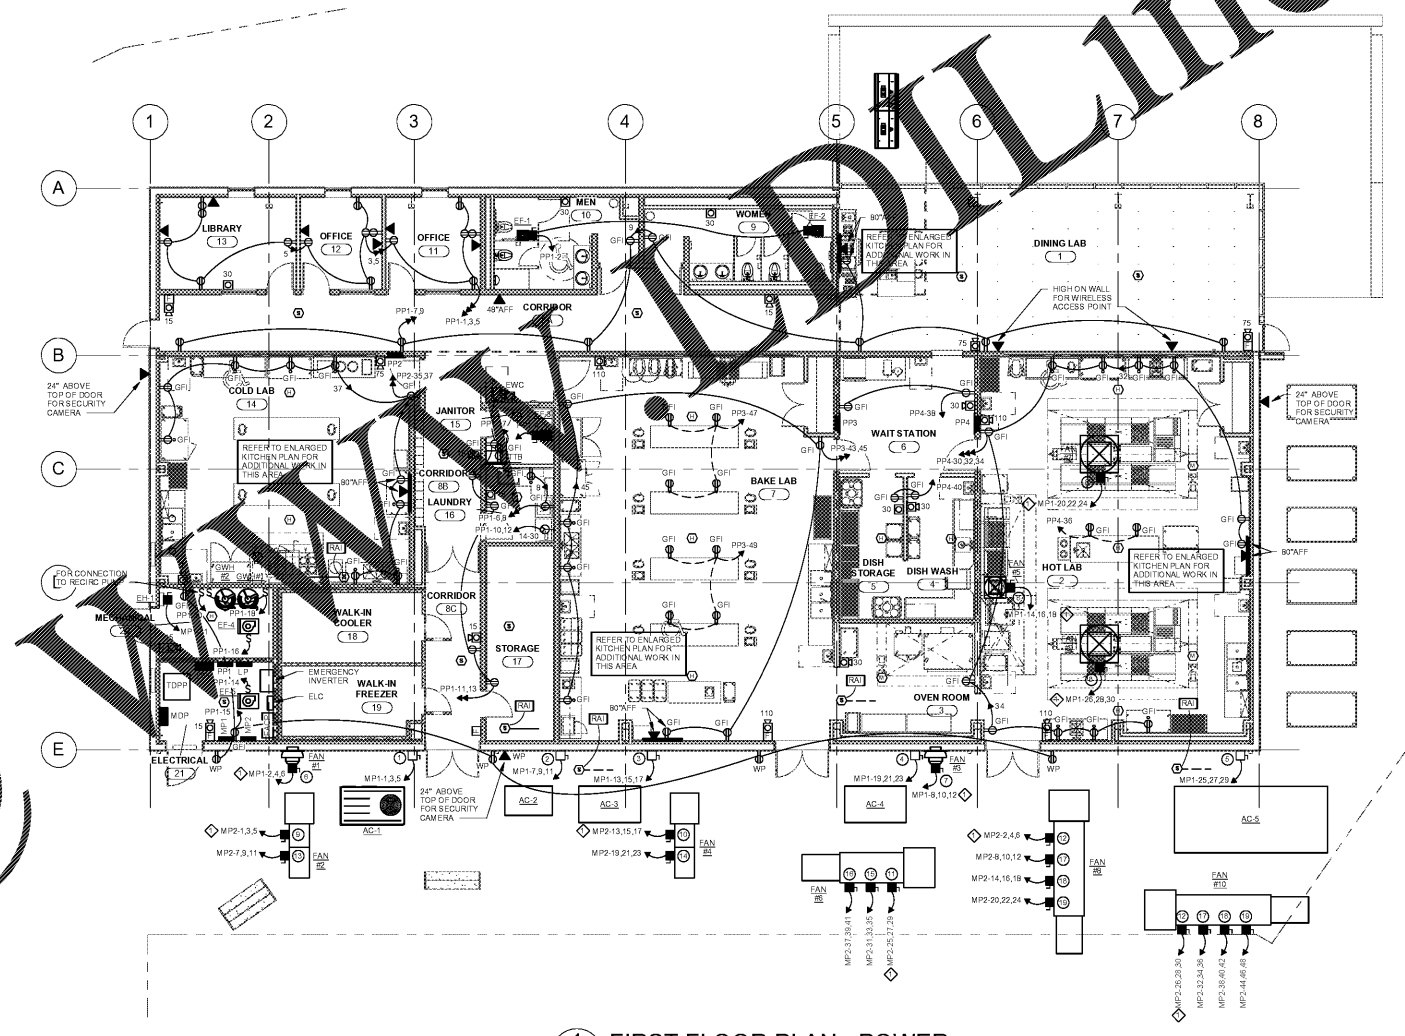

**1 FIRST FLOOR PLAN - POWER**  
 E-301 1/8" = 1'-0"

NOTES:  
 ◇ ROUTE CIRCUIT THROUGH ASSOCIATED HOOD CONTROL PANEL.

 **BASE BID: NO FIRE ALARM SYSTEM SHALL BE INSTALLED.  
 ALTERNATE #1: INSTALL FIRE ALARM SYSTEM AS INDICATED.**



Order Plans @