



The information contained herein is the property of Johnson, Levinson, Ragan, Davila, Inc. (JLRD) and is provided by copyright. Unauthorized use or reproduction is prohibited. JLRD makes no warranty or guarantee as to the accuracy or completeness of the information contained herein, and assumes no liability for damages of any kind resulting from any use, and shall be deemed to have accepted the responsibility of the user.

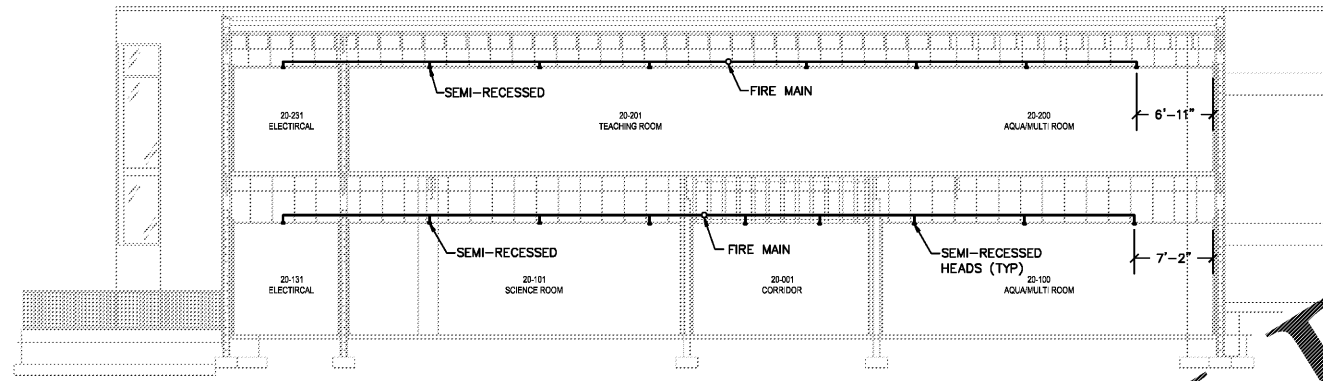

2 FIRST FLOOR FIRE PROTECTION PLAN  
FP2.1

SCALE: 1/8"=1'-0"

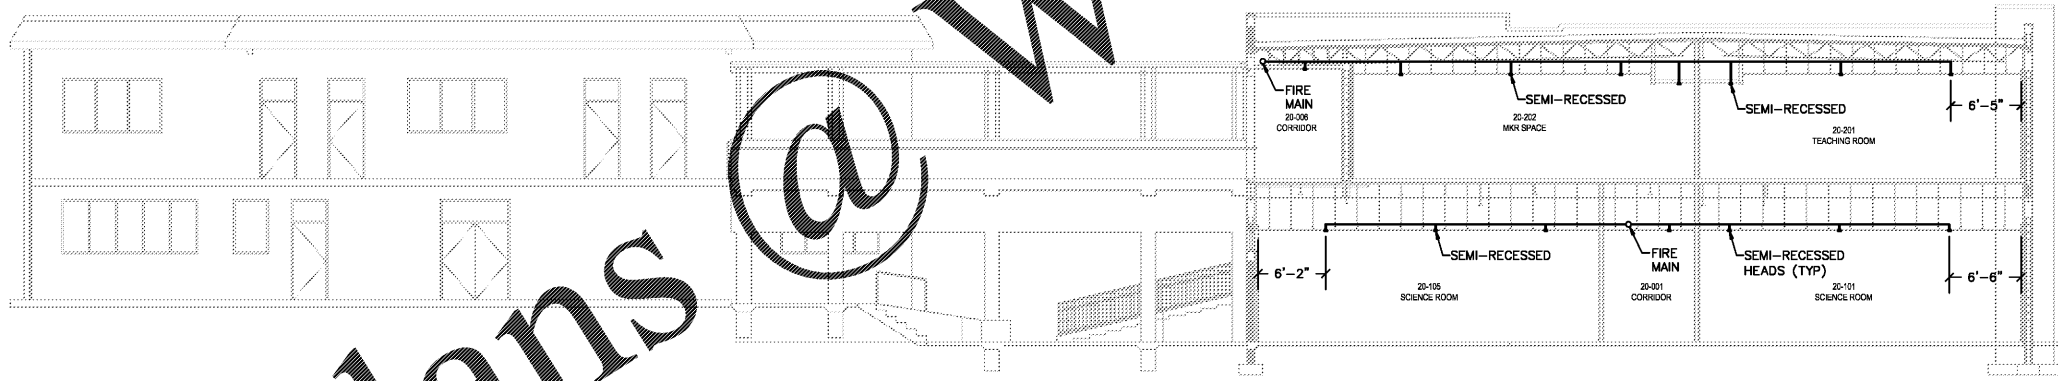

1 FIRE PROTECTION SECTIONS  
FP2.1

SCALE: 1/8"=1'-0"

Order Plans @

WWW.LDILine.com

**HARVARD • JOLLY**  
ARCHITECTURE  
2047 VISTA PARKWAY, SUITE 100 | WEST PALM BEACH, FL 33411  
561-478-4457 | www.harvardjolly.com | AAC000119

**JLRD**  
JOHNSON, LEVINSON  
RAGAN, DAVILA, INC.  
1450 Centrepark Boulevard, Suite 350  
West Palm Beach, Florida 33401  
(561) 699-2303 (561) 699-2302 Fax  
www.jlr.com  
Certification Number 6039  
Michael P. Landrum, P.E., 30594  
Charles C. Chubberson, P.E., 31936

STEM BUILDING  
THE BENJAMIN SCHOOL - LOWER/MIDDLE SCHOOL  
11000 Ellison Wilson Road, North Palm Beach, FL 33408  
CONSTRUCTION DOCUMENTS

Comm. No: 16117.00  
Job No: 117030  
Date: 10-23-17  
Drawn: BAR

| Revisions |      |      |
|-----------|------|------|
| No.       | Date | Note |
|           |      |      |
|           |      |      |
|           |      |      |
|           |      |      |

TO THE BEST OF MY KNOWLEDGE, THE PLANS AND SPECIFICATIONS COMPLY WITH THE MINIMUM BUILDING CODES.

© 2017 HARVARD JOLLY, INC.

JLRD Project #117030

FP2.1