


This information is intended for the professional use of the engineer or architect and is not to be construed as a contract or part of a contract. It is the responsibility of the user to verify the accuracy of the information and to coordinate with all other project documents. The user hereby agrees to hold the engineer or architect harmless for any and all claims, damages, and expenses, including reasonable attorneys' fees, arising from the use of this information in any way.

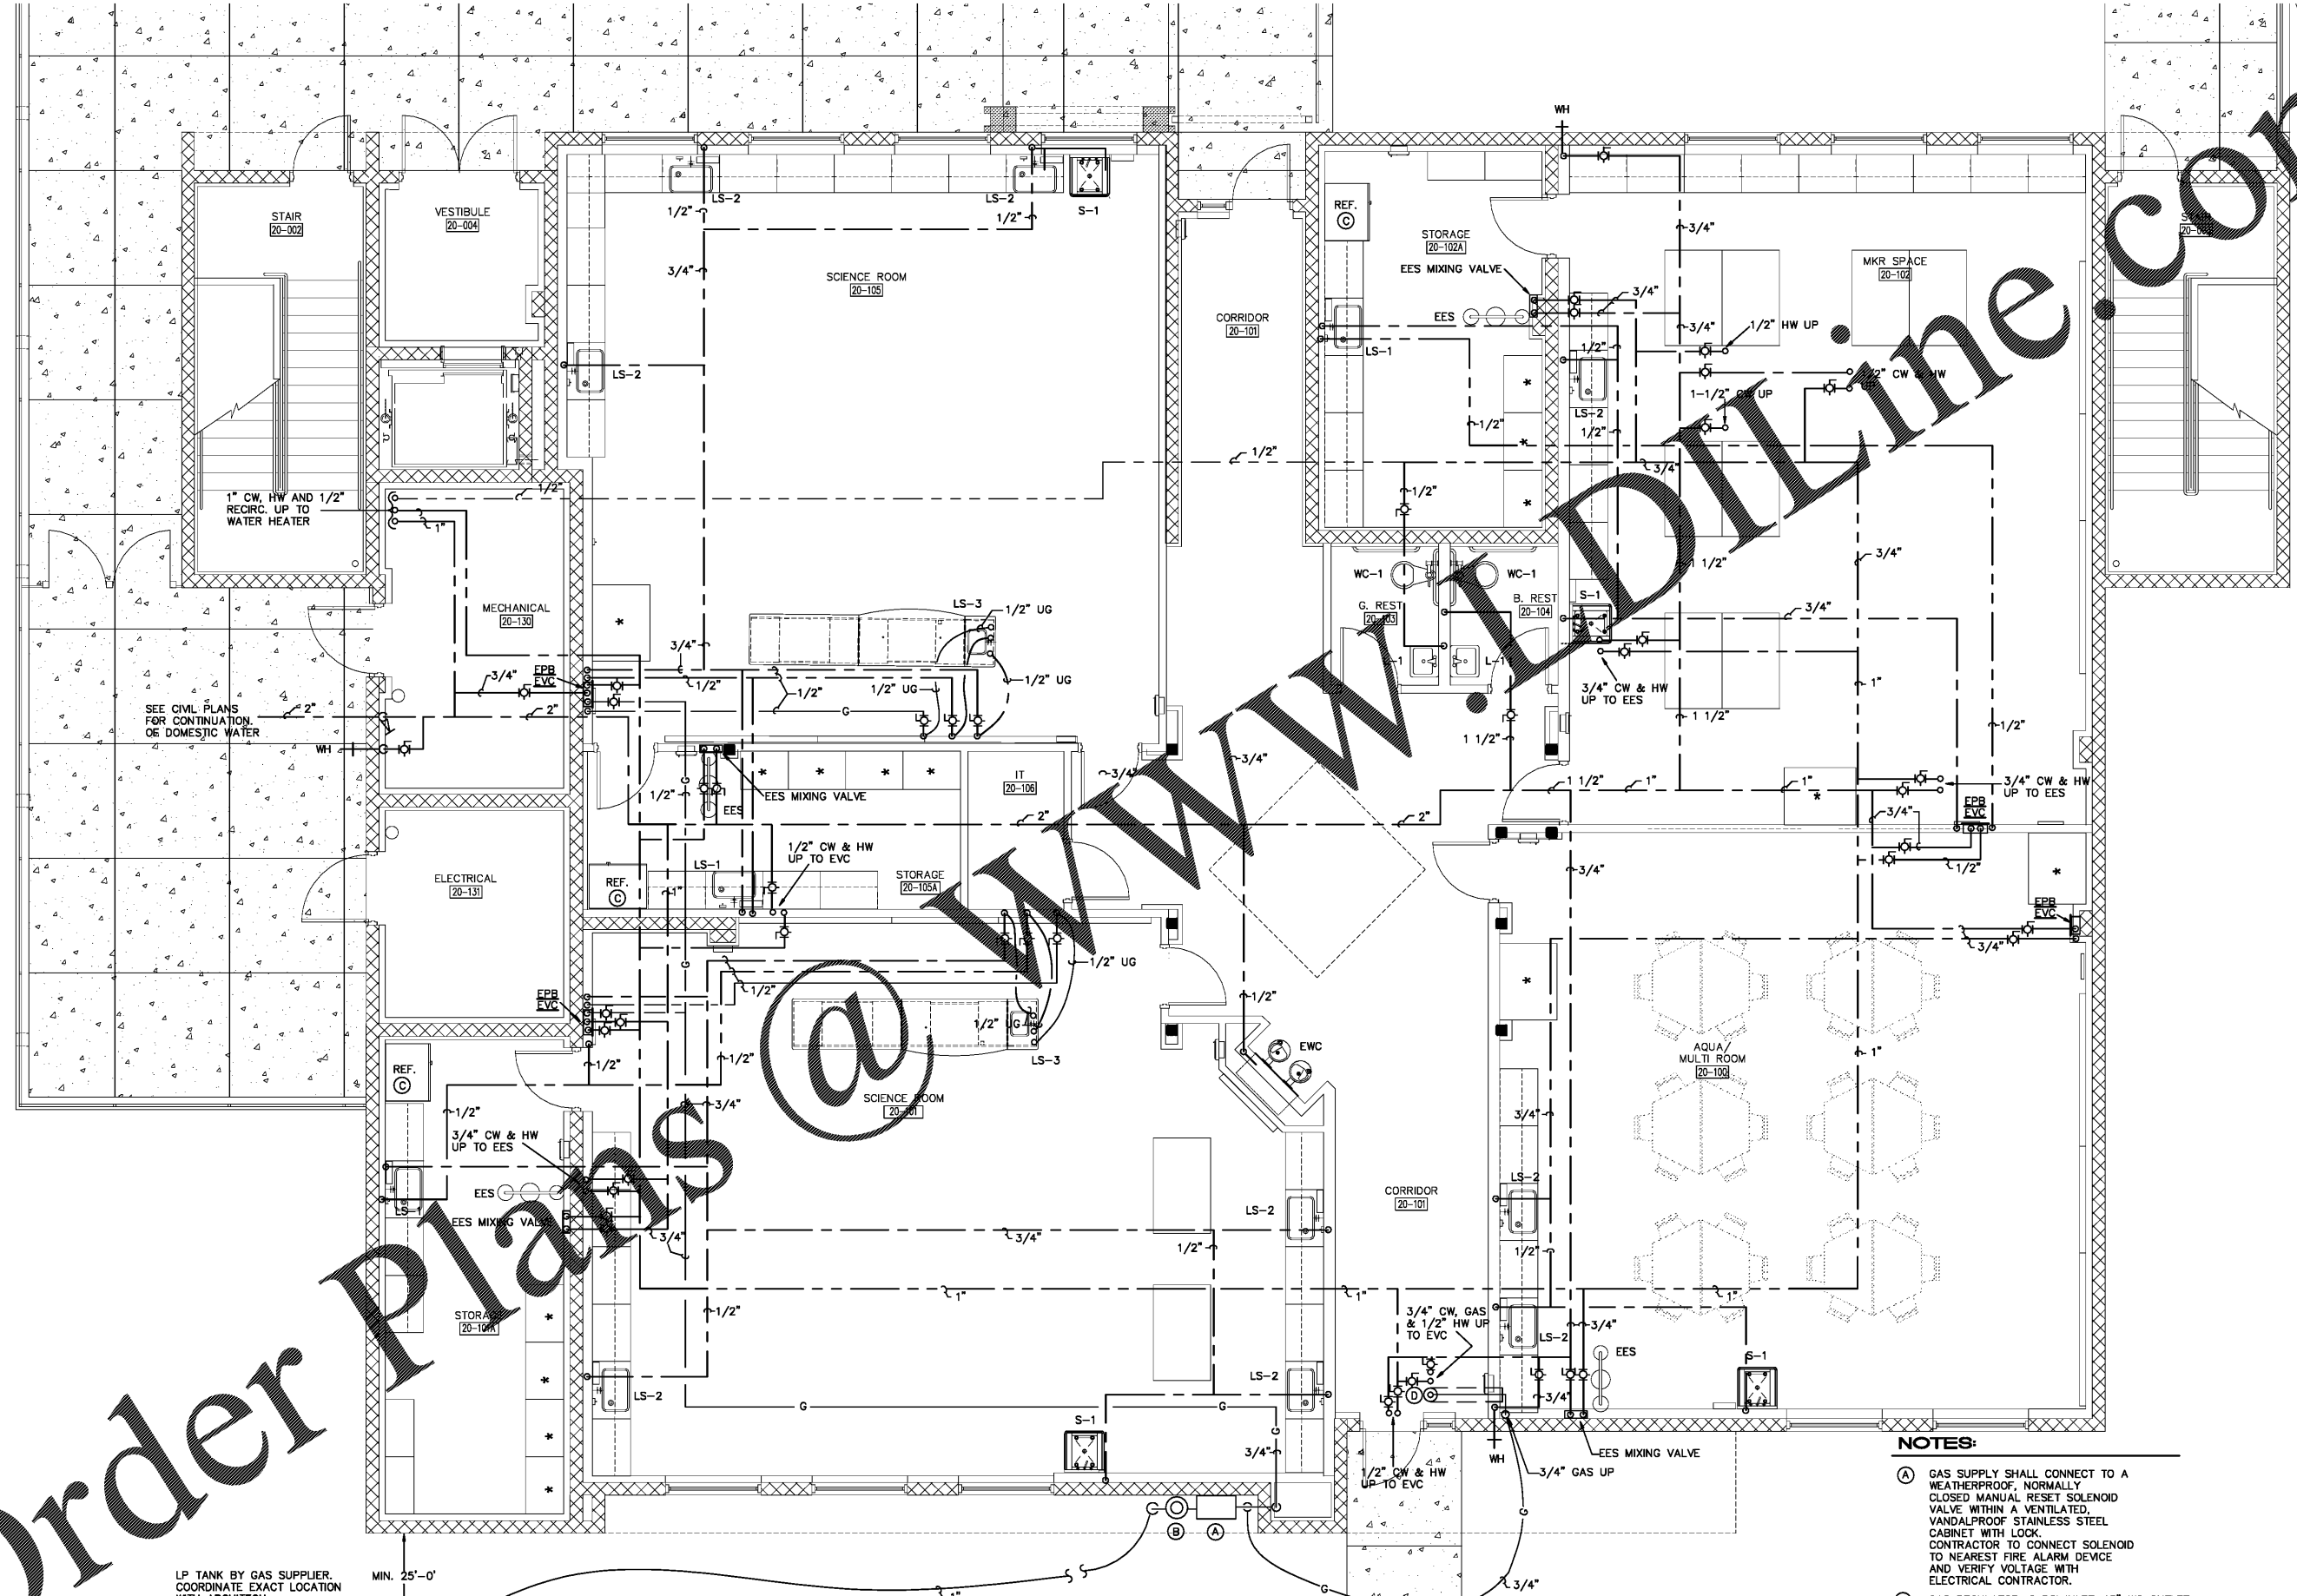

# Order Plans

**FIRST FLOOR WATER and GAS PLUMBING PLAN**

SCALE: 1/4"=1'-0"

- NOTES:**
- (A) GAS SUPPLY SHALL CONNECT TO A WEATHERPROOF, NORMALLY CLOSED MANUAL RESET SOLENOID VALVE WITHIN A VENTILATED, VANDALPROOF STAINLESS STEEL CABINET WITH LOCK. CONTRACTOR TO CONNECT SOLENOID TO NEAREST FIRE ALARM DEVICE AND VERIFY VOLTAGE WITH ELECTRICAL CONTRACTOR.
  - (B) GAS REGULATOR, 2 PSI INLET, 15" WC OUTLET.
  - (C) PROVIDE 1/4" LINE TO ICE MAKER IN REFRIG. WITH SHUT OFF VALVE LOCATED UNDER ADJ. SINK.
  - (D) 3/4" GAS LINE UP TO EVC. ROUTE LINE IN A C.I. SLEEVE OVER CORR. FIRE CAULK SLEEVE AT WALL AND 2ND FLOOR.

Contract No.	16117.00	
Job No.	117030	
Date	10-23-17	
Drawn	GSQ	
Revisions		
No.	Date	Note

TO THE BEST OF MY KNOWLEDGE, THE PLANS AND SPECIFICATIONS COMPLY WITH THE MINIMUM BUILDING CODES.