


This information is for informational purposes only. It is not intended to be used as a contract or to replace the contract documents. The user hereby agrees to hold the architect harmless for any and all claims, damages, losses, or expenses, including reasonable attorneys' fees, that may be incurred by the user in reliance on this information. The user hereby agrees to hold the architect harmless for any and all claims, damages, losses, or expenses, including reasonable attorneys' fees, that may be incurred by the user in reliance on this information.

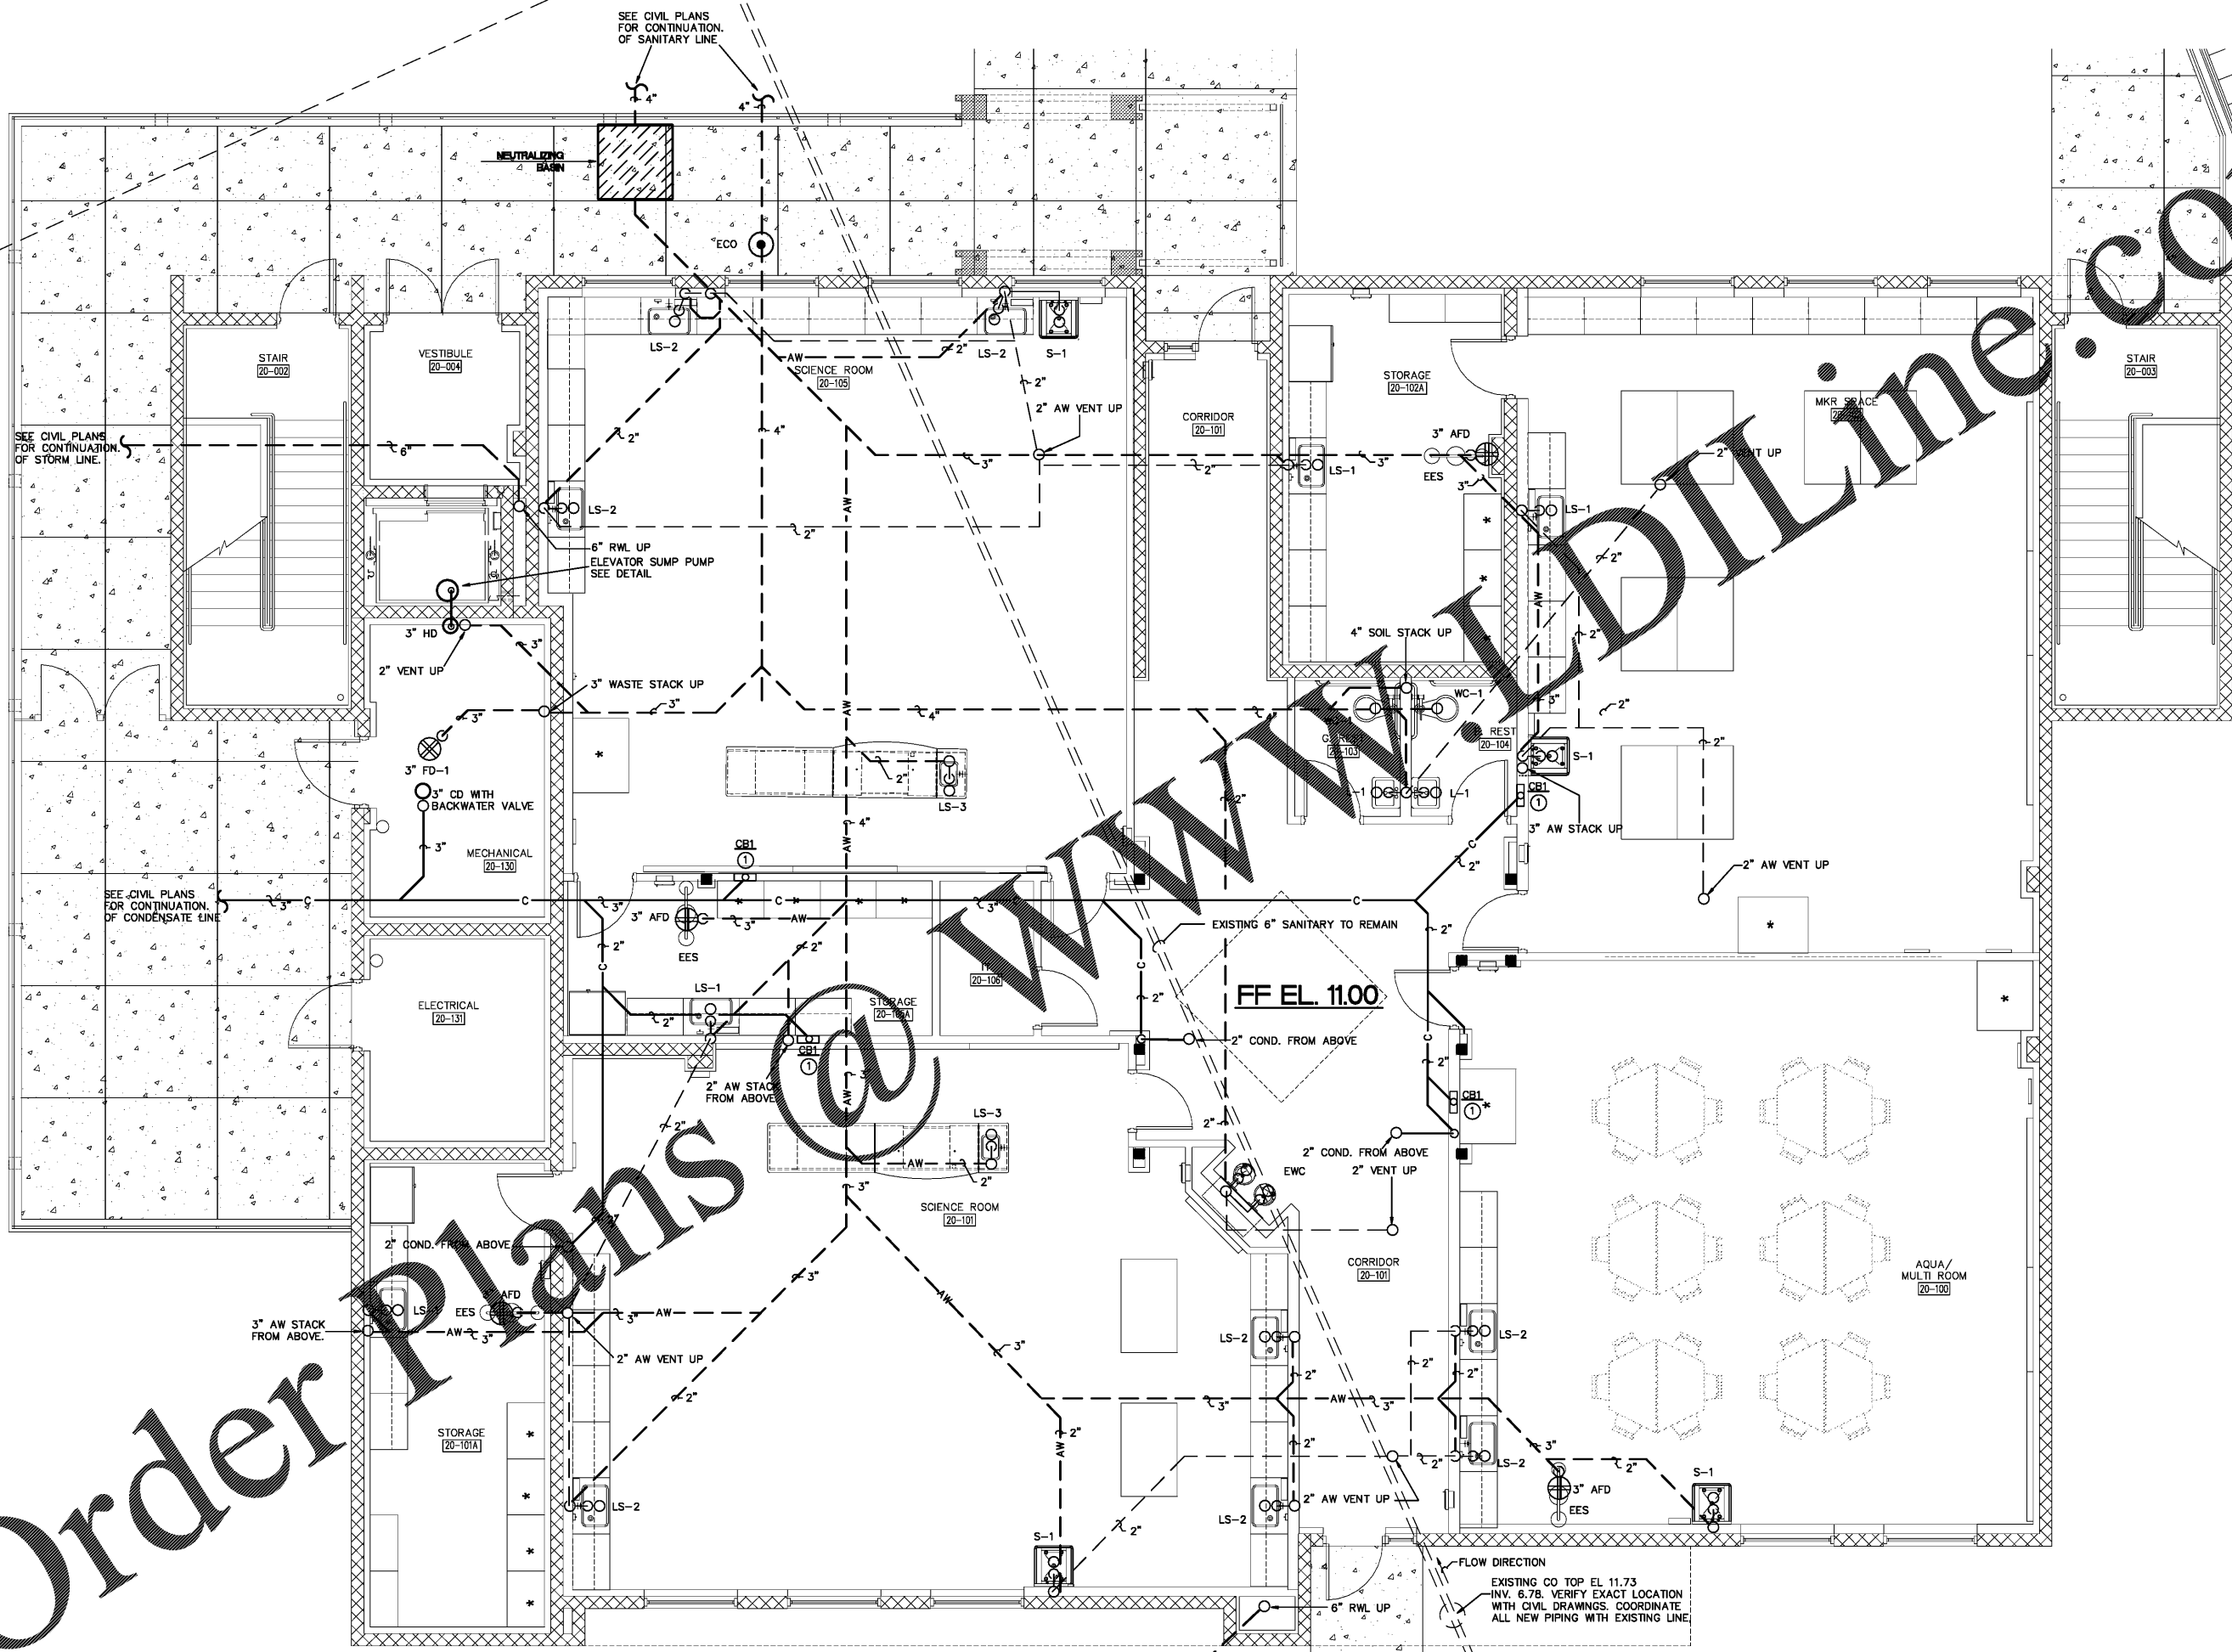

Order Plans

SEE CIVIL PLANS FOR CONTINUATION OF STORM LINE.

SEE CIVIL PLANS FOR CONTINUATION OF SANITARY LINE.

SEE CIVIL PLANS FOR CONTINUATION OF CONDENSATE LINE.

FF EL. 11.00

FLOW DIRECTION
EXISTING CO TOP EL 11.73
INV. 6.78. VERIFY EXACT LOCATION
WITH CIVIL DRAWINGS. COORDINATE
ALL NEW PIPING WITH EXISTING LINE.

SEE CIVIL PLANS FOR CONTINUATION.

FIRST FLOOR SANITARY and VENT PLUMBING PLAN

SCALE: 1/4"=1'-0"

HARVARD • JOLLY
ARCHITECTURE
2047 VISTA PARKWAY, SUITE 100 | WEST PALM BEACH, FL 33411
561-478-4457 | www.harvardjolly.com | AAC000119

J L R D
JOHNSON, LEVINSON
RAJAN, DAVILA, INC.
CONSULTING ENGINEERS
1450 Centrepark Boulevard, Suite 350
West Palm Beach, Florida 33401
(561) 689-2303 (561) 689-2302 Fax
www.jldr.com
Certification Number 60599
Michael P. Landrum, P.E. 50594
Charles C. Chubberson, P.E. 51936

**STEM BUILDING
THE BENJAMIN SCHOOL - LOWER MIDDLE SCHOOL**
11000 Ellison Wilson Road, North Palm Beach, FL 33408
CONSTRUCTION DOCUMENTS

Corr. No: 16117.00
Job No: 117030
Date: 10-23-17
Drawn: GSQ

Revisions		
No.	Date	Note

TO THE BEST OF MY KNOWLEDGE, THE PLANS AND SPECIFICATIONS COMPLY WITH THE MINIMUM BUILDING CODES.

© 2017 HARVARD JOLLY, INC.

JLRD Project #117030