


This information is intended for the professional use of the recipient only. It is not to be distributed, copied, or otherwise used in any way without the express written consent of Harvard Jolly Architecture, Inc. All rights reserved. © 2017 Harvard Jolly Architecture, Inc. All rights reserved.

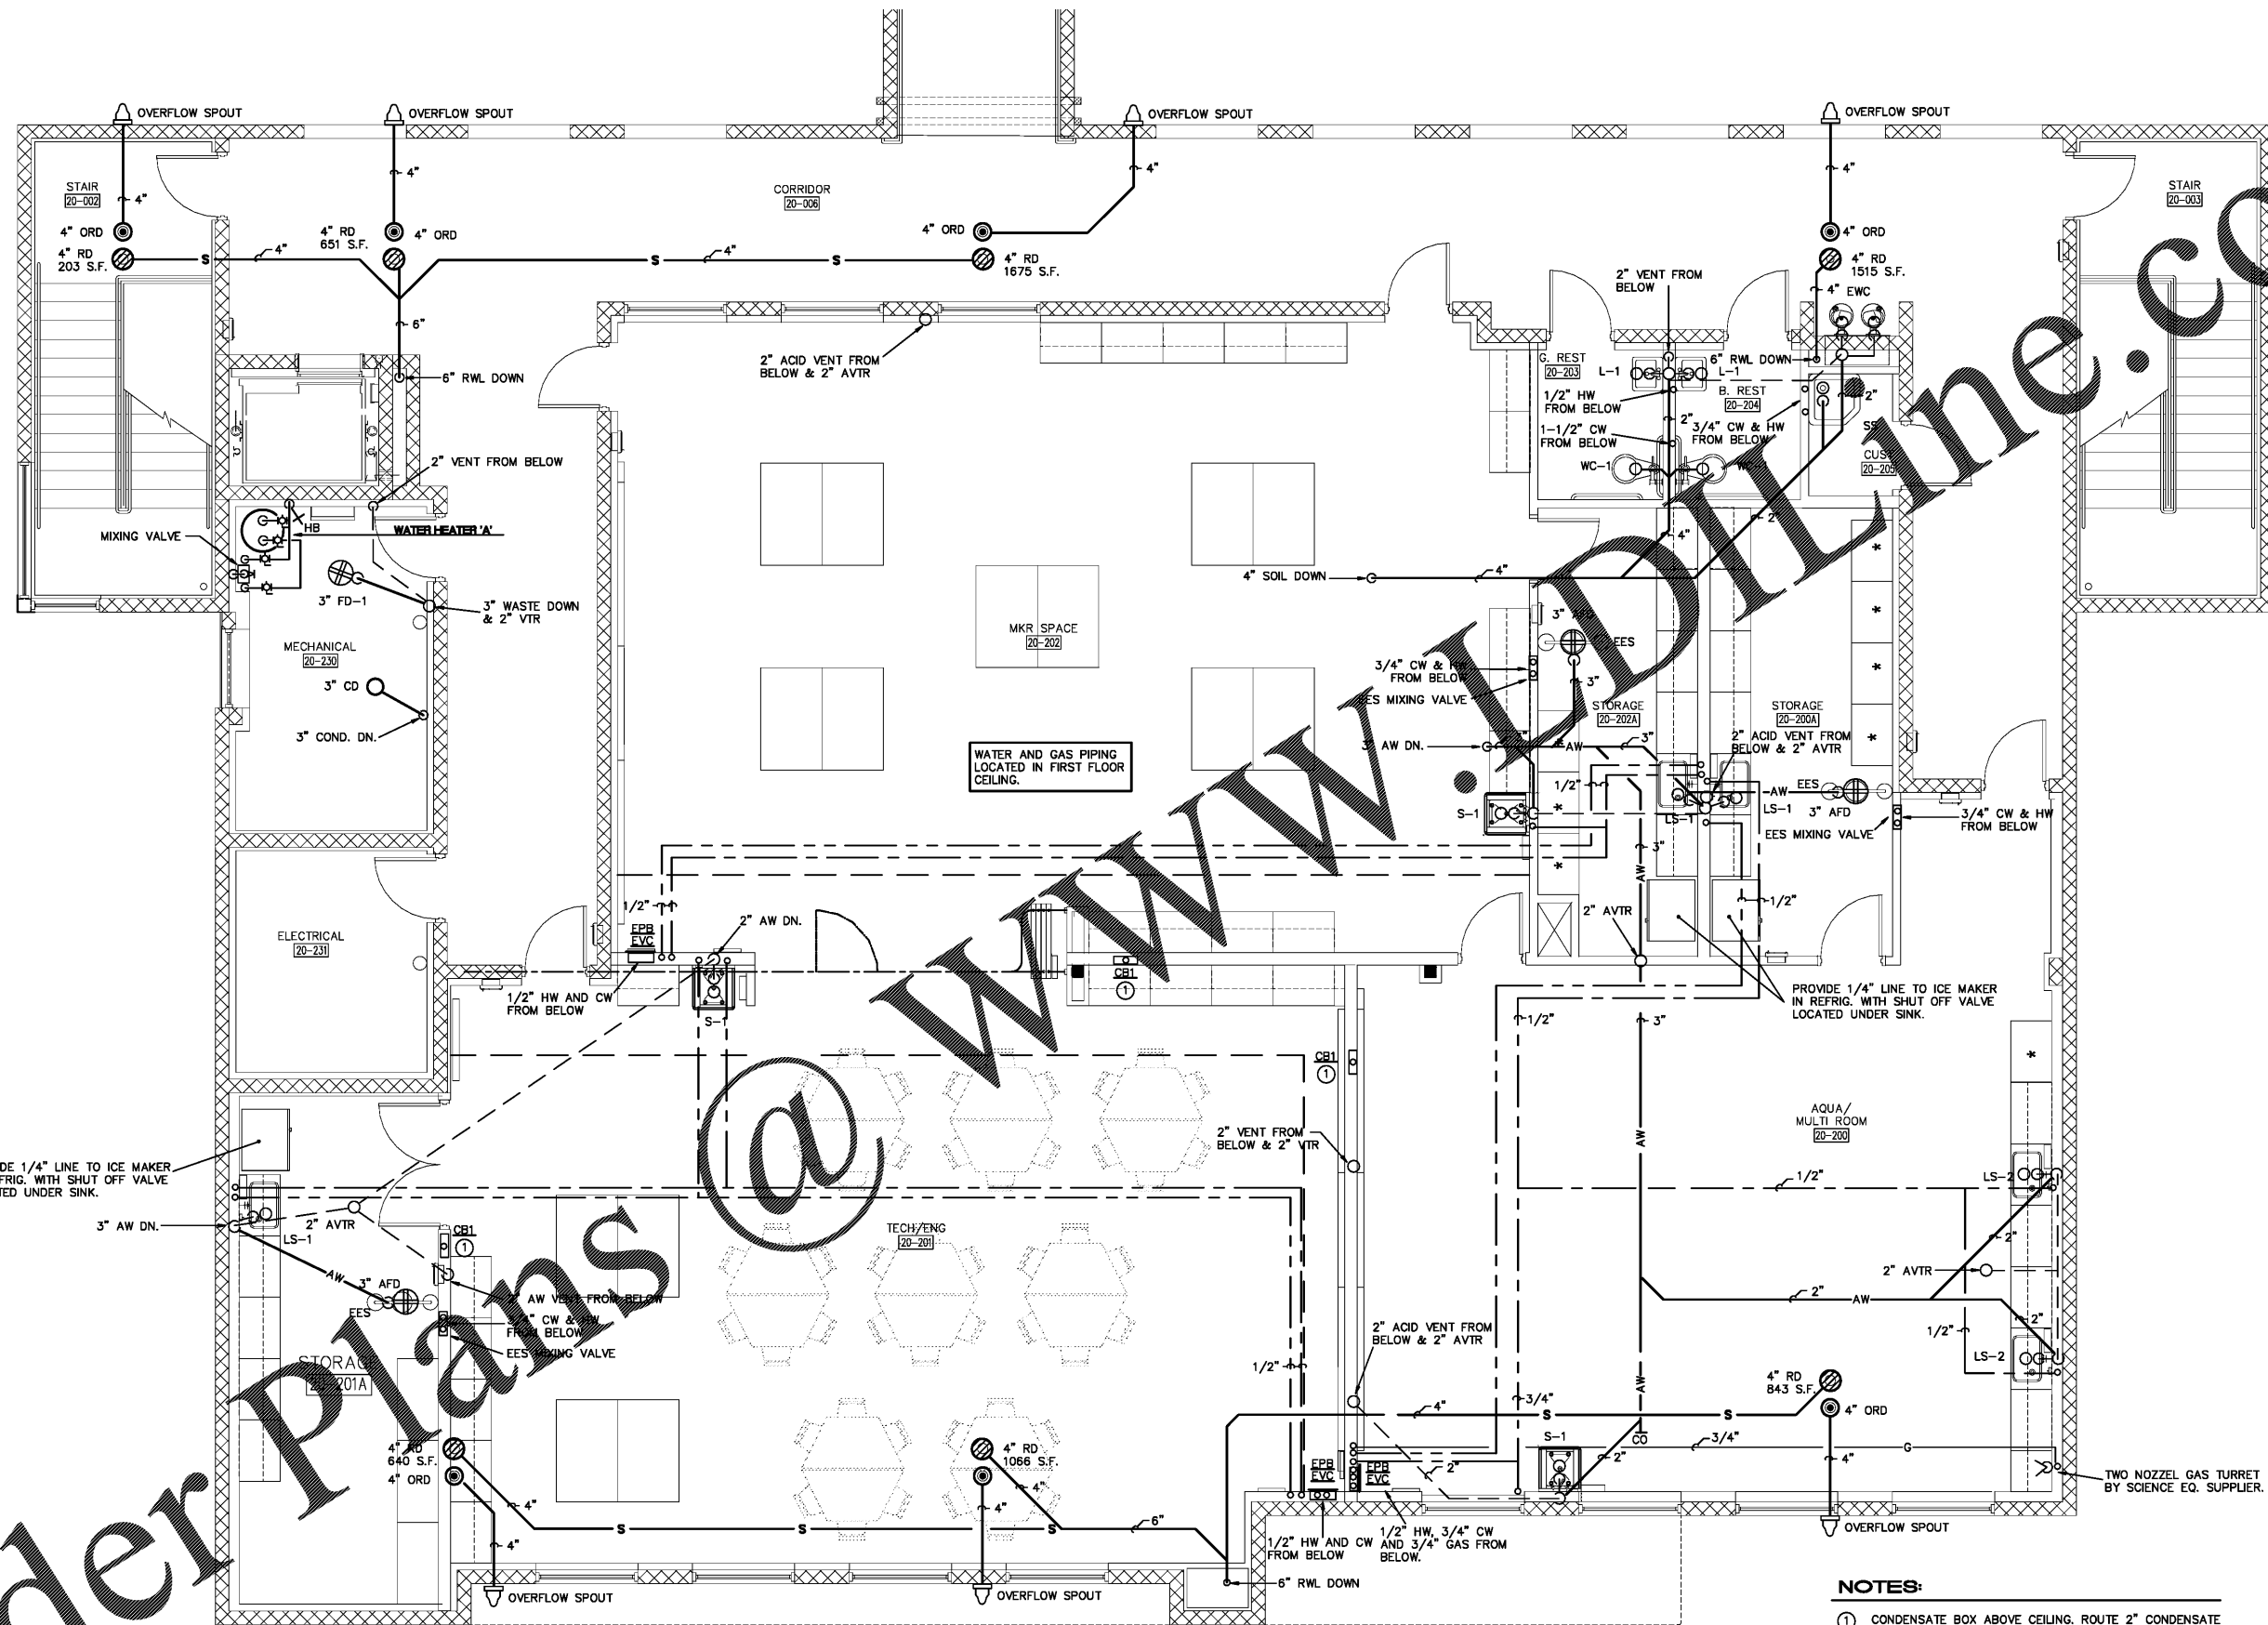

NOTES:
 ① CONDENSATE BOX ABOVE CEILING. ROUTE 2" CONDENSATE LINE DOWN TO FIRST FLOOR. COORDINATE HEIGHT OF BOX WITH HVAC CONTRACTOR.

1 SECOND FLOOR PLUMBING PLAN - SANITARY + WATER
 SCALE: 1/4"=1'-0"

Order Plans @ WWW.HARVARDJOLLY.COM

Contract No.:	16117.00	
Job No.:	117030	
Date:	10-23-17	
Drawn:	GSQ	
Revisions		
No.	Date	Note

TO THE BEST OF MY KNOWLEDGE, THE PLANS AND SPECIFICATIONS COMPLY WITH THE MINIMUM BUILDING CODES.