


FIXTURE LEGEND

- 2'x2' FLAT PANEL LED LITHONIA EPANL 24 40L 40K
- 4" RECESSED LED DOWNLIGHT WAC HR-3LED-H100-A HOUSING WAC HR3LED118F-9W-WT TRIM
- 4" TRACK LIGHT WAC J TRACK 120V BLACK FINISH W/ JTK-104LED-BK HEADS (1 PER 2 LF)
- PENDANT LIGHT QUORUM INTERNATIONAL 6822-65 SATIN NICKEL (SUPPLIED BY TENANT - INSTALLED BY GC)
- PENDANT LIGHT FRANCE AND SON HERNING PENDANT (SUPPLIED BY TENANT - INSTALLED BY GC)
- PENDANT LIGHT REJUVENATION LIGHTING ASTRON PENDANT CYAN/SIGNAL RED/MILKY WAY (SUPPLIED BY TENANT - INSTALLED BY GC)
- BATH SCONCE SEA GULL LIGHTING 44436-962 ACADEMY SILVER (SUPPLIED BY TENANT - INSTALLED BY GC)
- CHANDELIER HARKIK BEAM 20 LIGHT SPUTNIK (SUPPLIED BY TENANT - INSTALLED BY GC)
- EXTERIOR SCONCE HIP HAVEN - BOWTIE SCONCE - SILVER W/ PINHOLES (SUPPLIED BY TENANT - INSTALLED BY GC)
- EXTERIOR SCONCE TRENT AUSTIN DESIGN BRUGES BARN LIGHT - SATIN NICKEL (SUPPLIED BY TENANT - INSTALLED BY GC)
- EXTERIOR SCONCE/SIGN LIGHT HI-LITE MFG CO H-PAR20-96/18-1-96/60W/INC-1
- EXTERIOR SIGN LIGHT WAC WP-LED415-30-GGH
- STRING LIGHTS BLACK C9 LED STRING LIGHTS (GC TO PROVIDE OUTLET ONLY)
- 4" LED SHOP LIGHT LITHONIA SHLP LINEAR
- EXIT SIGN W/ LED EMERGENCY LIGHTS


REFLECTED CEILING PLAN NOTES

1. ELECTRICAL CONTRACTOR IS RESPONSIBLE FOR COORDINATING THE REQUIREMENTS IN CONJUNCTION WITH ANY DRAWINGS.
2. GENERAL CONTRACTOR SHALL FIELD VERIFY ALL FIXTURE LOCATIONS. ANY CONFLICT WITH FIELD CONDITIONS, DRAWINGS AND/OR TRADES SHALL BE REPORTED TO THE DESIGNER IMMEDIATELY UPON DISCOVERY FOR CLARIFICATION PRIOR TO PROCEEDING WITH ASSOCIATED WORK.
3. ANY EXPOSED ITEMS MOUNTED TO STRUCTURE SHALL BE PAINTED TO MATCH STRUCTURE PAINT. ITEMS INCLUDE, BUT ARE NOT LIMITED TO, STRUCTURAL SUPPORT FOR SOFFITS AND ELECTRICAL CONDUIT, BOXES, DEVICES, & COVERPLATES.
4. PROVIDE AND INSTALL CEILING TILE, MAIN TEES, CROSS TEES, WALL MOLDINGS AND ALL OTHER ACCESSORIES NECESSARY TO COMPLETE THE SCOPE OF WORK.
5. PROVIDE AND INSTALL ILLUMINATED EXIT LIGHTING PER CODE.
6. PROVIDE AND INSTALL EMERGENCY LIGHTING PER CODE TO MAINTAIN ILLUMINATION OF THE MEANS OF EGRESS (NOT LESS THAN ONE (1) FOOT CANDLE FOR A PERIOD OF 1 1/2 HOURS) IN THE EVENT OF POWER FAILURE OF NORMAL LIGHTING. EMERGENCY LIGHTING SHALL BE INCORPORATED INTO THE LIGHTING PLAN AND LOCATED ABOVE THE CEILING.
7. ALL ADJACENT LIGHT SWITCHES SHALL BE GANGED WITH A SINGLE FACEPLATE.
8. ALL NEW SPRINKLER HEADS IN GYPSUM BOARD TO BE RECESSED.
9. ALL RECESSED LIGHT FIXTURES SHALL BE CENTERED IN CEILING TILES WHERE POSSIBLE. U.N.O.
10. COORDINATE ALL DIRECTIONAL FIXTURE AIMING IN FIELD WITH TENANT REPRESENTATIVE.
11. ALL FIXTURES MARKED PROVIDED BY TENANT SHALL BE INSTALLED BY GC.
12. GENERAL CONTRACTOR WILL ENSURE THAT SHADES AND LENSES IN LIGHTING FIXTURES ARE CLEAN AND FREE OF DUST, DIRT, AND SMUDGES. PLASTIC AND LABELS SHALL BE REMOVED FROM ALL LIGHT FIXTURES AT PROJECT COMPLETION.
13. CEILING IN KITCHEN AND PREPARATION AREAS TO BE NON-POUS, NON-ABSORBENT, & CLEANABLE & LIGHT COLORED. WHERE GYP TILE IS SHOWN PROVIDE GYP CEILING #327 2'x4' GYPSUM LAY-IN CEILING PANELS INSTALLED IN USG DONN DX 15' GRID (WHEN APPLICABLE).

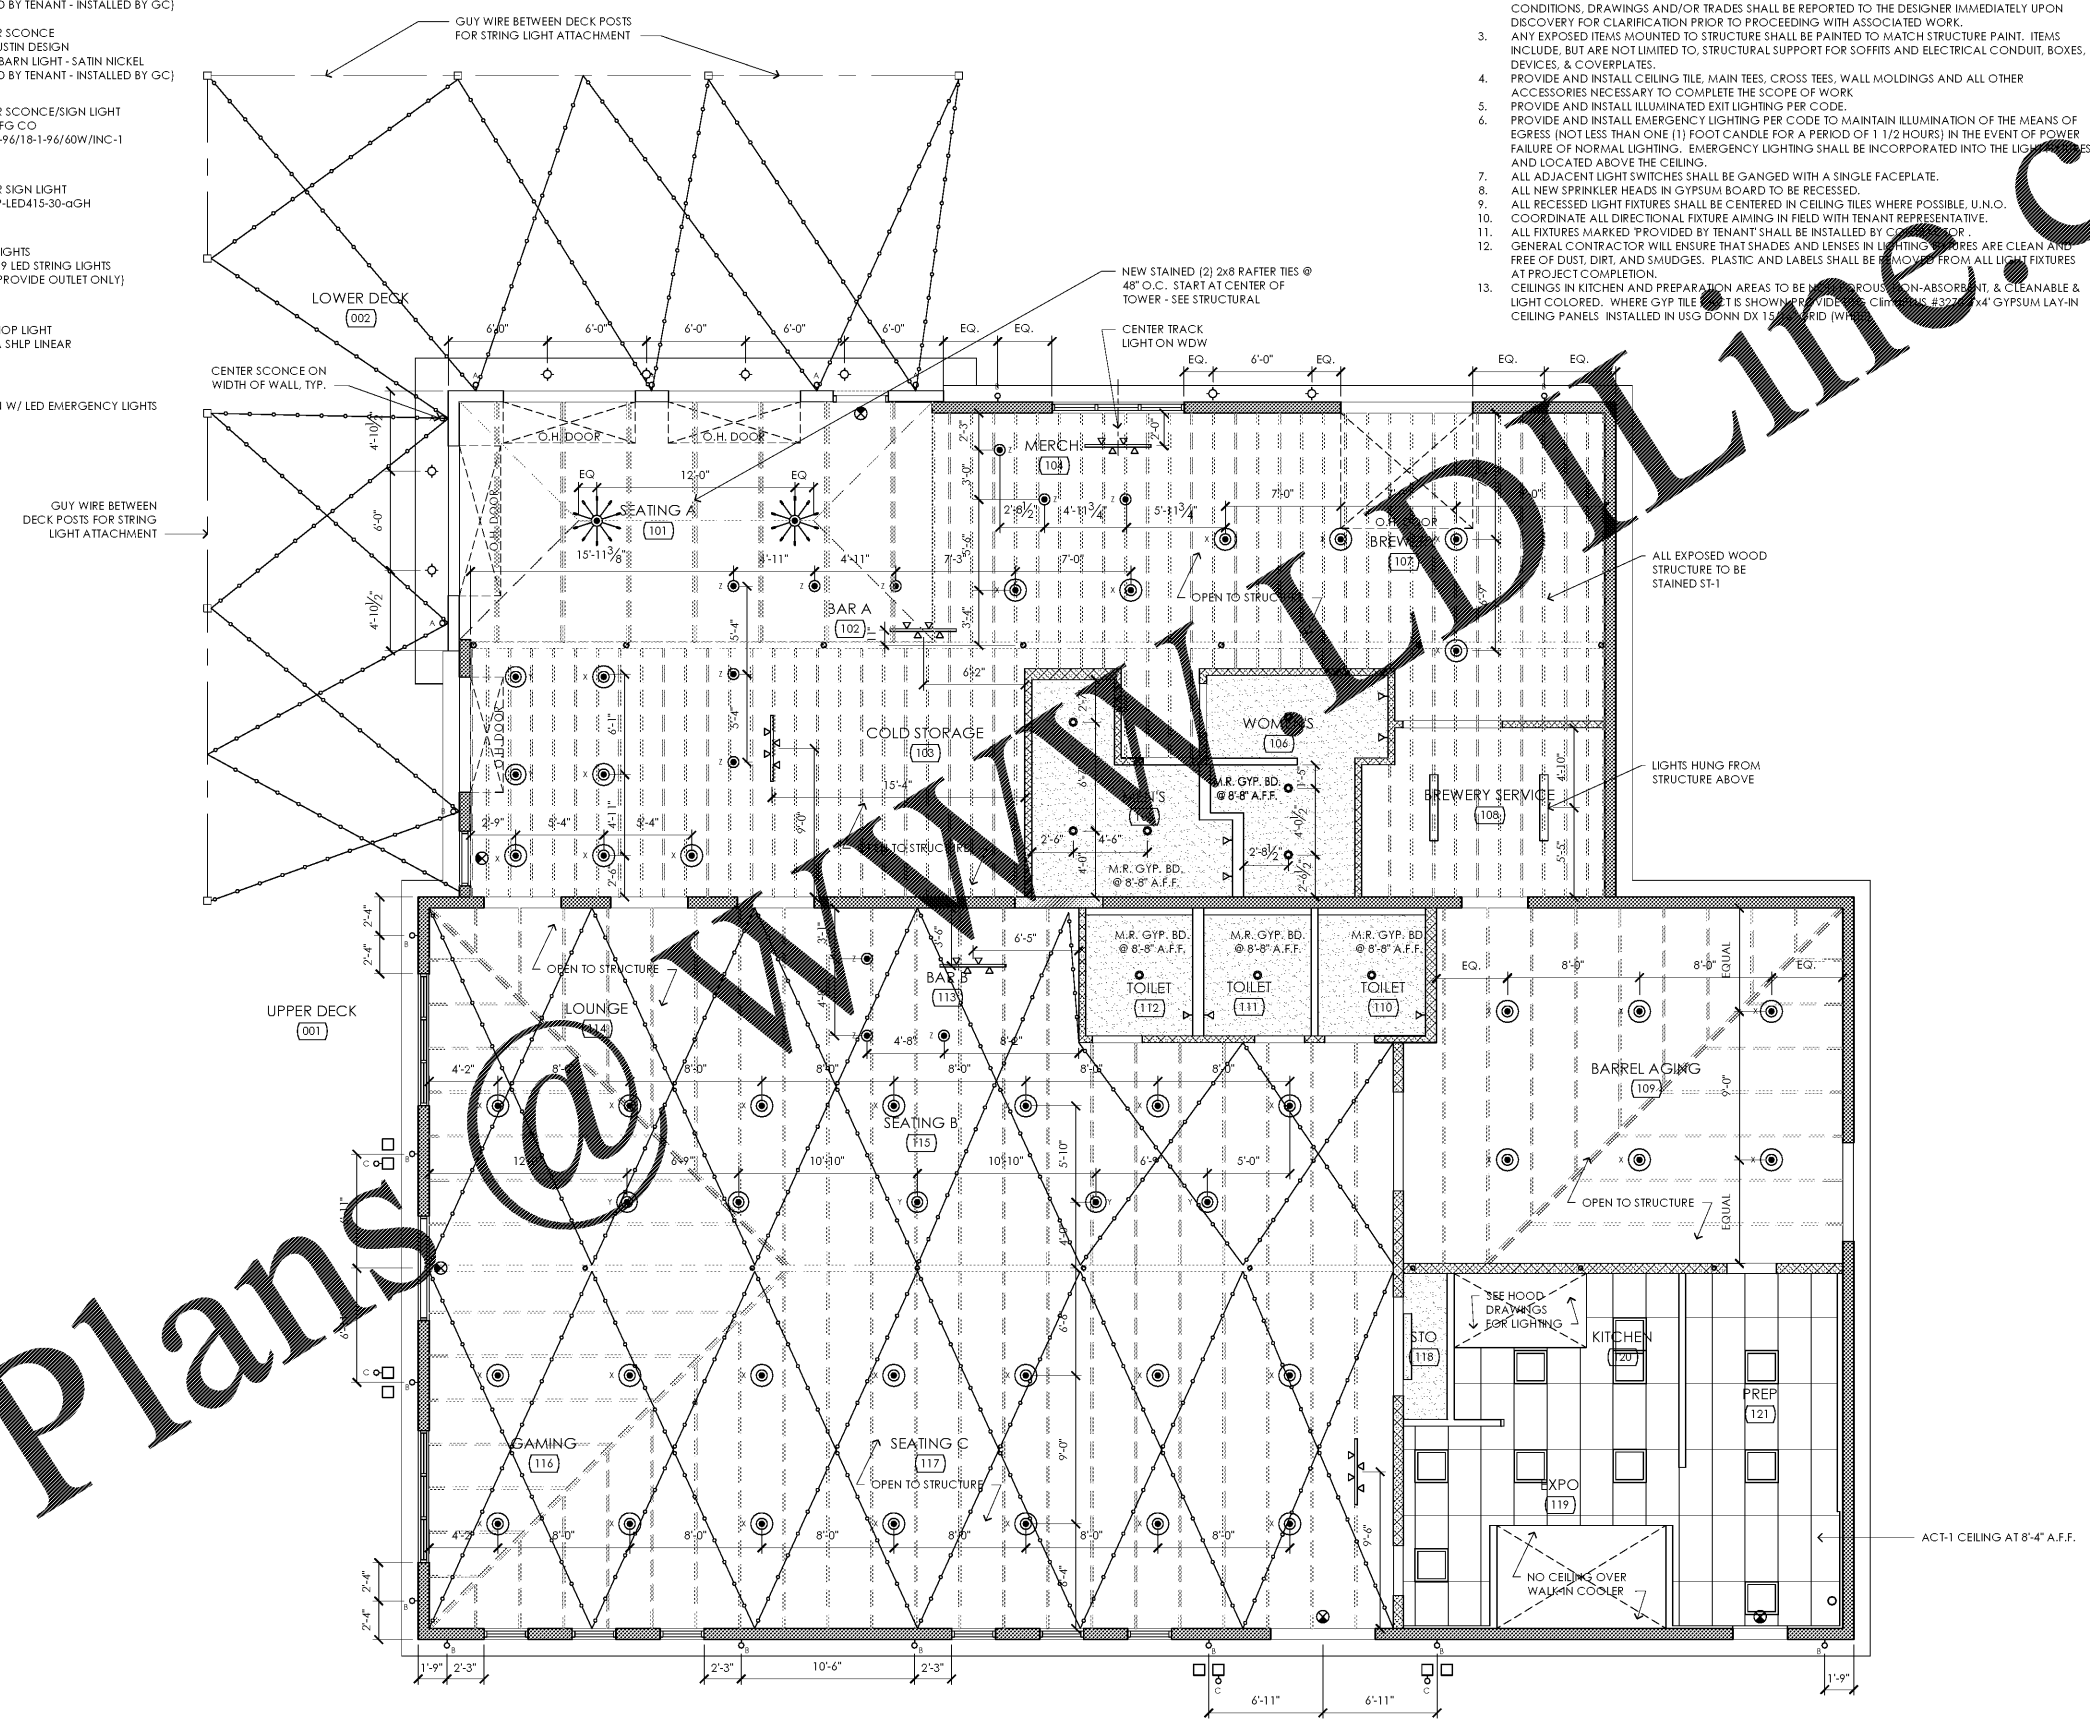

REV #	DATE	DESCRIPTION

REFORMATION BREWERY
 105 ELM STREET
 WOODSTOCK, GEORGIA 30188
REFORMATION BREWERY

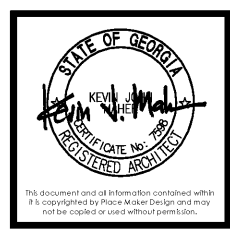

PLACE MAKER DESIGN
 1000 CIRCLE 75 PARKWAY
 SUITE 400
 ATLANTA, GEORGIA 30339
 404.549.4499

ISSUE DATE: 01/05/2018
 DRAWN BY: BJK / TJH
 CHECKED BY: TMV
 PWD PROJ # : 17072

REFLECTED CEILING PLAN

A1.2

Order Plans

01 REFLECTED CEILING PLAN
 A1.2 3/16" = 1'-0"