


Order Plans @

KEYNOTES	
1	2" V DN
2	3" V DN
3	TRAP PRIMER TP-1 WITH 1/2" TP LINE B/F TO FD
4	3" V UP TO 3" VTR
5	3" P-TRAP AT BASE OF TRENCH DRAIN
6	3" FLOOR SINK FS-1. DISCHARGE ALL NEARBY INDIRECT WASTE CONNECTIONS FULL SIZE W/AIR GAP AT LEAST TWICE THE DIAMETER OF INDIRECT WASTE PIPE (SEE DETAIL). FIELD COORDINATE WITH INSTALLED EQUIPMENT.
7	3" HUB DRAIN. DISCHARGE ALL NEARBY INDIRECT WASTE CONNECTIONS FULL SIZE W/AIR GAP AT LEAST TWICE THE DIAMETER OF INDIRECT WASTE PIPE (SEE DETAIL). FIELD COORDINATE WITH INSTALLED EQUIPMENT.
8	3" HUB DRAIN. DISCHARGE FULL SIZE CONDENSATE LINE FROM FREEZER/COOLER EVAPORATOR(S) TO THIS LOCATION WITH AIR GAP. FIELD COORDINATE EXACT PATH.
9	3" V UP TO AIR ADMITTANCE VALVE AAV-1. FIELD COORDINATE EXACT LOCATION WITH EQUIPMENT TO BE INSTALLED.
10	4" GW B/G TO 1500 GALLON PRECAST CONCRETE GREASE INTERCEPTOR. FIELD COORDINATE EXACT LOCATION.
11	4" S B/G & CONNECT TO SITE SANITARY SEWER UTILITY. FIELD VERIFY EXACT LOCATION, DEPTH, AND DIRECTION OF FLOW PRIOR TO COMMENCING WORK.
12	ROUTE PVC COMBUSTION AIR INTAKE & PVC EXHAUST VENTS UP TO WATER HEATER MANUFACTURER'S ROOF CONCENTRIC VENT KIT (SEE DETAIL). SIZE & INSTALL VENT PIPING IN STRICT ACCORDANCE WITH MANUFACTURER'S REQUIREMENTS.
13	DISCHARGE WATER HEATER CONDENSATE LINE TO HUB DRAIN WITH AIR GAP.

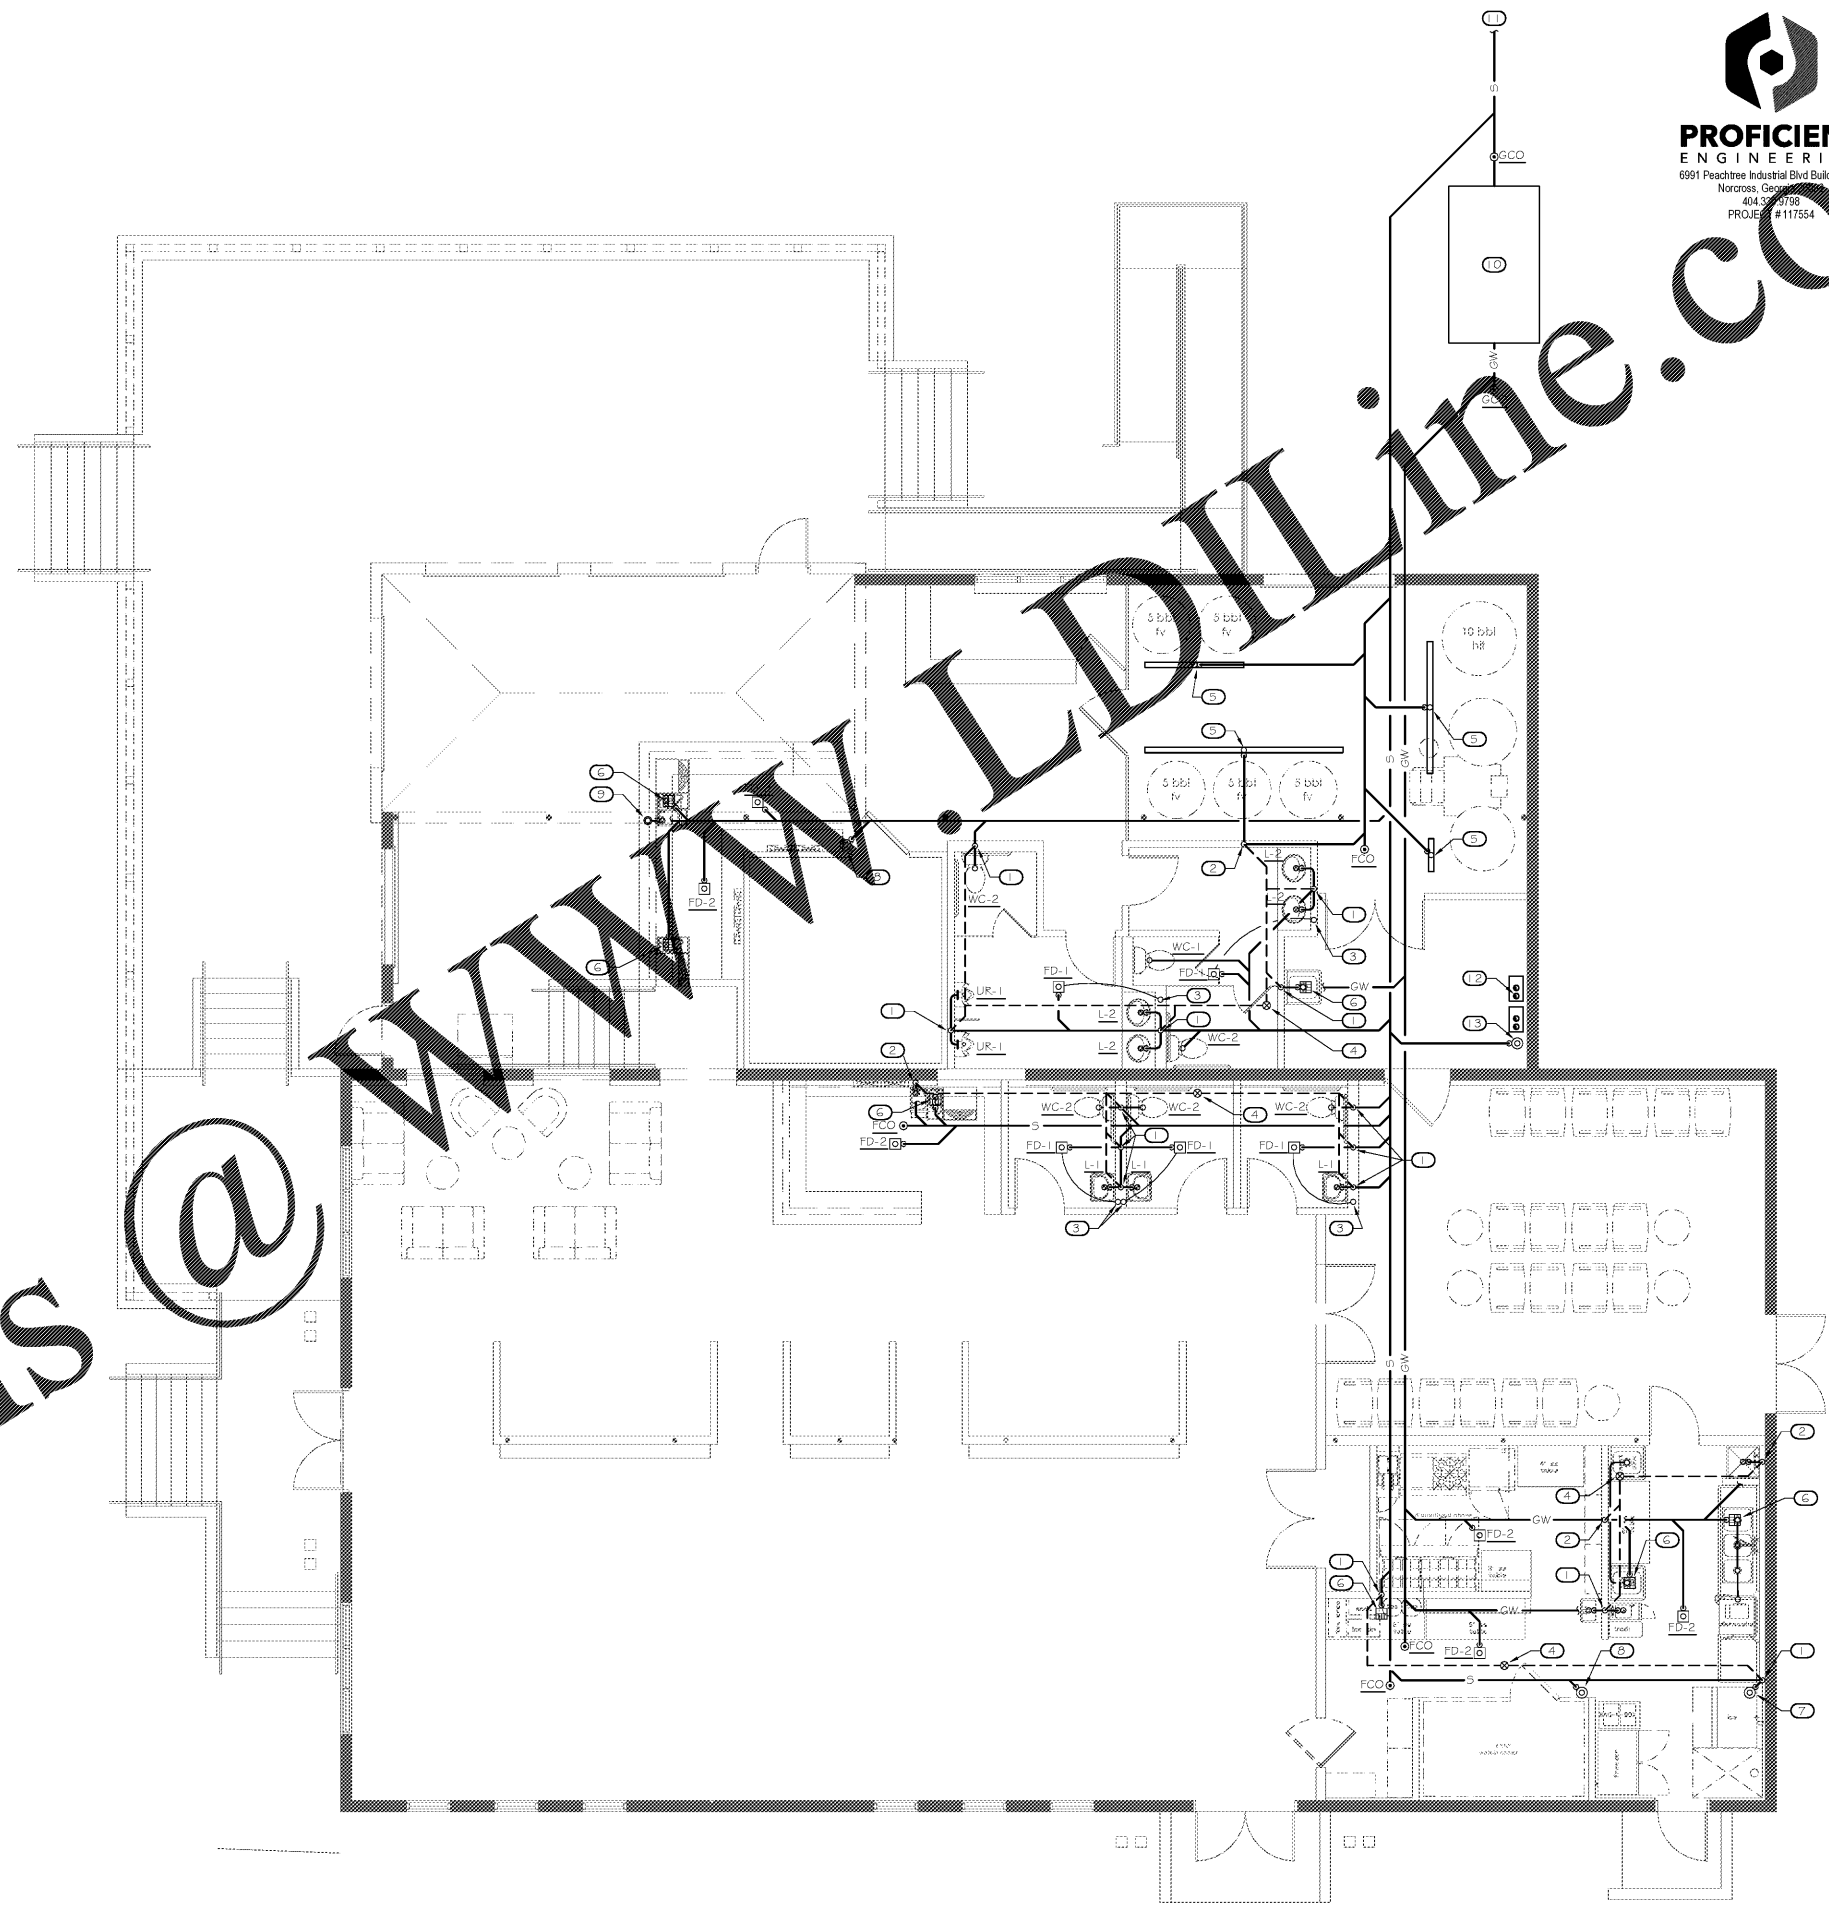


PROFICIENT ENGINEERING
 6991 Peachtree Industrial Blvd Building 700
 Norcross, Georgia 30071
 404.549.4499
 PROJECT # 117554



REV #	DATE	DESCRIPTION

REFORMATION BREWERY
 105 LEMASTREET
 WOODSTOCK, GEORGIA 30188
 REFORMATION BREWERY

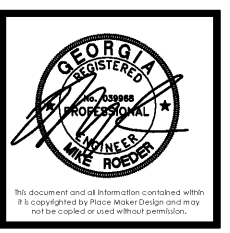

PLACE MAKER DESIGN
 1000 CIRCLE 75 PARKWAY
 SUITE 400
 ATLANTA, GEORGIA 30339
 404.549.4499

ISSUE DATE: 10/29/17
 DRAWN BY: CAJDL
 CHECKED BY: MK
 PWD PROJ # 17072

FLOOR PLAN - WASTE & VENT

SHEET # **P1.1**

01 FLOOR PLAN - WASTE & VENT
 P1.1 3/16" = 1'-0"