


| REV # | DATE | DESCRIPTION |
|-------|------|-------------|
| | | |
| | | |
| | | |
| | | |
| | | |

REFORMATION BREWERY
 105 ELM STREET
 WOODSTOCK, GEORGIA 30188
 REFORMATION BREWERY

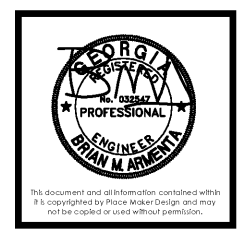

PLACE MAKER DESIGN
 1000 CIRCLE 75 PARKWAY
 SUITE 400
 ATLANTA, GEORGIA 30339
 404.549.4499

| | |
|------------|----------|
| ISSUE DATE | 12/29/17 |
| DRAWN BY | AT |
| CHECKED BY | BA |
| PWD PROJ # | 17072 |

FLOOR PLAN - POWER


SHEET # **E1.1**

GENERAL NOTES

- REFER TO ARCHITECTURAL REFLECTED CEILING PLAN FOR EXACT LOCATIONS OF ALL CEILING MOUNTED DEVICES.
- ALL RECEPTACLES SHALL BE GROUNDED AS REQUIRED BY ARTICLE 250-146.
- ALL 120V, SINGLE PHASE RECEPTACLES LOCATED IN KITCHEN AND BAR AREAS SHALL BE GFCI RATED PER NEC 210.8(B).
- SEE EQUIPMENT SCHEDULE ON SHEET EQ.2 FOR ELECTRICAL REQUIREMENTS AND CIRCUITING.
- COORDINATE EXACT EQUIPMENT REQUIREMENTS AND LOCATION WITH MANUFACTURER AND OWNER.

KEYNOTES

- PROVIDE RECEPTACLE FOR IGNITION OF GAS POWERED WATER HEATERS. SEE PLUMBING DRAWINGS FOR ADDITIONAL REQUIREMENTS.
- HVAC EQUIPMENT LOCATED ABOVE CEILING.
- FACTORY INSTALLED WP/GFCI DUPLEX RECEPTACLE FOR MAINTENANCE.
- COORDINATE EXACT LOCATION OF BREWHOUSE CONTROL PANEL WITH BREWMASTER AND OWNER.
- CONDENSING UNIT LOCATED ON ROOF. COORDINATE EXACT SPECIFICATIONS WITH ARCHITECT AND MANUFACTURER.
- SWITCH TO CONTROL KITCHEN EXHAUST HOOD. COORDINATE EXACT LOCATION OF SWITCH WITH ARCHITECT AND OWNER.
- HVAC EQUIPMENT LOCATED ON ROOF.

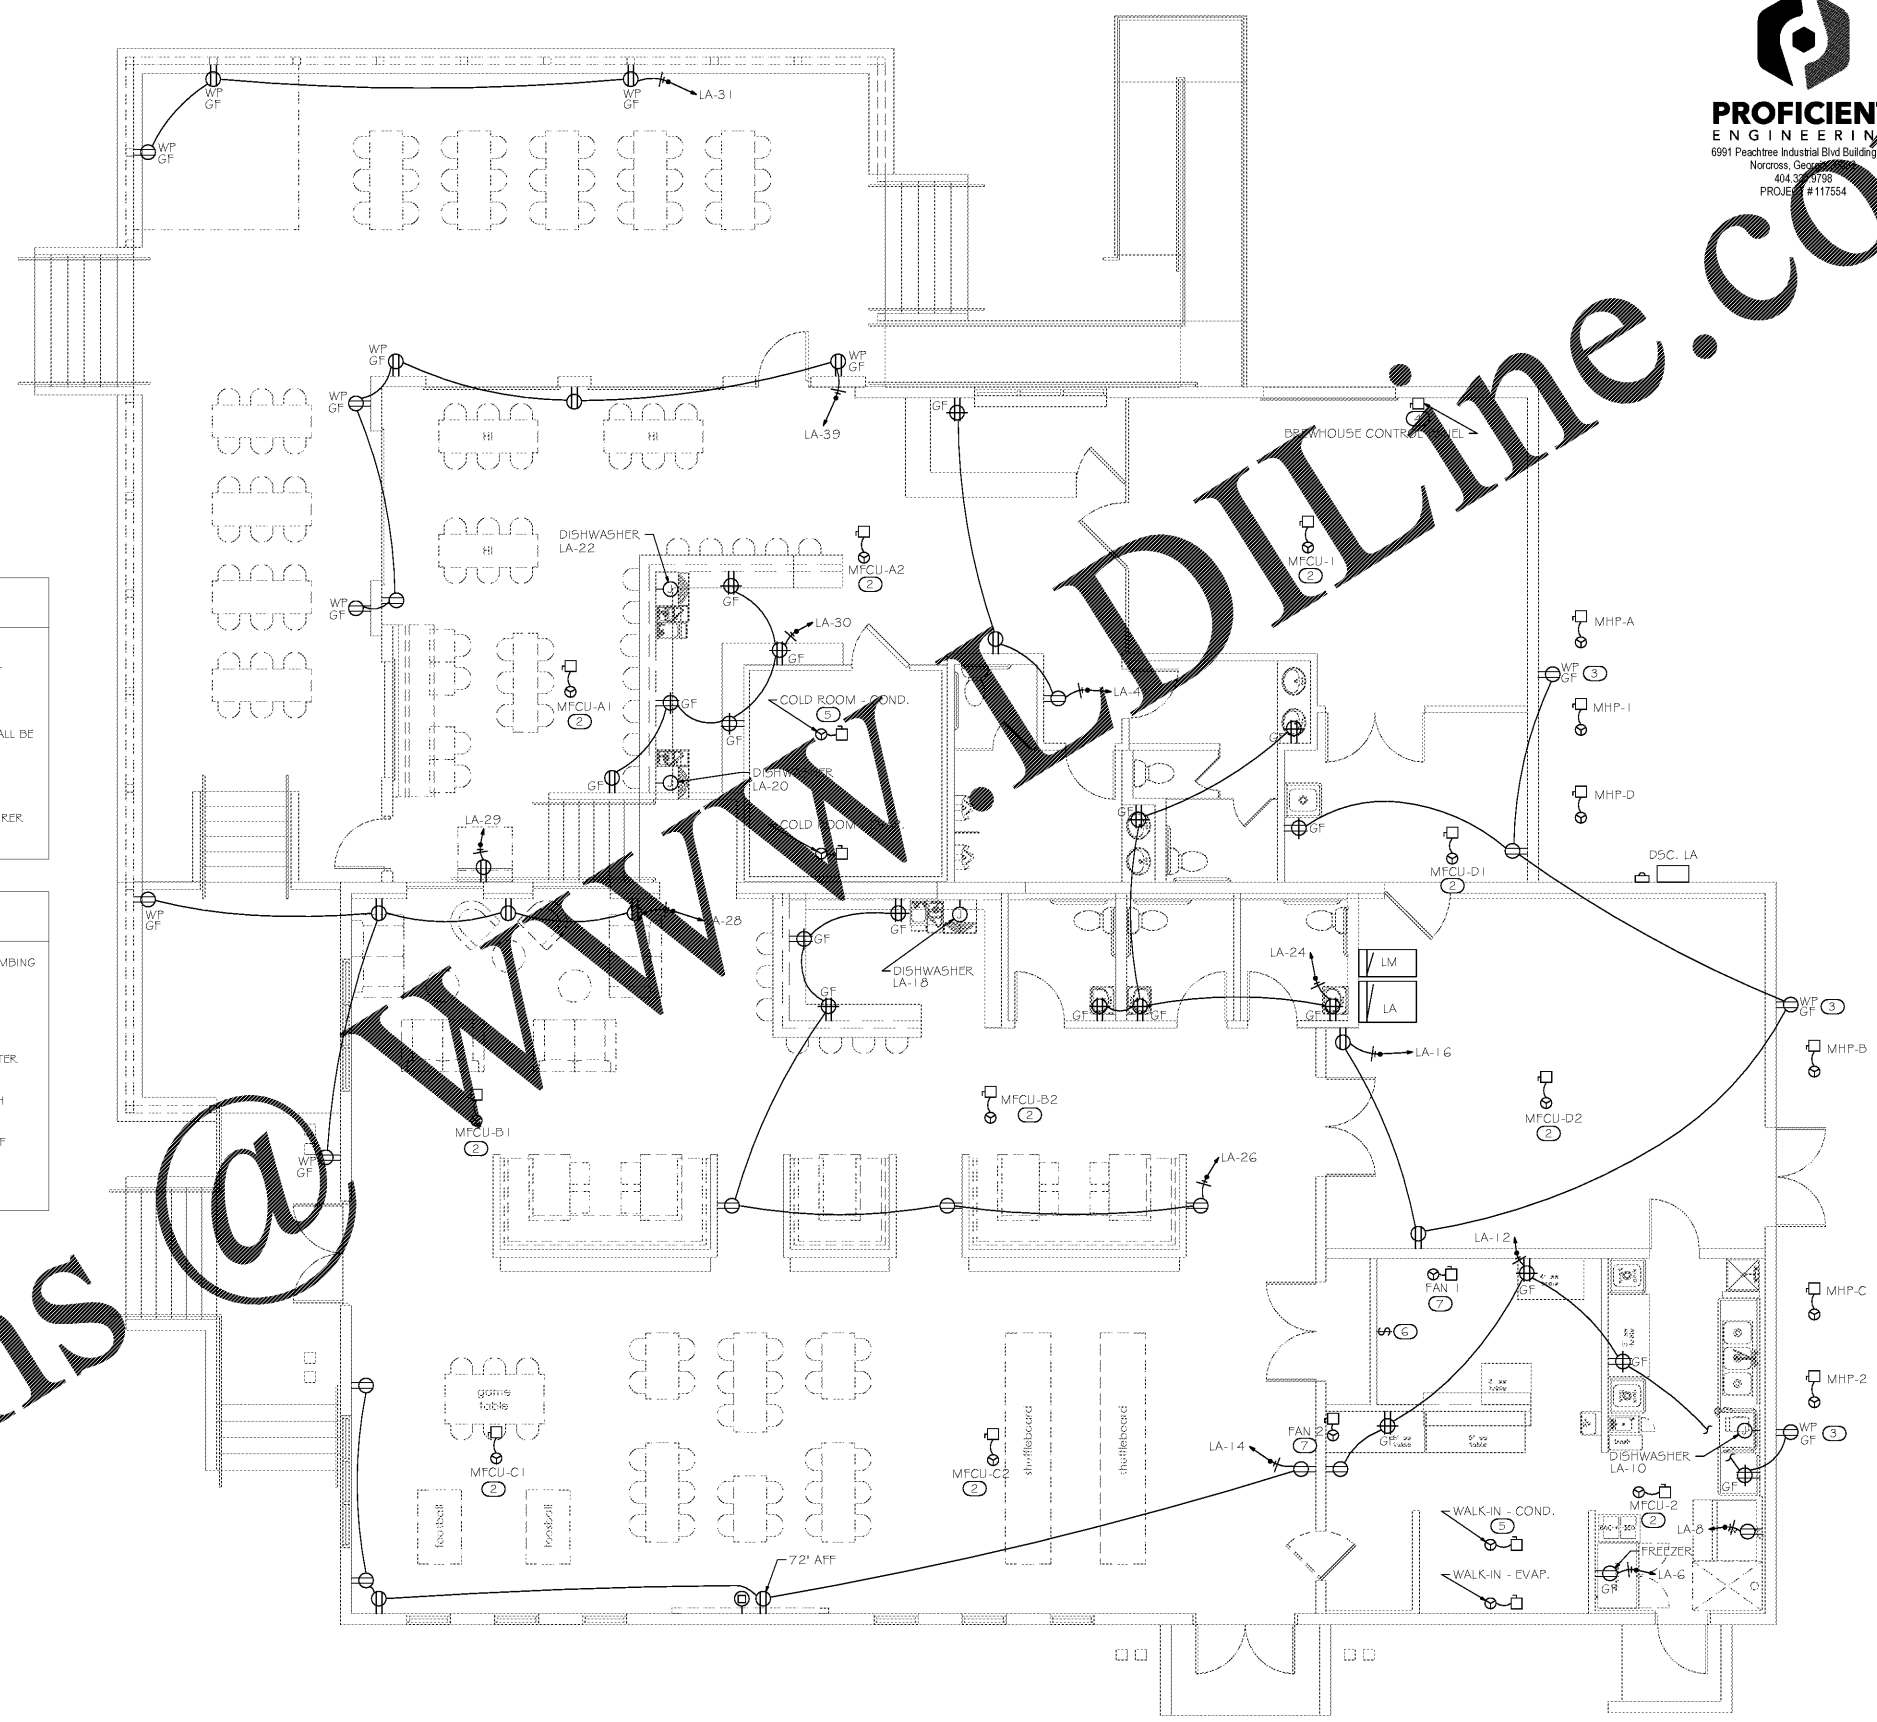

Order Plans @ www.dline.com

01 FLOOR PLAN - POWER
 E1.1 3/16" = 1'-0"