

REV #	DATE	DESCRIPTION

REFORMATION BREWERY
 105 ELM STREET
 WOODSTOCK, GEORGIA 30188
 REFORMATION BREWERY



PLACE MAKER DESIGN
 1000 CIRCLE 75 PARKWAY
 SUITE 400
 ATLANTA, GEORGIA 30339
 404.549.4499

ISSUE DATE	12/29/17
DRAWN BY	AT
CHECKED BY	BA
PWD PROJ #	17072

FLOOR PLAN - LIGHTING

SHEET # **E1.2**


GENERAL NOTES

- REFER TO ARCHITECTURAL REFLECTED CEILING PLAN FOR EXACT LOCATIONS OF ALL CEILING MOUNTED DEVICES.
- PROVIDE UNSWITCHED HOT LEG OF CIRCUIT TO EMERGENCY LIGHTING AND EXIT SIGNS.

KEYNOTES

- EXTERIOR LUMINAIRE FIXTURE TO BE CONTROLLED BY LIGHTING CONTACTOR WITH PHOTOCELL AND TIMER.
- PROVIDE JUNCTION BOX FOR FUTURE RECEPTACLE TO POWER STRING LIGHTS COORDINATE WITH OWNER AND ARCHITECT FOR EXACT LOCATION OF JUNCTION BOX.
- EXHAUST FAN TO BE CONTROLLED WITH LIGHT SWITCH.

CALLOUT	SYMBOL	LAMP	DESCRIPTION	MODEL	VOLTS
A	⊙	(1) 60W A19	EXTERIOR SCONCE	HIP HAVEN - BOWTIE SCONCE - SILVER W/ PINHOLES	120V 1P 2W
B	⊙	(1) 60W A19	EXTERIOR SCONCE	TRENT AUSTIN DESIGN BRUGES BARN LIGHT - SATIN NICKEL	120V 1P 2W
C	⊙	(1) 60W PAR20	EXTERIOR SCONCE	HI-LITE MFG CO H-PAR20 - 96/1.8-1-96/60W/INC-1	120V 1P 2W
D	⊠	(1) 35W LED	2x2 LED RECESSED TROFFER	LITHONIA EPANL24-40L-40K	120V 1P 2W
F	⊕	(1) 15W LED	EXTERIOR SIGN LIGHT	WAC WP-LED415-30-AGH	120V 1P 2W
G	○	(1) 18W LED	4" LED RECESSED DOWNLIGHT	WAC HR-3LED-H18D-A	120V 1P 2W
H	⊙	(1) 30W A19	BATH SCONCE	SEA GULL LIGHTING 44436-962 ACADEMY SILVER	120V 1P 2W
J	△	(1) 10W LED	4" TRACK LIGHT	WAC JTK-104LED-10DS	120V 1P 2W
K	⊥	(1) 30W LED	4" LED SHOP LIGHT	LITHONIA SHL-30W-40K	120V 1P 2W
L	⊕	(20) 25W E26	CHANDELIER	ARKIN M 20W E26 SPINNIK	120V 1P 2W
M	○	(1) 0.4W C9 LED	STRING LIGHTS	BLU LED STRING LIGHT	120V 1P 2W
T	⊥	(2) 1.5W LED	EMERGENCY LIGHTING UNIT	LITHONIA ELM2-LED	120V 1P 2W
X	⊕	(1) 25W LED	18" LED RECESSED DOWNLIGHT	TO BE SELECTED	120V 1P 2W
XC	⊕	(1) 1.5W LED	REFORMATION EXIT/EMERGENCY LIGHTING UNIT	LITHONIA LHQM-LED-R-HO	120V 1P 2W
XR	⊕	(1) INCLUDE	REMOTE LIGHT HEAD	LITHONIA ELA-QWP-L0309-5D	120V 1P 2W
Y	⊕	(1) 60W A19	PENDANT LIGHT	FRANCE AND SON HERNING PENDANT	120V 1P 2W
Z	⊕	(1) 60W A19	PENDANT LIGHT	REJUVENATION LIGHTING ASTRON PENDANT CYAN/SIGNAL RED/MILKY WAY	120V 1P 2W

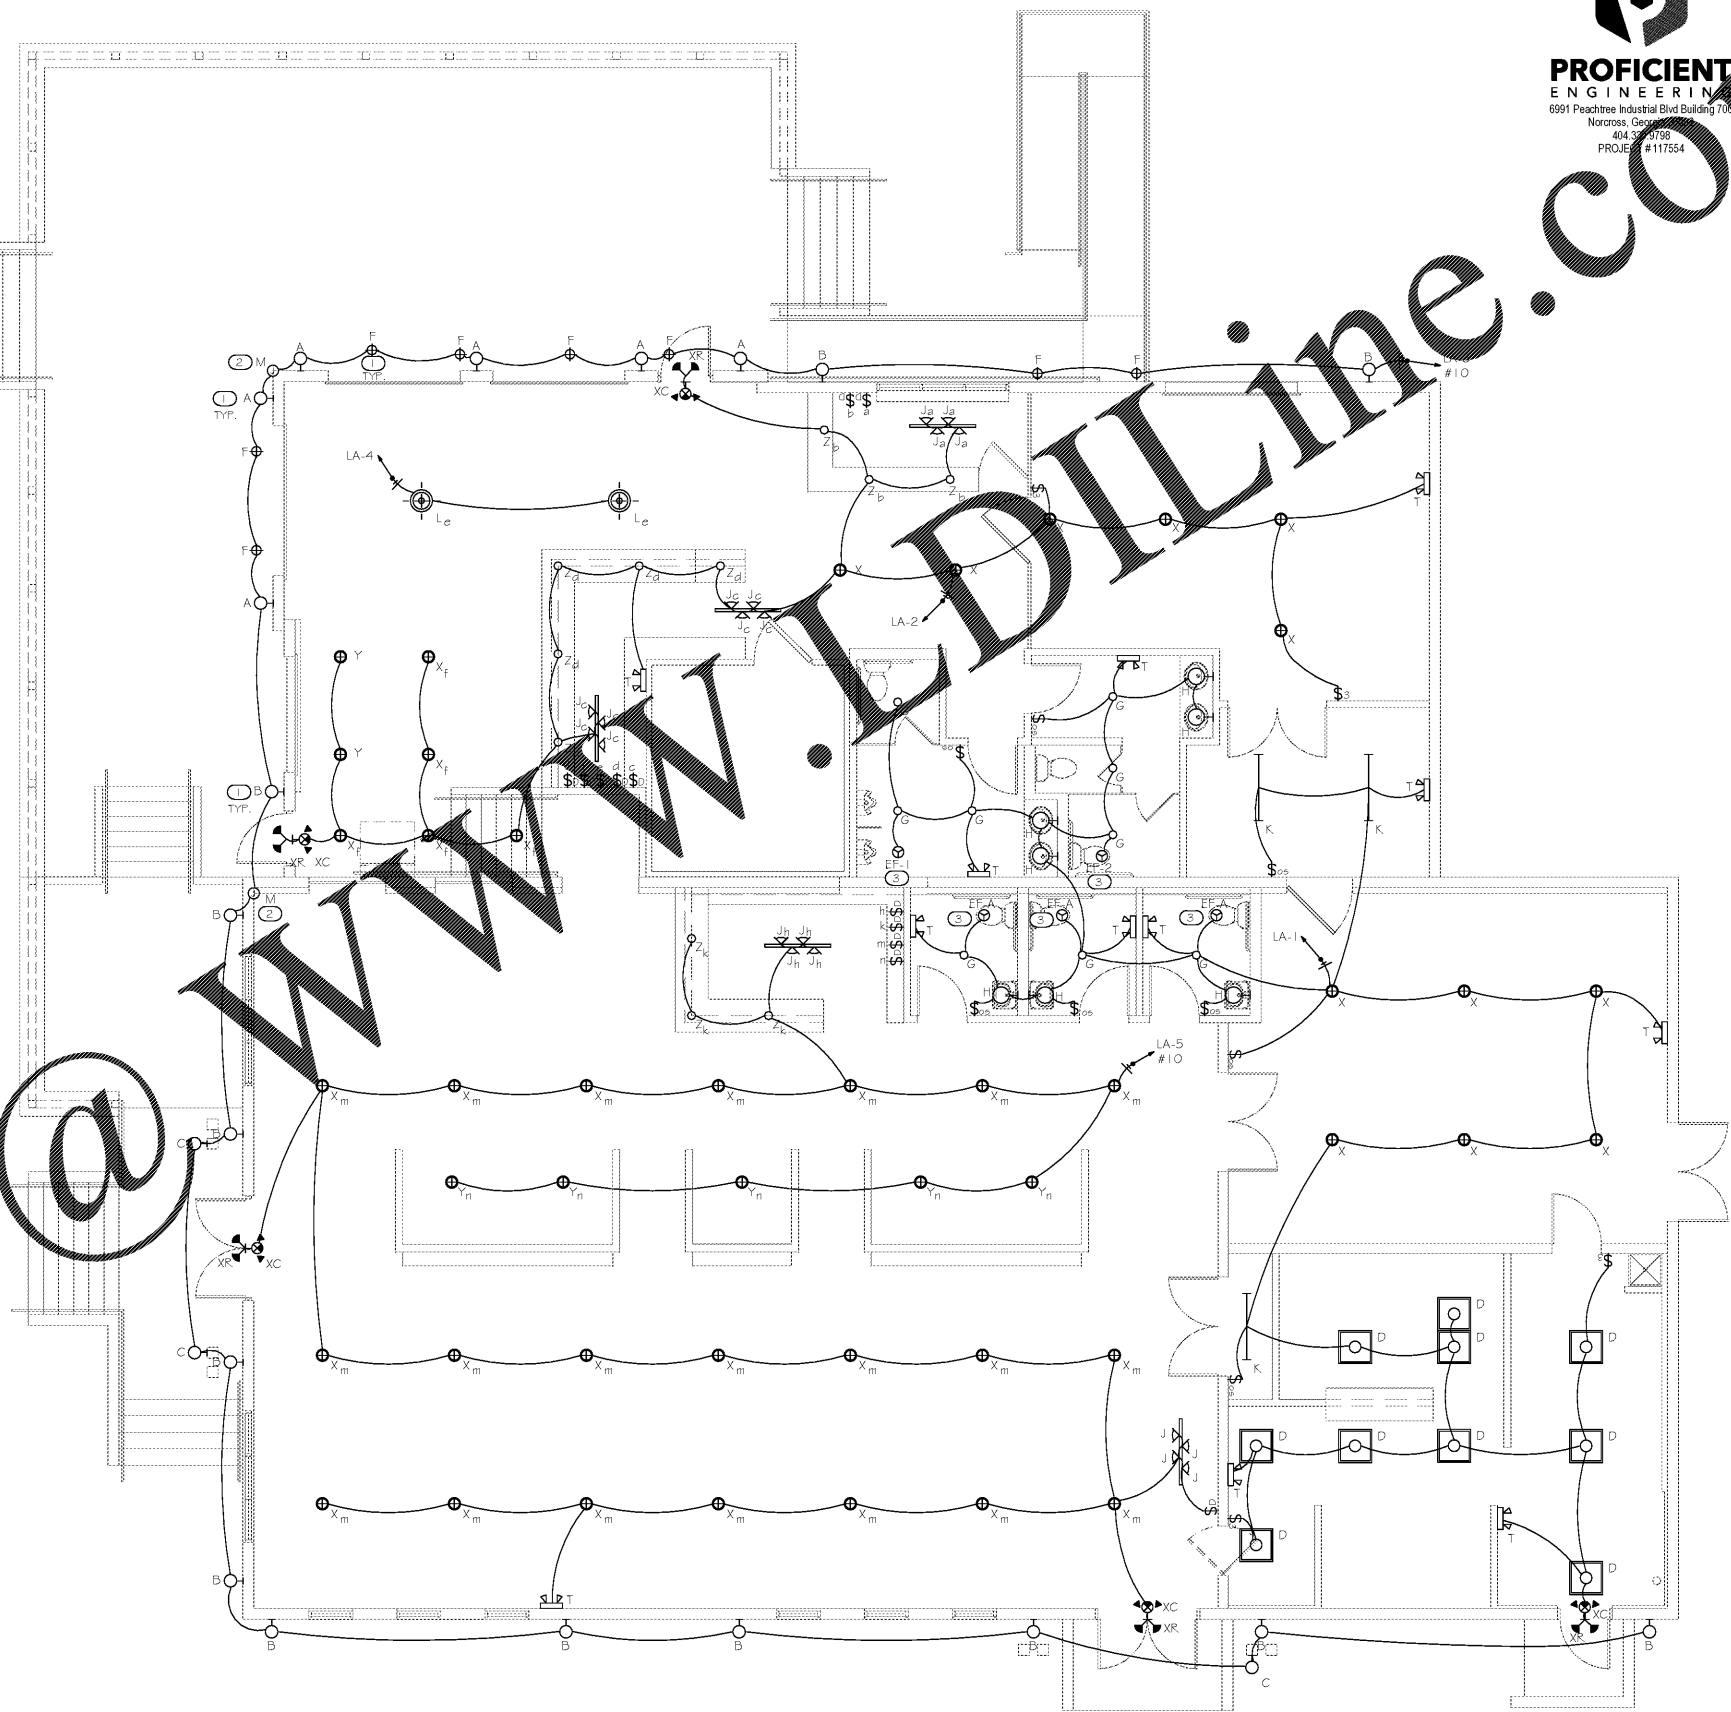

01 FLOOR PLAN - LIGHTING
 E1.2 3/16" = 1'-0"

Order Plans @ www.placedesign.com