



Order Plans @

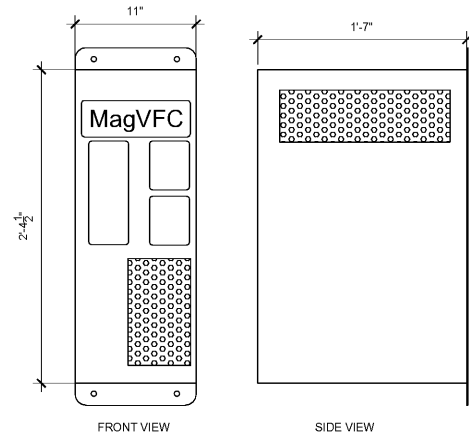


4 MAG VFC DETAIL
NTS

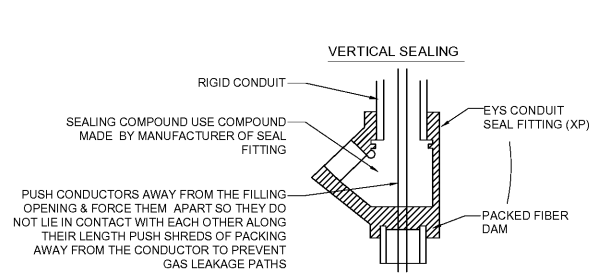


NOTE:
PROVIDE EXPLOSION PROOF SEALS, IN ACCORDANCE WITH ARTICLE 501, CLASS 1, DIVISION 2 OF THE LATEST NATIONAL ELECTRICAL CODE TYPICAL FOR ALL UNDERGROUND CONDUIT STUB-UPS INTO EQUIPMENT
SEAL OFF ALL CONDUIT ENTERING OR LEAVING CAVITIES OR ENCLOSURES OF DISPENSERS AND ASSOCIATED EQUIPMENT. IN ADDITION, ALL CONDUITS COMING FROM THE BUILDING THROUGH A HAZARDOUS LOCATION ALSO REQUIRE SEAL-OFFS AT BOTH ENDS.

3 SEAL FITTING INSTALLATION
NTS

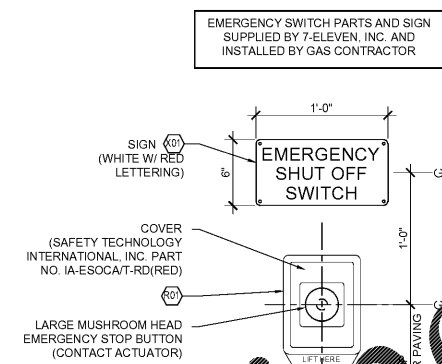

2 EMERGENCY SHUT OFF W/ COVER
NTS

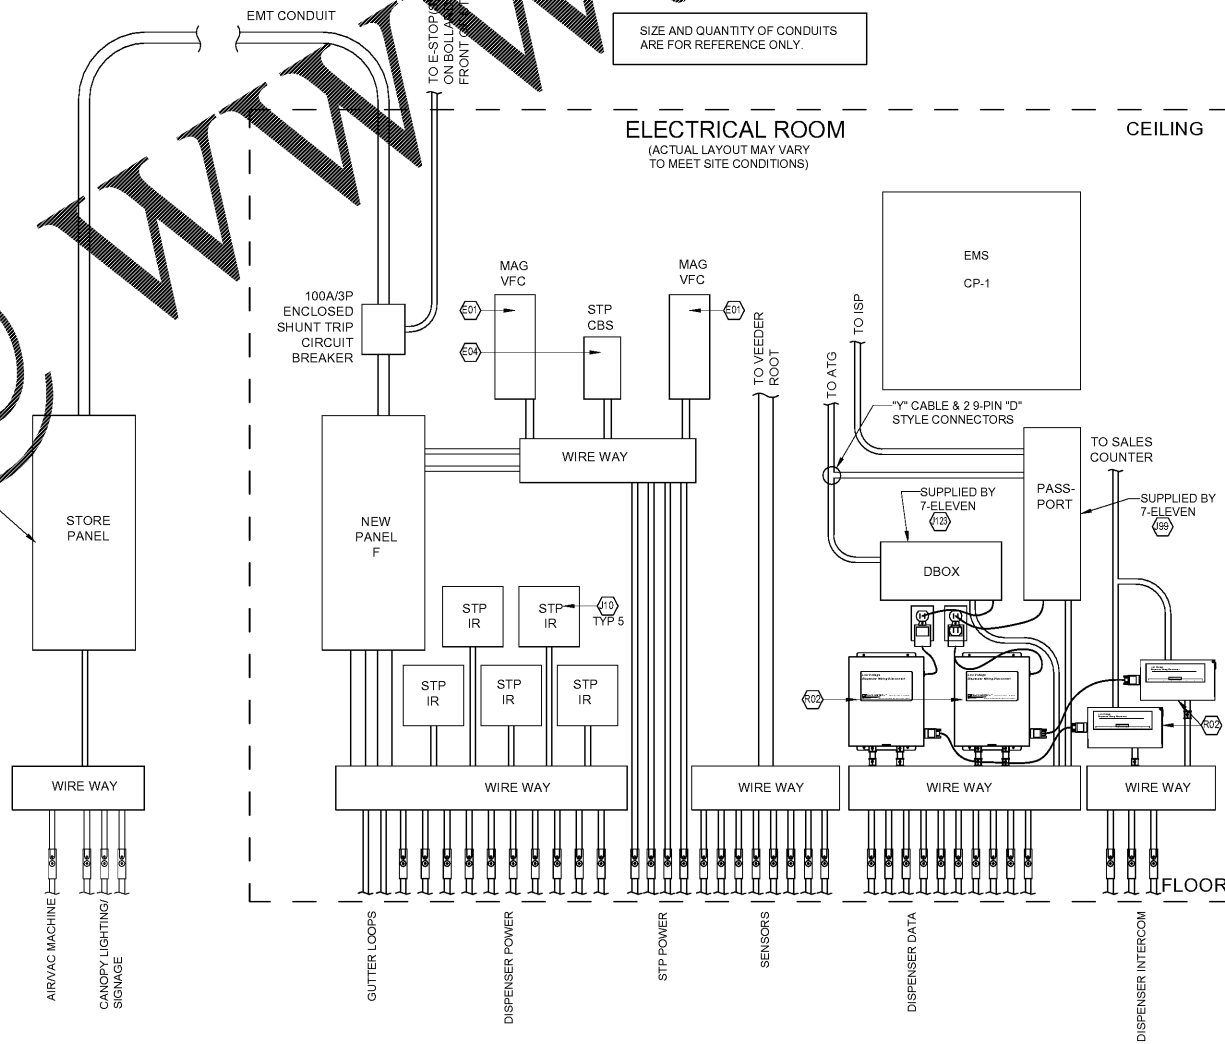

1 POWER/DATA EQUIPMENT DETAILS
NTS

Job#: SEI-20880.521	Scale: AS NOTED	Date: 12/19/17	Drawn By: RMK	Checked By: KMS
<p>Documents prepared by Core States Group are to be used only for the specific project and are not to be used for any other project, by owner or any other party, without the consent of Core States Group. Core States Group is not responsible for the user's own risk. If used in a hazardous location, the user must consult with the manufacturer and Core States Group. Core States Group will not be held liable for any claims and losses.</p>				
<p>7-ELEVEN, INC. 3200 HACKBERRY ROAD, IRVING, TEXAS 75063</p> <p>7-ELEVEN #38227 S.W. CARROLL ST & DYER BLVD KISSIMMEE, FL 34741</p> <p>MISCELLANEOUS ELECTRICAL DETAILS</p>				
<p>Core States Group 1700 Industrial Drive, Suite B Rogers, AR 72756 Fax: (479) 988-4401</p>				
<p>SHEET: G10.0 FUELING - USA</p>				