
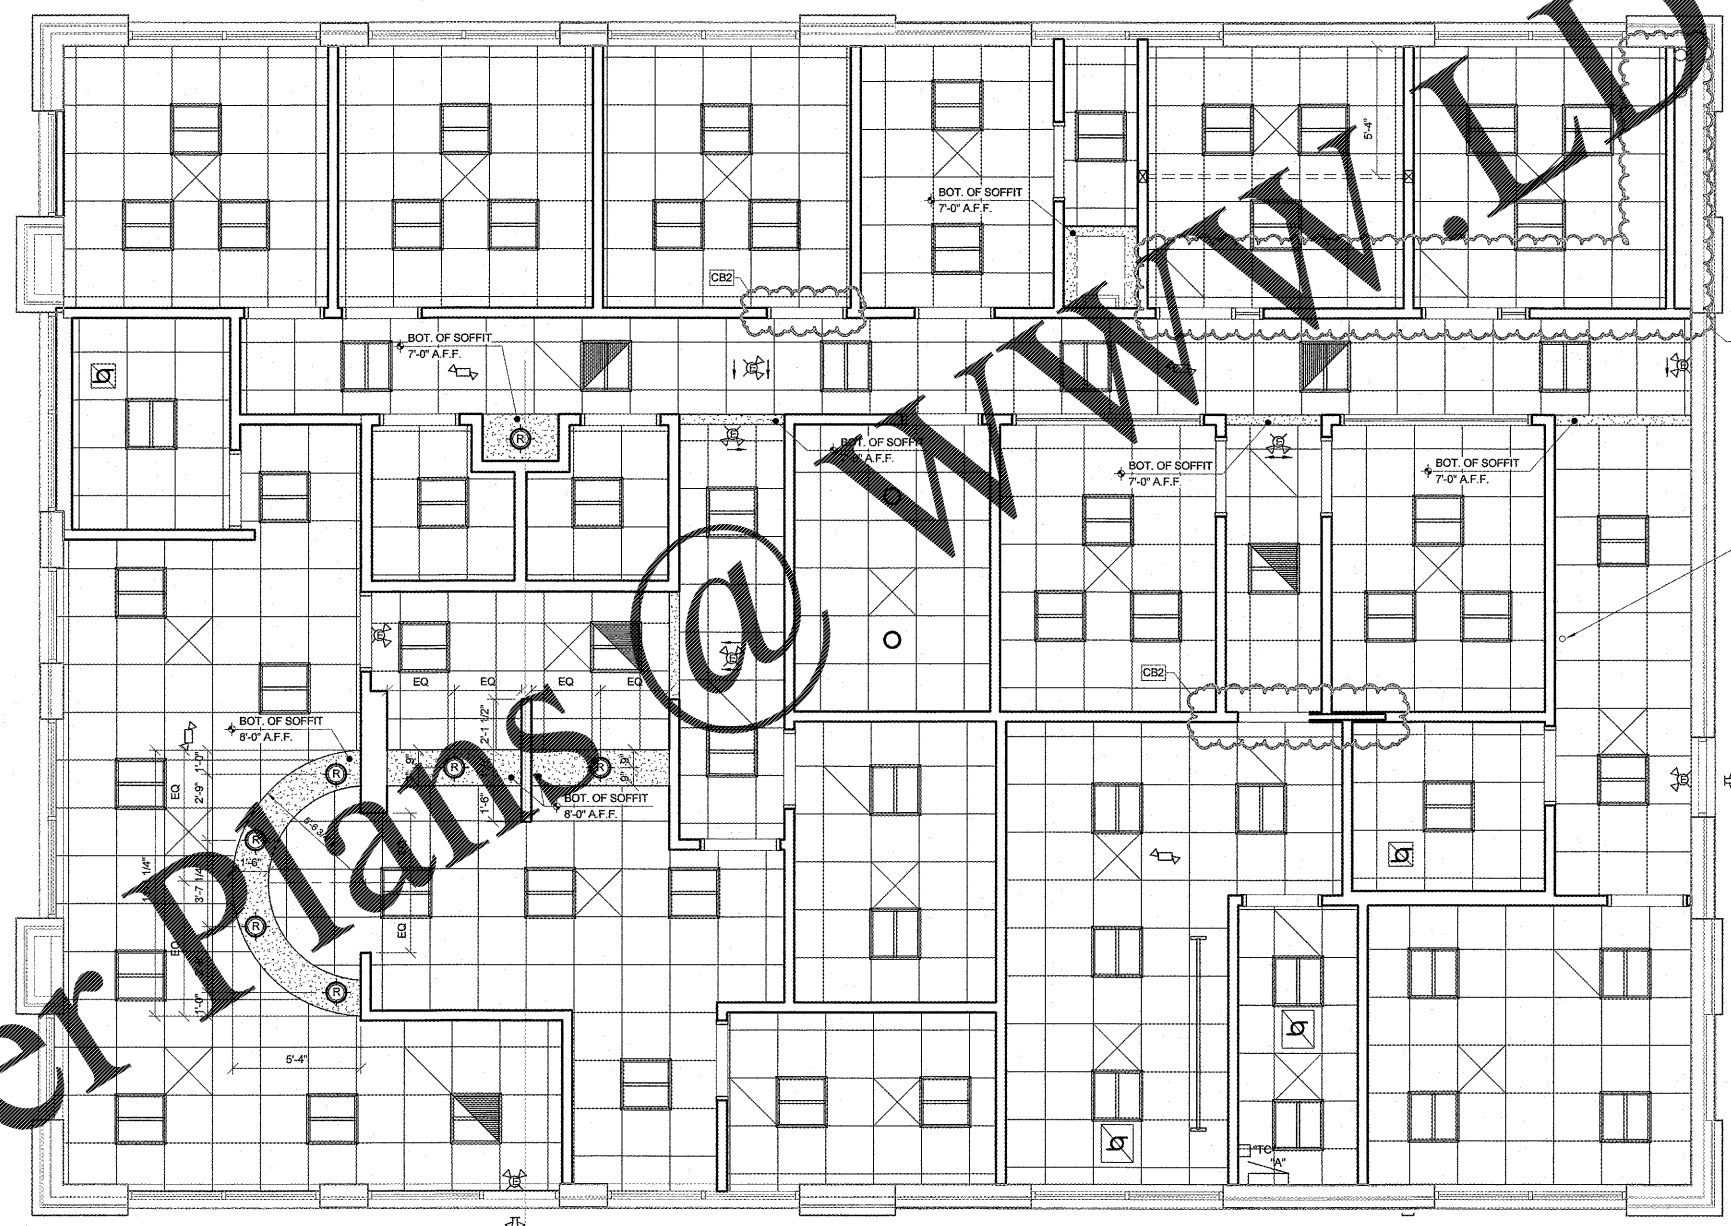


CEILING LEGEND	
	EXHAUST FAN
	6" LED DOWN LIGHT PROVIDED BY OWNER
	2x2 LED LAY-IN TROFFER PROVIDED BY OWNER
	SUSPENDED ACOUSTIC TILE CEILING @ 10'-0" A.F.F., UNLESS OTHERWISE NOTED
	GYPSUM BOARD CEILING
	EXIT LIGHT - PROVIDED BY OWNER
	BATTERY BACK-UP EGRESS LIGHTING - PROVIDED BY OWNER
	EXIT LIGHT W/ BATTERY BACK-UP EGRESS LIGHTING - PROVIDED BY OWNER
<p>LIGHTING NOTE: GENERAL SWITCH LOCATIONS & WIRING TO BE DETERMINED BY LIGHTING CONTRACTOR PER LOCAL CODE AND TO BE APPROVED BY ASPEN DENTAL. ALL CEILING & LIGHT SUPPORT WIRES TO BE HUNG FROM TOP CHORD OF JOIST SYSTEM.</p> <p>RECESSED FIXTURE NOTE: O.C. TO PROVIDE "TENTING" AT ALL RECESSED CAN FIXTURES AS REQUIRED BY THE MANUFACTURER'S WRITTEN INSTRUCTIONS INSURING THAT NO INSULATION TOUCHES THE FIXTURES.</p> <p>NOTE: SEE ROOM FINISH SCHEDULE FOR CEILING FINISH & HEIGHT</p>	

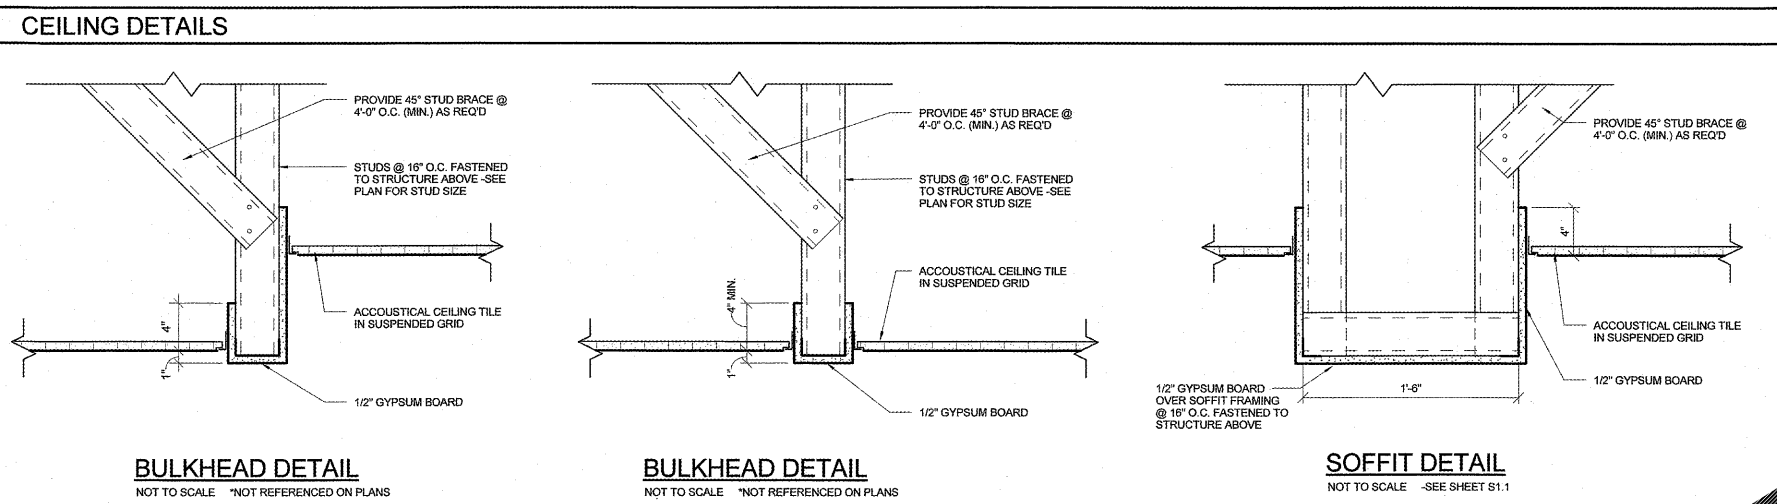

Order Plans @ www.dlLine.com

EXCEL ENGINEERING and ARCHITECTURE, P.C.
108 CAMELOT DRIVE
FOND DU LAC, WI 54935
PHONE: (920) 926-9800
WWW.EXCELENGINEER.COM

COLLABORATION
AspenDental

PROJECT INFORMATION
PROJECT NUMBER 1712680

TENANT BUILD-OUT FOR:
ASPEN DENTAL
3070 WILLIAM ST. • CAPE GIRARDEAU, MO 63703

PROFESSIONAL SEAL

SHEET DATES

SHEET ISSUE	JUNE 1, 2017
-------------	--------------

REVISIONS

AD1	JUNE 6, 2017
AD2	JUNE 22, 2017
CB2	DEC. 19, 2017

REVIEWED FOR CODE COMPLIANCE
JAN 05 2018
RETAIN AT JOB SITE
Approved By: *[Signature]*
CITY OF CAPE GIRARDEAU, Inspection Services

REFLECTED CEILING PLAN
SCALE: 1/4" = 1'-0"

SHEET INFORMATION
REFLECTED CEILING PLAN & DETAILS
SHEET NUMBER
A7.1

2016 © EXCEL ENGINEERING, INC.